



PL: Project: B:\2016\160008-000\Design\Main\1616008-000\_M-200.dwg  
LOGIN: Cavasbert, David  
PLOT DATE: 4/12/2016 4:23 PM  
SAVE DATE: 4/12/2016 2:38 PM

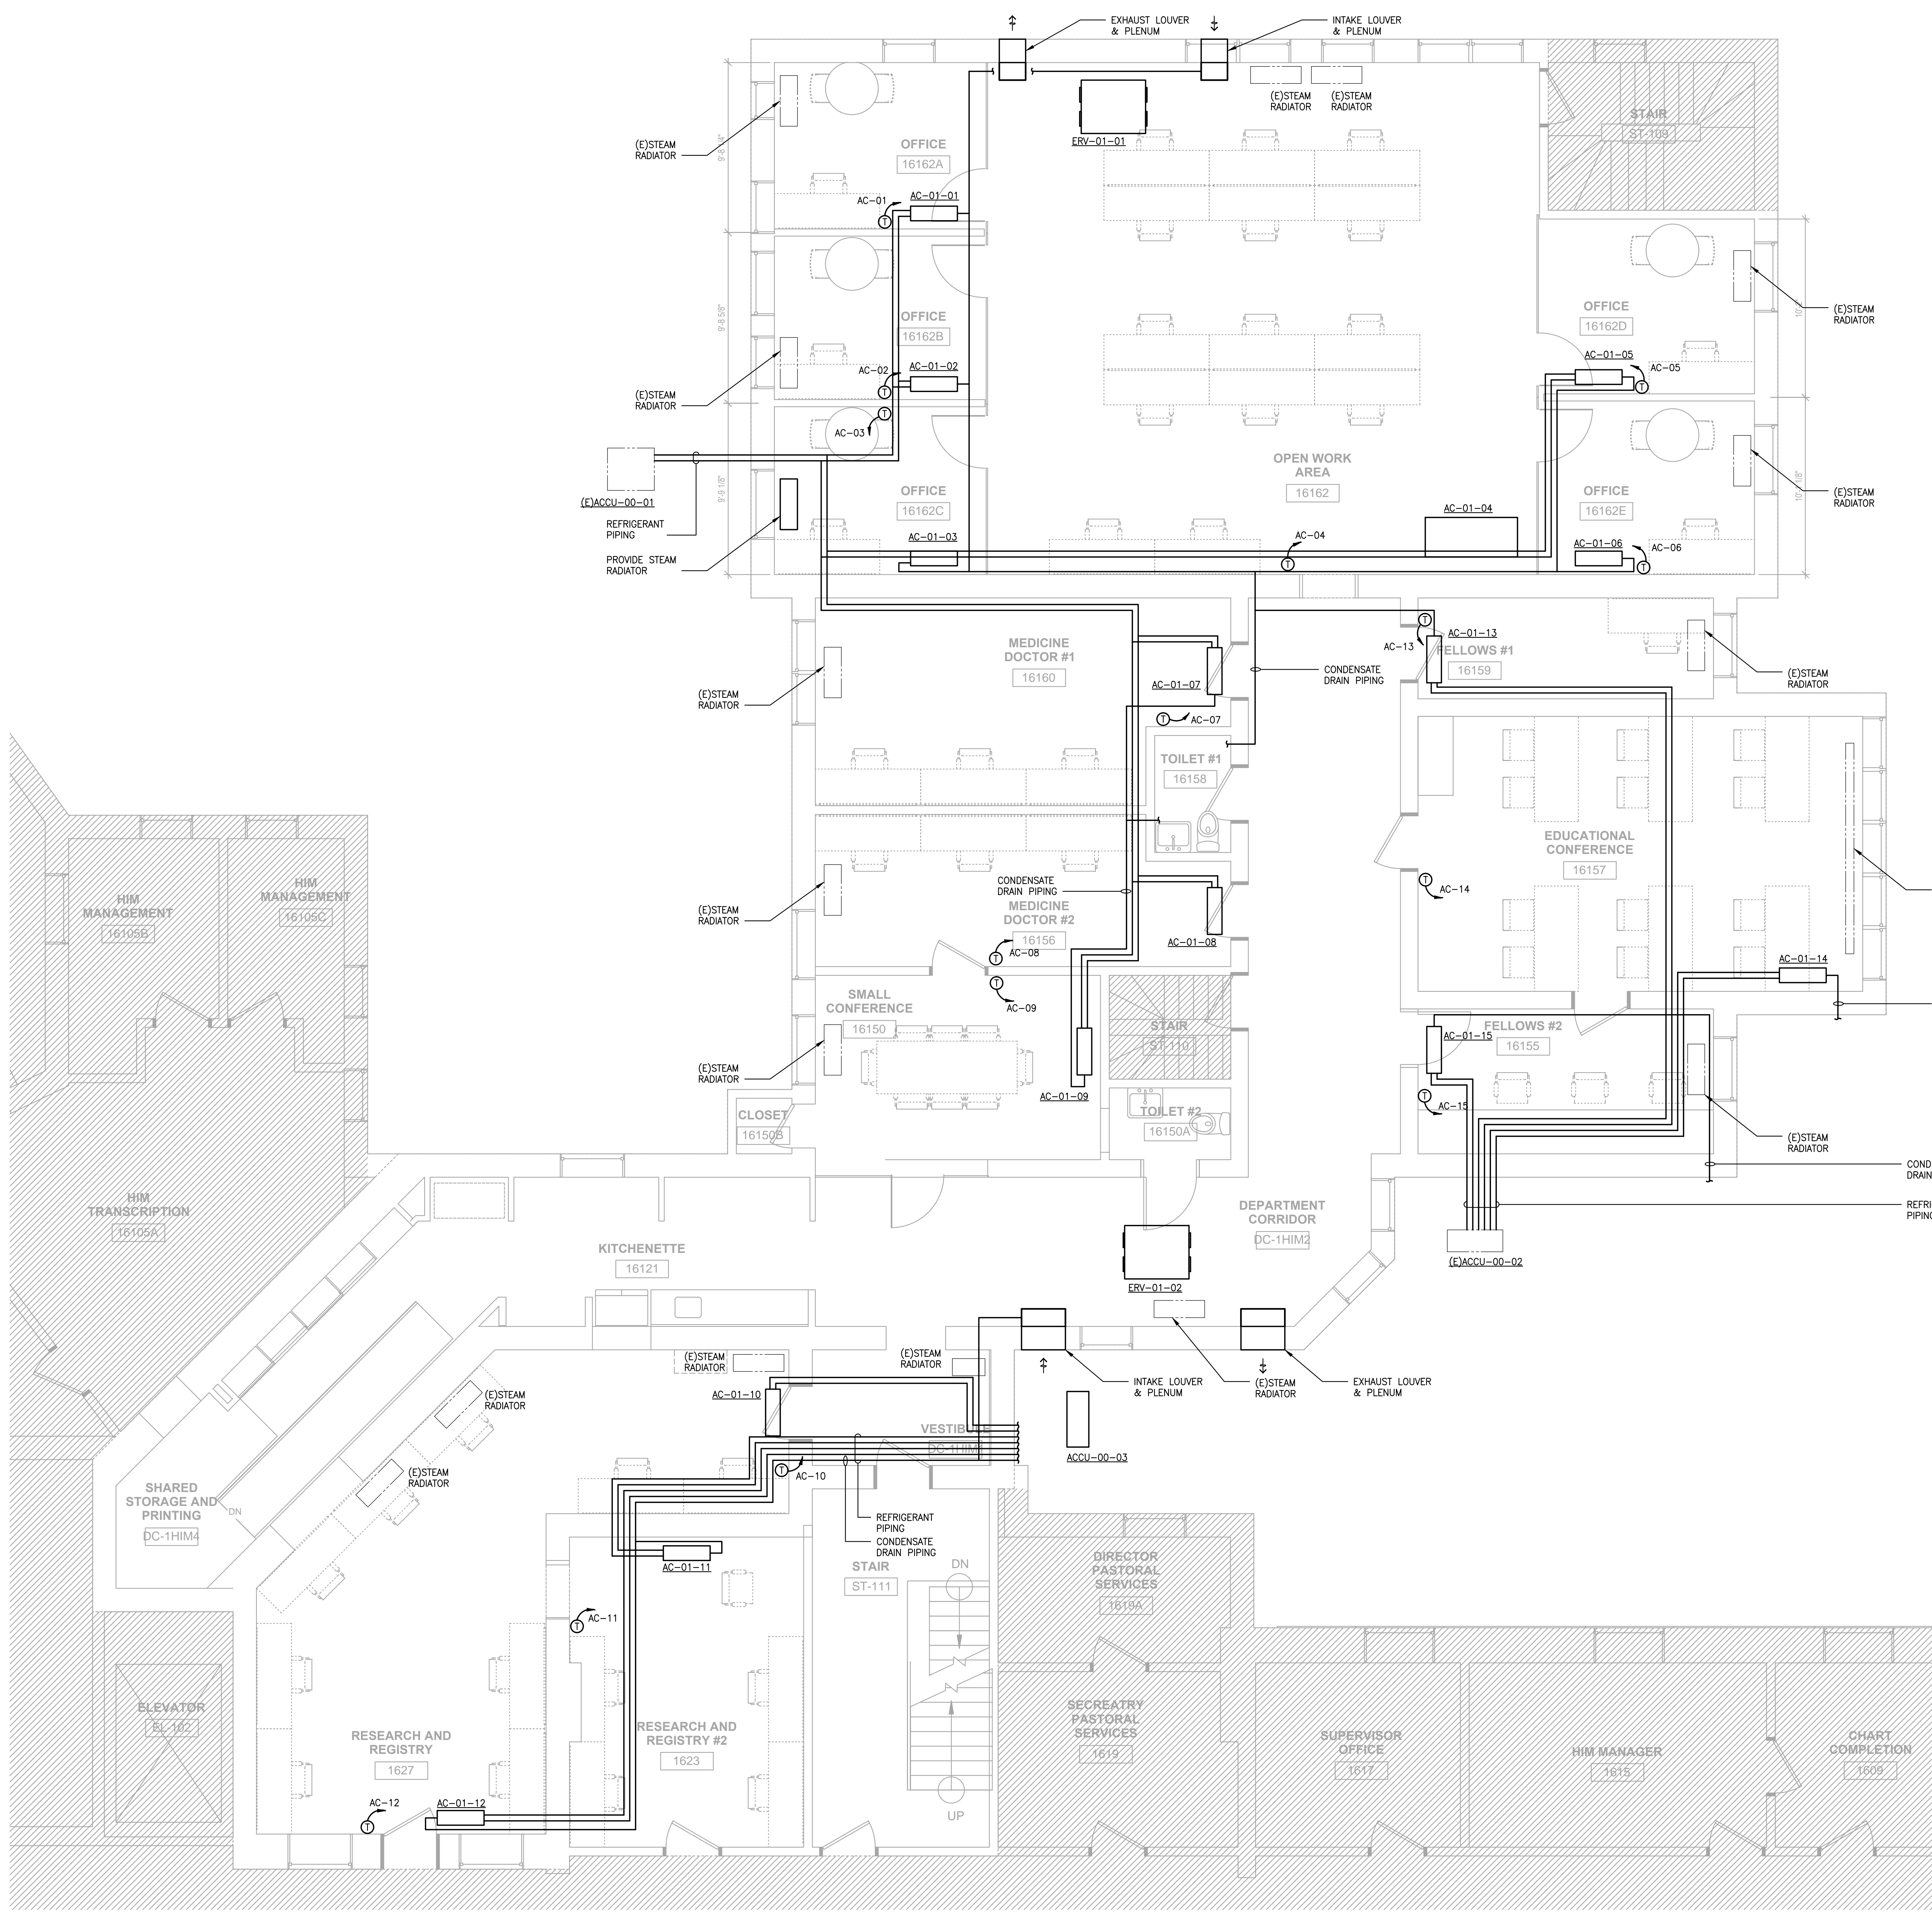

225 Franklin Street, Suite 1100  
Boston, MA 02110  
1617.478.0300  
1617.478.0321  
www.perkinswill.com

**CONSULTANTS**  
**AKF GROUP LLC**  
MEPPF  
99 Bedford St., 2nd Floor  
Boston, MA 02111  
1617.737.1111  
1617.737.4311

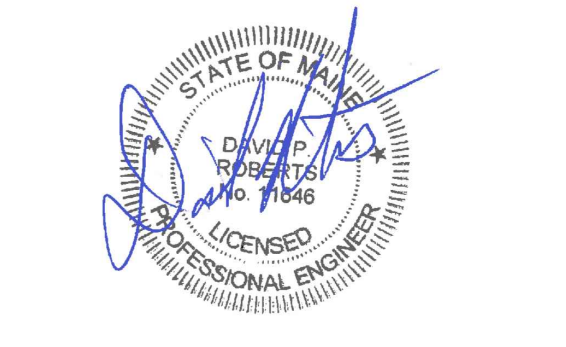

**PROJECT**  
**ACCU RELOCATION**  
22 Bramhall Street  
Portland, Maine 04102



**MAINE MEDICAL CENTER**  
22 Bramhall Street  
Portland, Maine 04102

**ISSUED FOR PERMIT**  
04/01/2016  
**ISSUE CHART**

NO.	ISSUE	DATE
1	Job Number	B160089-000
2	Checked	
3	Approved	

**TITLE**  
**MECHANICAL PIPING FLOOR PLAN**

**SHEET NUMBER**  
**M-200**