

CONSULTANTS

AKF GROUP LLC
99 Bradford Street, 2nd Floor
Boston, MA 02211
1617.737.1111
1617.737.4311


**STRUCTURAL
SGH INC.**
41 Sevon St.
Waltham, MA 02453
1781.907.9000
1781.907.9009

PROJECT

**ACCU
RELOCATION**
22 Bramhall Street
Portland, Maine 04102

Maine Medical Center
MaineHealth

**MAINE MEDICAL
CENTER**
22 Bramhall Street
Portland, Maine 04102

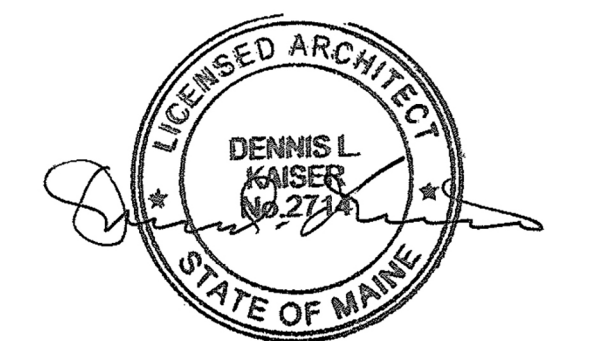

06.24.2016


ISSUE CHART

NO.	ISSUE	DATE
1	ISSUED FOR PERMIT	06.24.2016
2	ISSUE	06.24.2016
3	Job Number	152168.029
4	Checked	Checker
5	Approved	Approver

**RICHARDS 8 -
OVERALL RCP**

SHEET NUMBER

A12-21

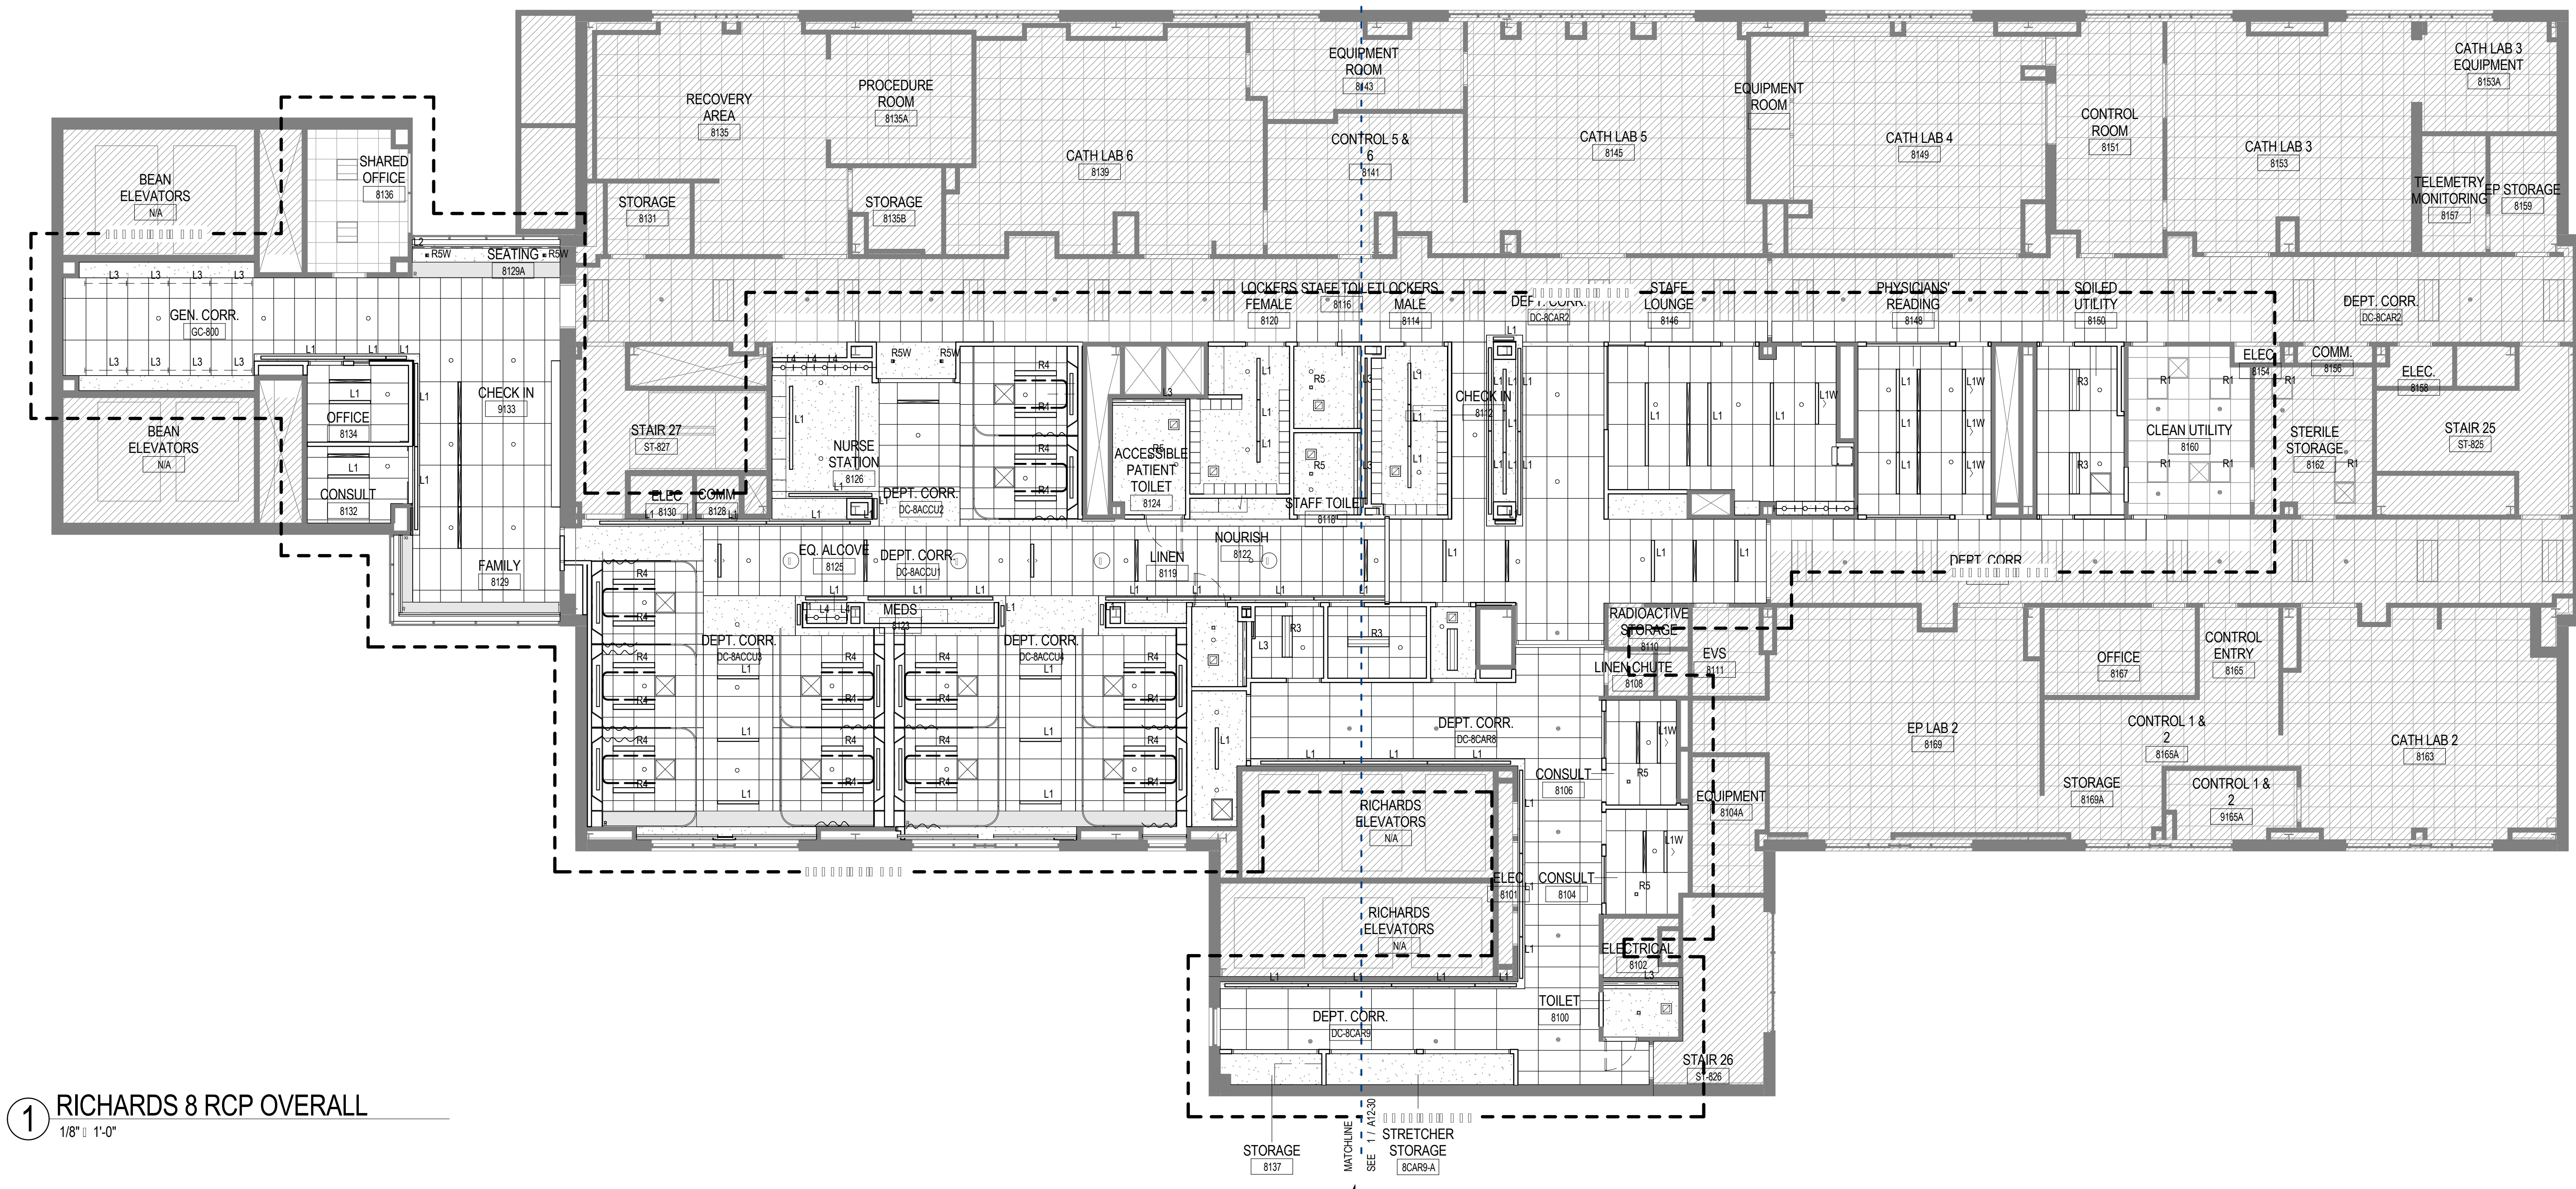

1 RICHARDS 8 RCP OVERALL
1/8" = 1'-0"

REFLECTED CEILING PLAN LEGEND

	L1 RECESSED LINEAR SLOT - LED
	L1W RECESSED LINEAR SLOT - WALLWASH
	L2 RECESSED LINEAR T8 DOWNLIGHT - 4" APERTURE
	L3 LINEAR SURFACE MOUNTED T8 COVE - ASYMETRIC OPTICS
	L4 LINEAR LED - UNDER CAB
	L5 LINEAR WALL MOUNTED T8 - 8" @ 2" PROFILE
	R1 2'x2' TROFFER FIT TURE
	R2 2'x4' TROFFER FIT TURE
	R3 1'x4' TROFFER FIT TURE
	R4 RECESSED CEILING FLUORESCENT T5HO, ASYMETRIC ANTI-MICROBIAL
	R5 RECESSED DOWNLIGHT
	R5W RECESSED DOWNLIGHT - WALLWASH

REFLECTED CEILING PLAN LEGEND

	CEILING MOUNTED CAMERA
	CEILING MOUNTED PROJECTOR
	IT SIGN
	SPRINKLER HEAD
	EMERGENCY STROBE
	EMERGENCY SPOTLIGHT
	CEILING HEIGHT

REFLECTED CEILING PLAN LEGEND

	DRYWALL CEILING / SOFFIT
	2'x2' ACOUSTICAL CEILING GRID AND TILE
	2'x4' ACOUSTICAL CEILING GRID AND TILE
	ACCESS PANEL
	SUPPLY DIFFUSER
	RETURN DIFFUSER
	LINEAR DIFFUSER
	SLOT DIFFUSER
	CEILING MOUNTED OCCUPANCY SENSOR
	LIGHT LEVEL SENSOR
	CEILING MOUNTED SPEAKER (AV, PAGING, WHITE NOISE)
	WIRELESS ACCESS POINT