

CONSULTANTS

AKF GROUP LLC
MEPP
99 Bradford Street, 2nd Floor
Boston, MA 02211
1617.737.1111
1617.737.4311



**STRUCTURAL
SGH INC.**
41 Sevon St.
Waltham, MA 02453
1781.907.9000
1781.907.9009

PROJECT

**ACCU
RELOCATION**
22 Bramhall Street
Portland, Maine 04102

**Maine Medical Center
MaineHealth**

**MAINE MEDICAL
CENTER**
22 Bramhall Street
Portland, Maine 04102

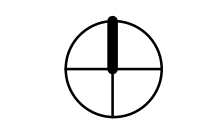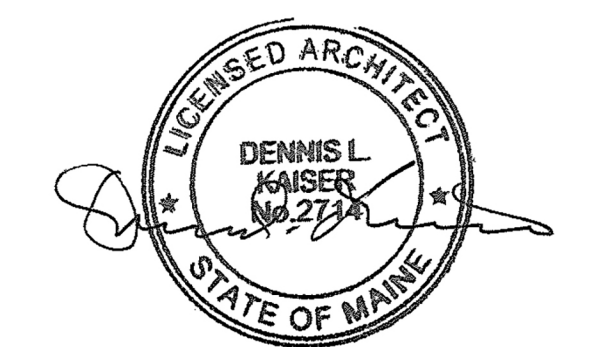

06.24.2016

ISSUE CHART


NO.	ISSUE	DATE
1	ISSUED FOR PERMIT	06.24.2016
2	ISSUE	
3	DATE	
Job Number	152168.029	
Checked		
Approved		

TITLE

**RICHARDS 8 -
ENLARGED
RCP -
EAST**

SHEET NUMBER

A12-31

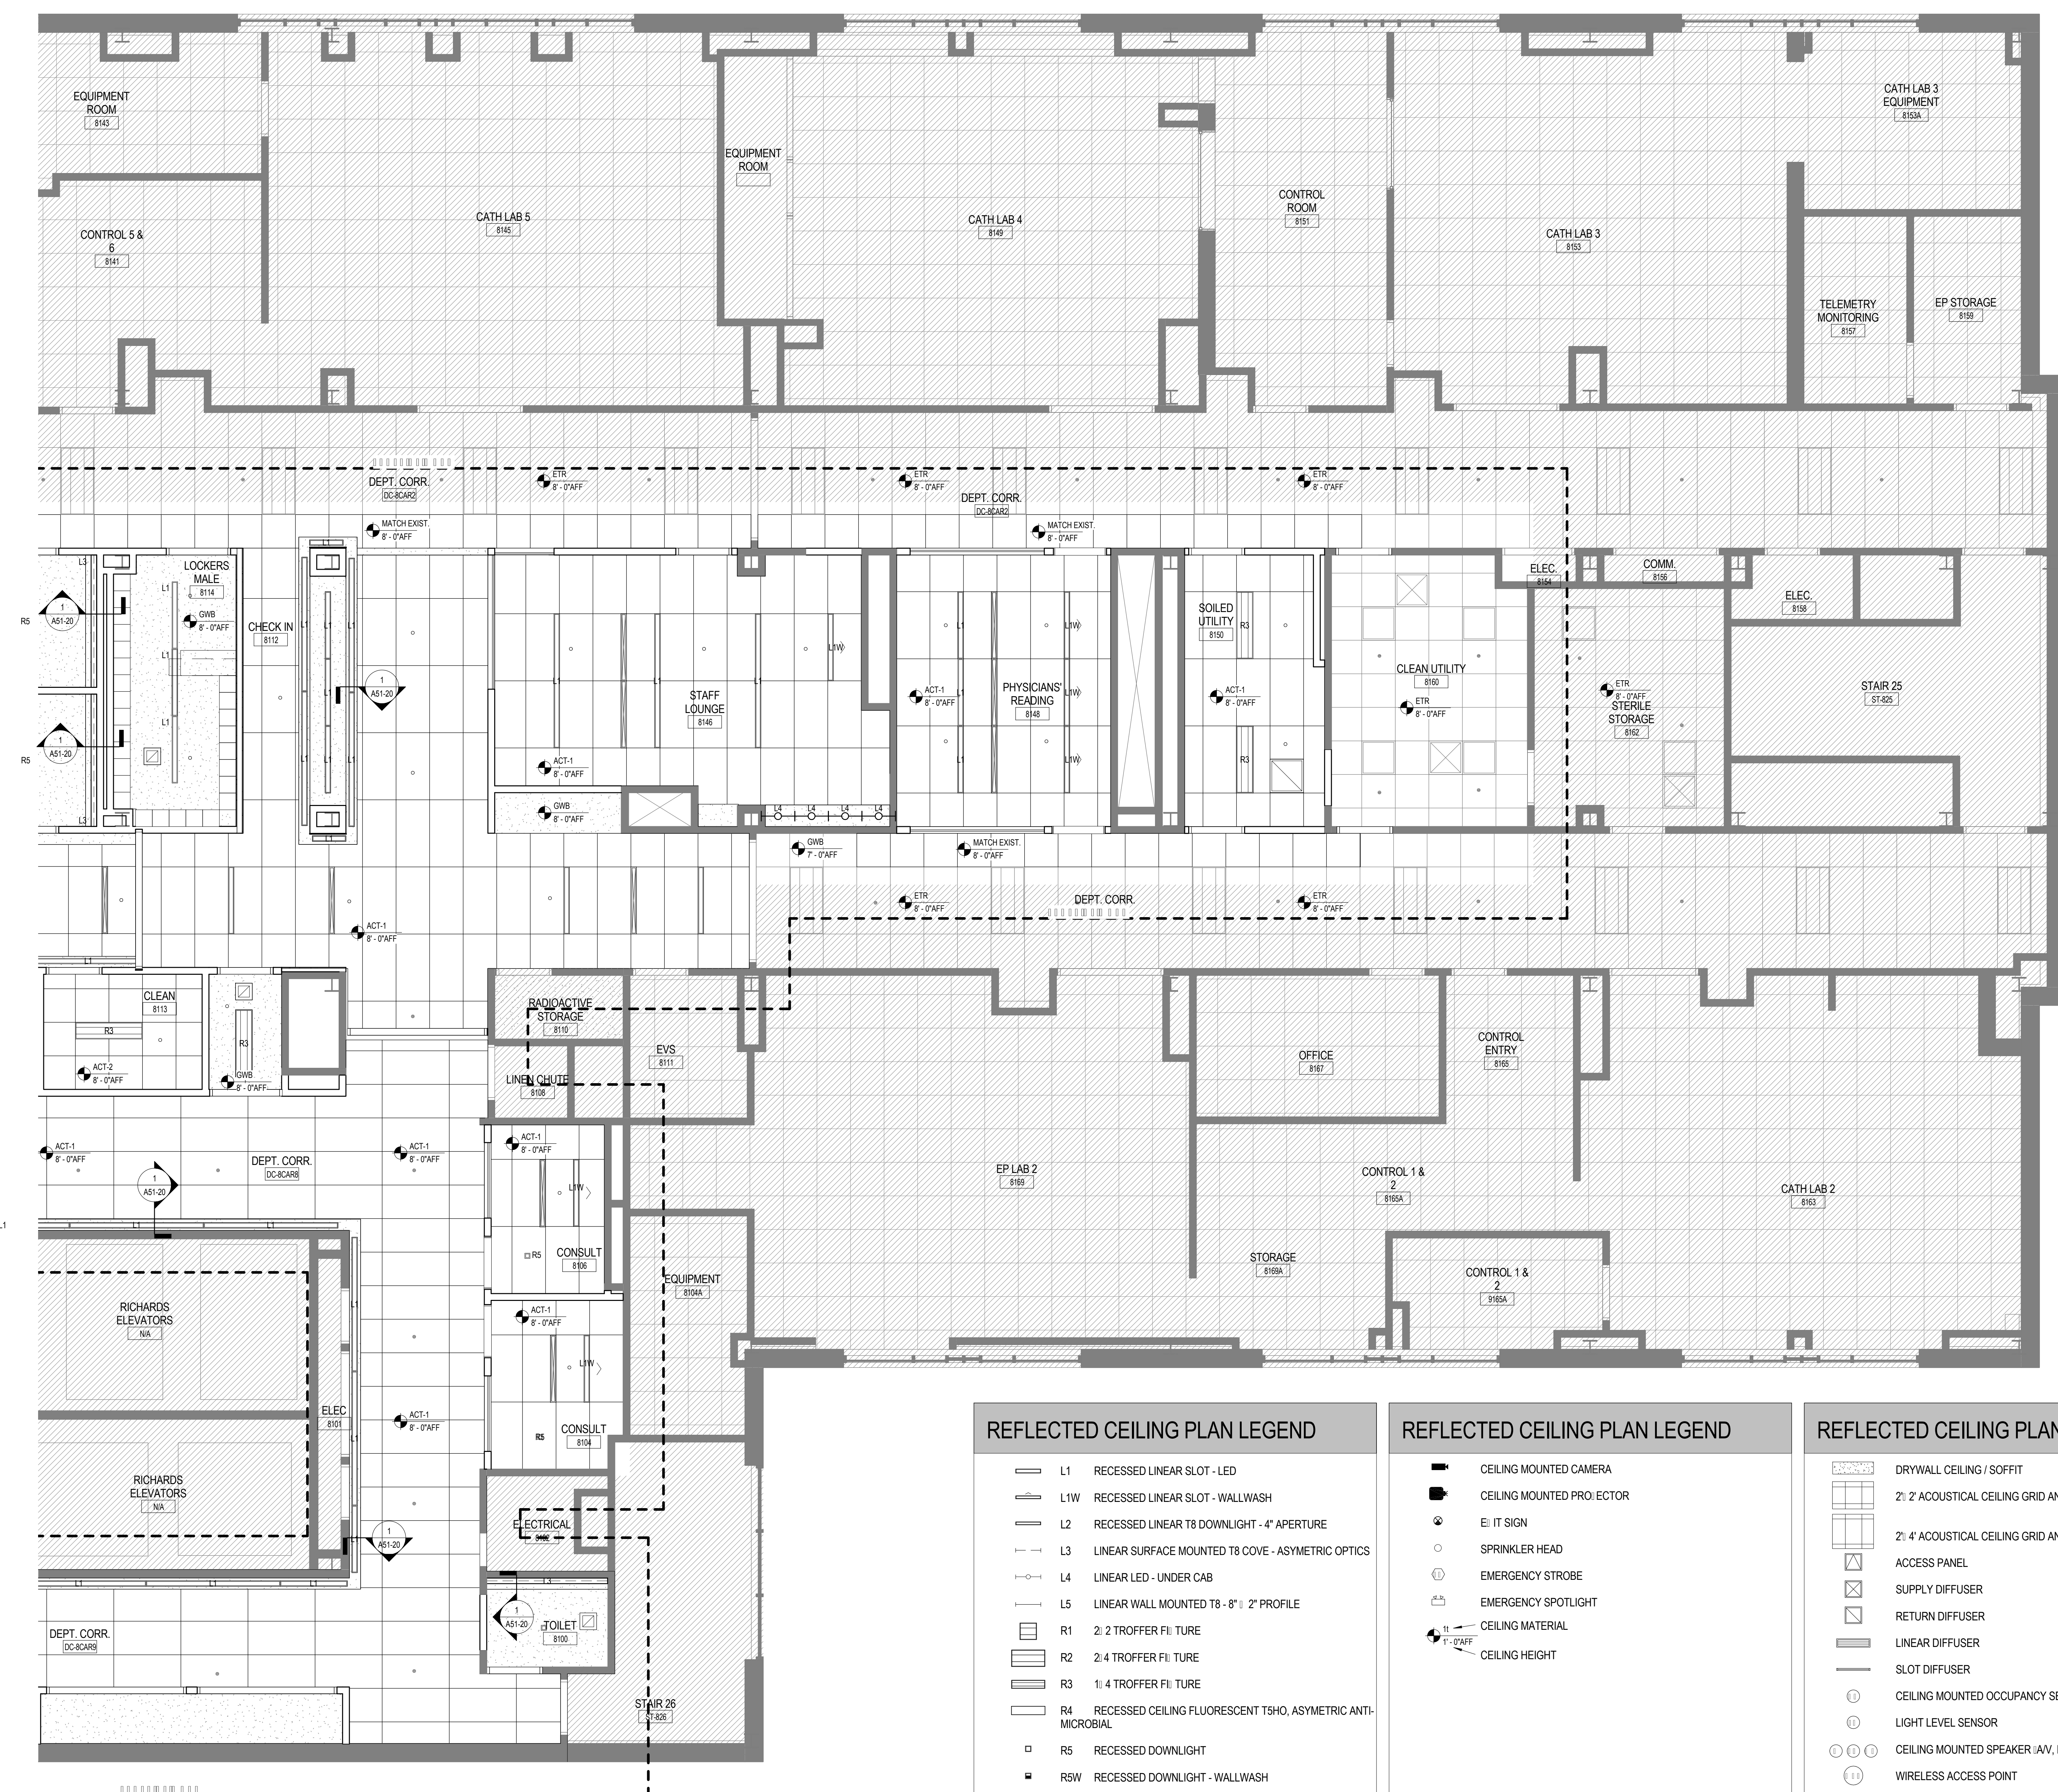

REFLECTED CEILING PLAN LEGEND

	L1 RECESSED LINEAR SLOT - LED
	L1W RECESSED LINEAR SLOT - WALLWASH
	L2 RECESSED LINEAR T8 DOWNLIGHT - 4" APERTURE
	L3 LINEAR SURFACE MOUNTED T8 COVE - ASYMETRIC OPTICS
	L4 LINEAR LED - UNDER CAB
	L5 LINEAR WALL MOUNTED T8 - 8" x 2" PROFILE
	R1 2x2 TROFFER FLUORESCENT
	R2 2x4 TROFFER FLUORESCENT
	R3 1x4 TROFFER FLUORESCENT
	R4 RECESSED CEILING FLUORESCENT T5HO, ASYMETRIC ANTI-MICROBIAL
	R5 RECESSED DOWNLIGHT
	R5W RECESSED DOWNLIGHT - WALLWASH

REFLECTED CEILING PLAN LEGEND

	CEILING MOUNTED CAMERA
	CEILING MOUNTED PROJECTOR
	IT SIGN
	SPRINKLER HEAD
	EMERGENCY STROBE
	EMERGENCY SPOTLIGHT
	CEILING MATERIAL
	CEILING HEIGHT

REFLECTED CEILING PLAN LEGEND

	DRYWALL CEILING / SOFFIT
	2' x 2' ACOUSTICAL CEILING GRID AND TILE
	2' x 4' ACOUSTICAL CEILING GRID AND TILE
	ACCESS PANEL
	SUPPLY DIFFUSER
	RETURN DIFFUSER
	LINEAR DIFFUSER
	SLOT DIFFUSER
	CEILING MOUNTED OCCUPANCY SENSOR
	LIGHT LEVEL SENSOR
	CEILING MOUNTED SPEAKER -AV, PAGING, WHITE NOISE
	WIRELESS ACCESS POINT