




225 Franklin Street, Suite 1100
 Boston, MA 02110
 1617-478-0300
 1617-478-0321
 www.perkinswill.com

CONSULTANTS

MEPP
AKF GROUP LLC
 99 Bedford St., 2nd Floor
 Boston, MA 02111
 1617-737-1111
 1617-737-4311

STRUCTURAL
SGH INC.
 41 Seyon St.
 Waltham, MA 02453
 1781-907-8000
 1781-907-9009

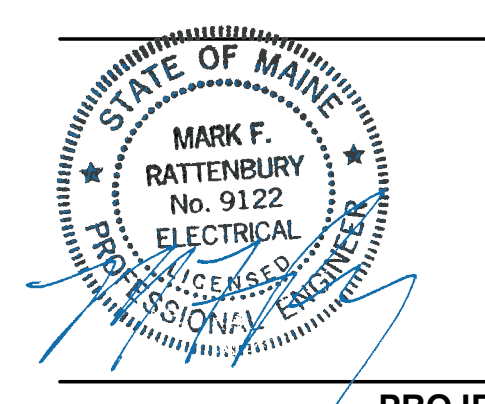

PROJECT

ACCU RELOCATION
 22 Bramhall Street
 Portland, Maine 04102




MAINE MEDICAL CENTER
 22 Bramhall Street
 Portland, Maine 04102

06.24.2016
ISSUE CHART

NO.	ISSUE	DATE
1	ISSUED FOR PERMIT	06.24.2016
2	ISSUE	DATE
Job Number	B160089-000	
Checked	MFR	
Approved		

TITLE
RICHARDS 8 - FIRE ALARM PLAN - WEST

SHEET NUMBER
FA01-02

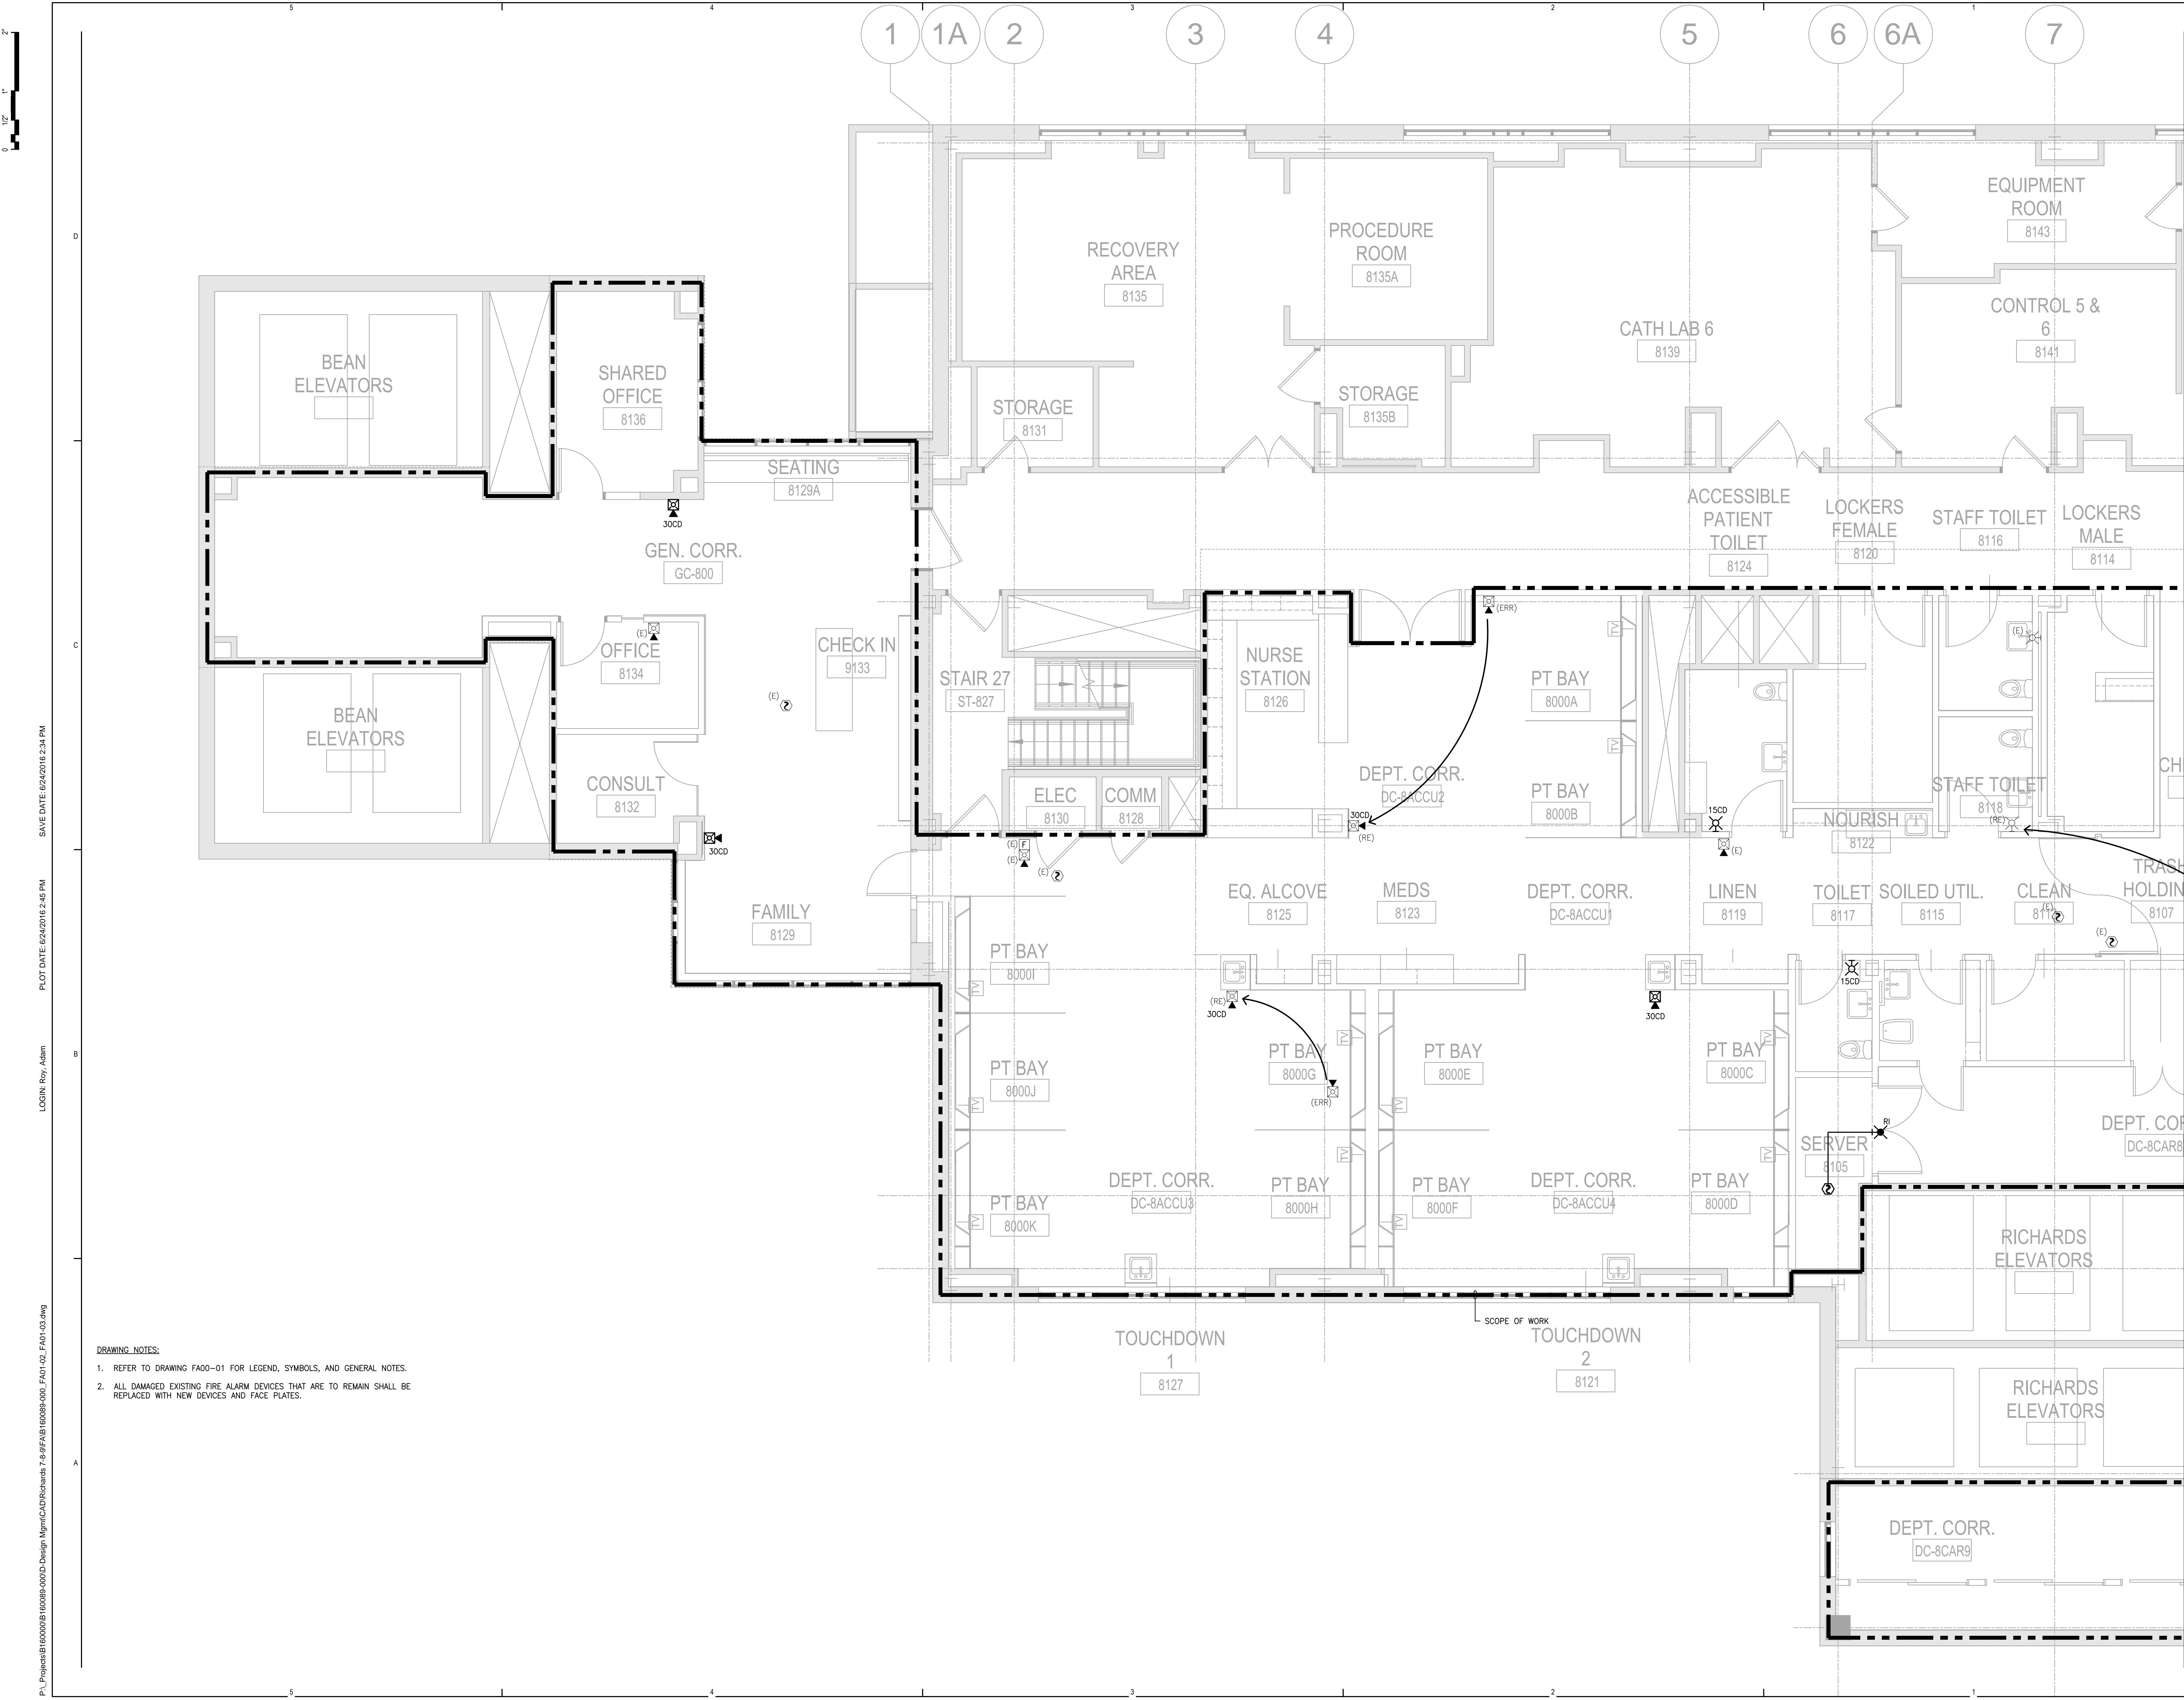

- DRAWING NOTES:**
1. REFER TO DRAWING FA00-01 FOR LEGEND, SYMBOLS, AND GENERAL NOTES.
 2. ALL DAMAGED EXISTING FIRE ALARM DEVICES THAT ARE TO REMAIN SHALL BE REPLACED WITH NEW DEVICES AND FACE PLATES.

SAVE DATE: 06/24/2016 2:34 PM
 PLOT DATE: 06/24/2016 2:45 PM
 LOGIN: Roy, Adam
 PL: Project\B160089-000\B160089-000-DWG\Richards 7-8-RT\FAB160089-000_FA01-02_FA01-02.dwg