




225 Franklin Street, Suite 1100  
Boston, MA 02110  
1617.478.0200  
1617.478.0221  
www.perkinswill.com

**CONSULTANTS**

**MEFP**  
**AKF GROUP LLC**  
99 Bedford St., 2nd Floor  
Boston, MA 02111  
1617.737.1111  
1617.737.4311

**STRUCTURAL**  
**SGH INC.**  
41 Seyon St.  
Waltham, MA 02453  
1781.907.9000  
1781.907.9009

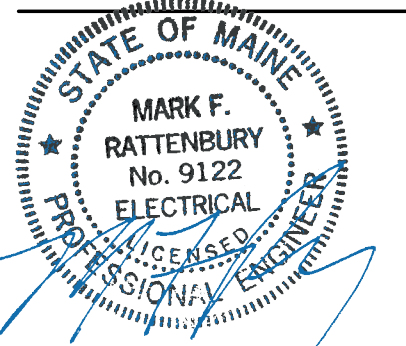

**PROJECT**

**ACCU RELOCATION**  
22 Bramhall Street  
Portland, Maine 04102




**MAINE MEDICAL CENTER**  
22 Bramhall Street  
Portland, Maine 04102

06.24.2016  
**ISSUE CHART**

NO.	ISSUE	DATE
1	ISSUED FOR PERMIT	06.24.2016
2	Job Number	B160089-000
3	Checked	MFR
4	Approved	

**TITLE**  
**RICHARDS 9 - FIRE ALARM PLAN - WEST**

**SHEET NUMBER**  
**FA01-04**

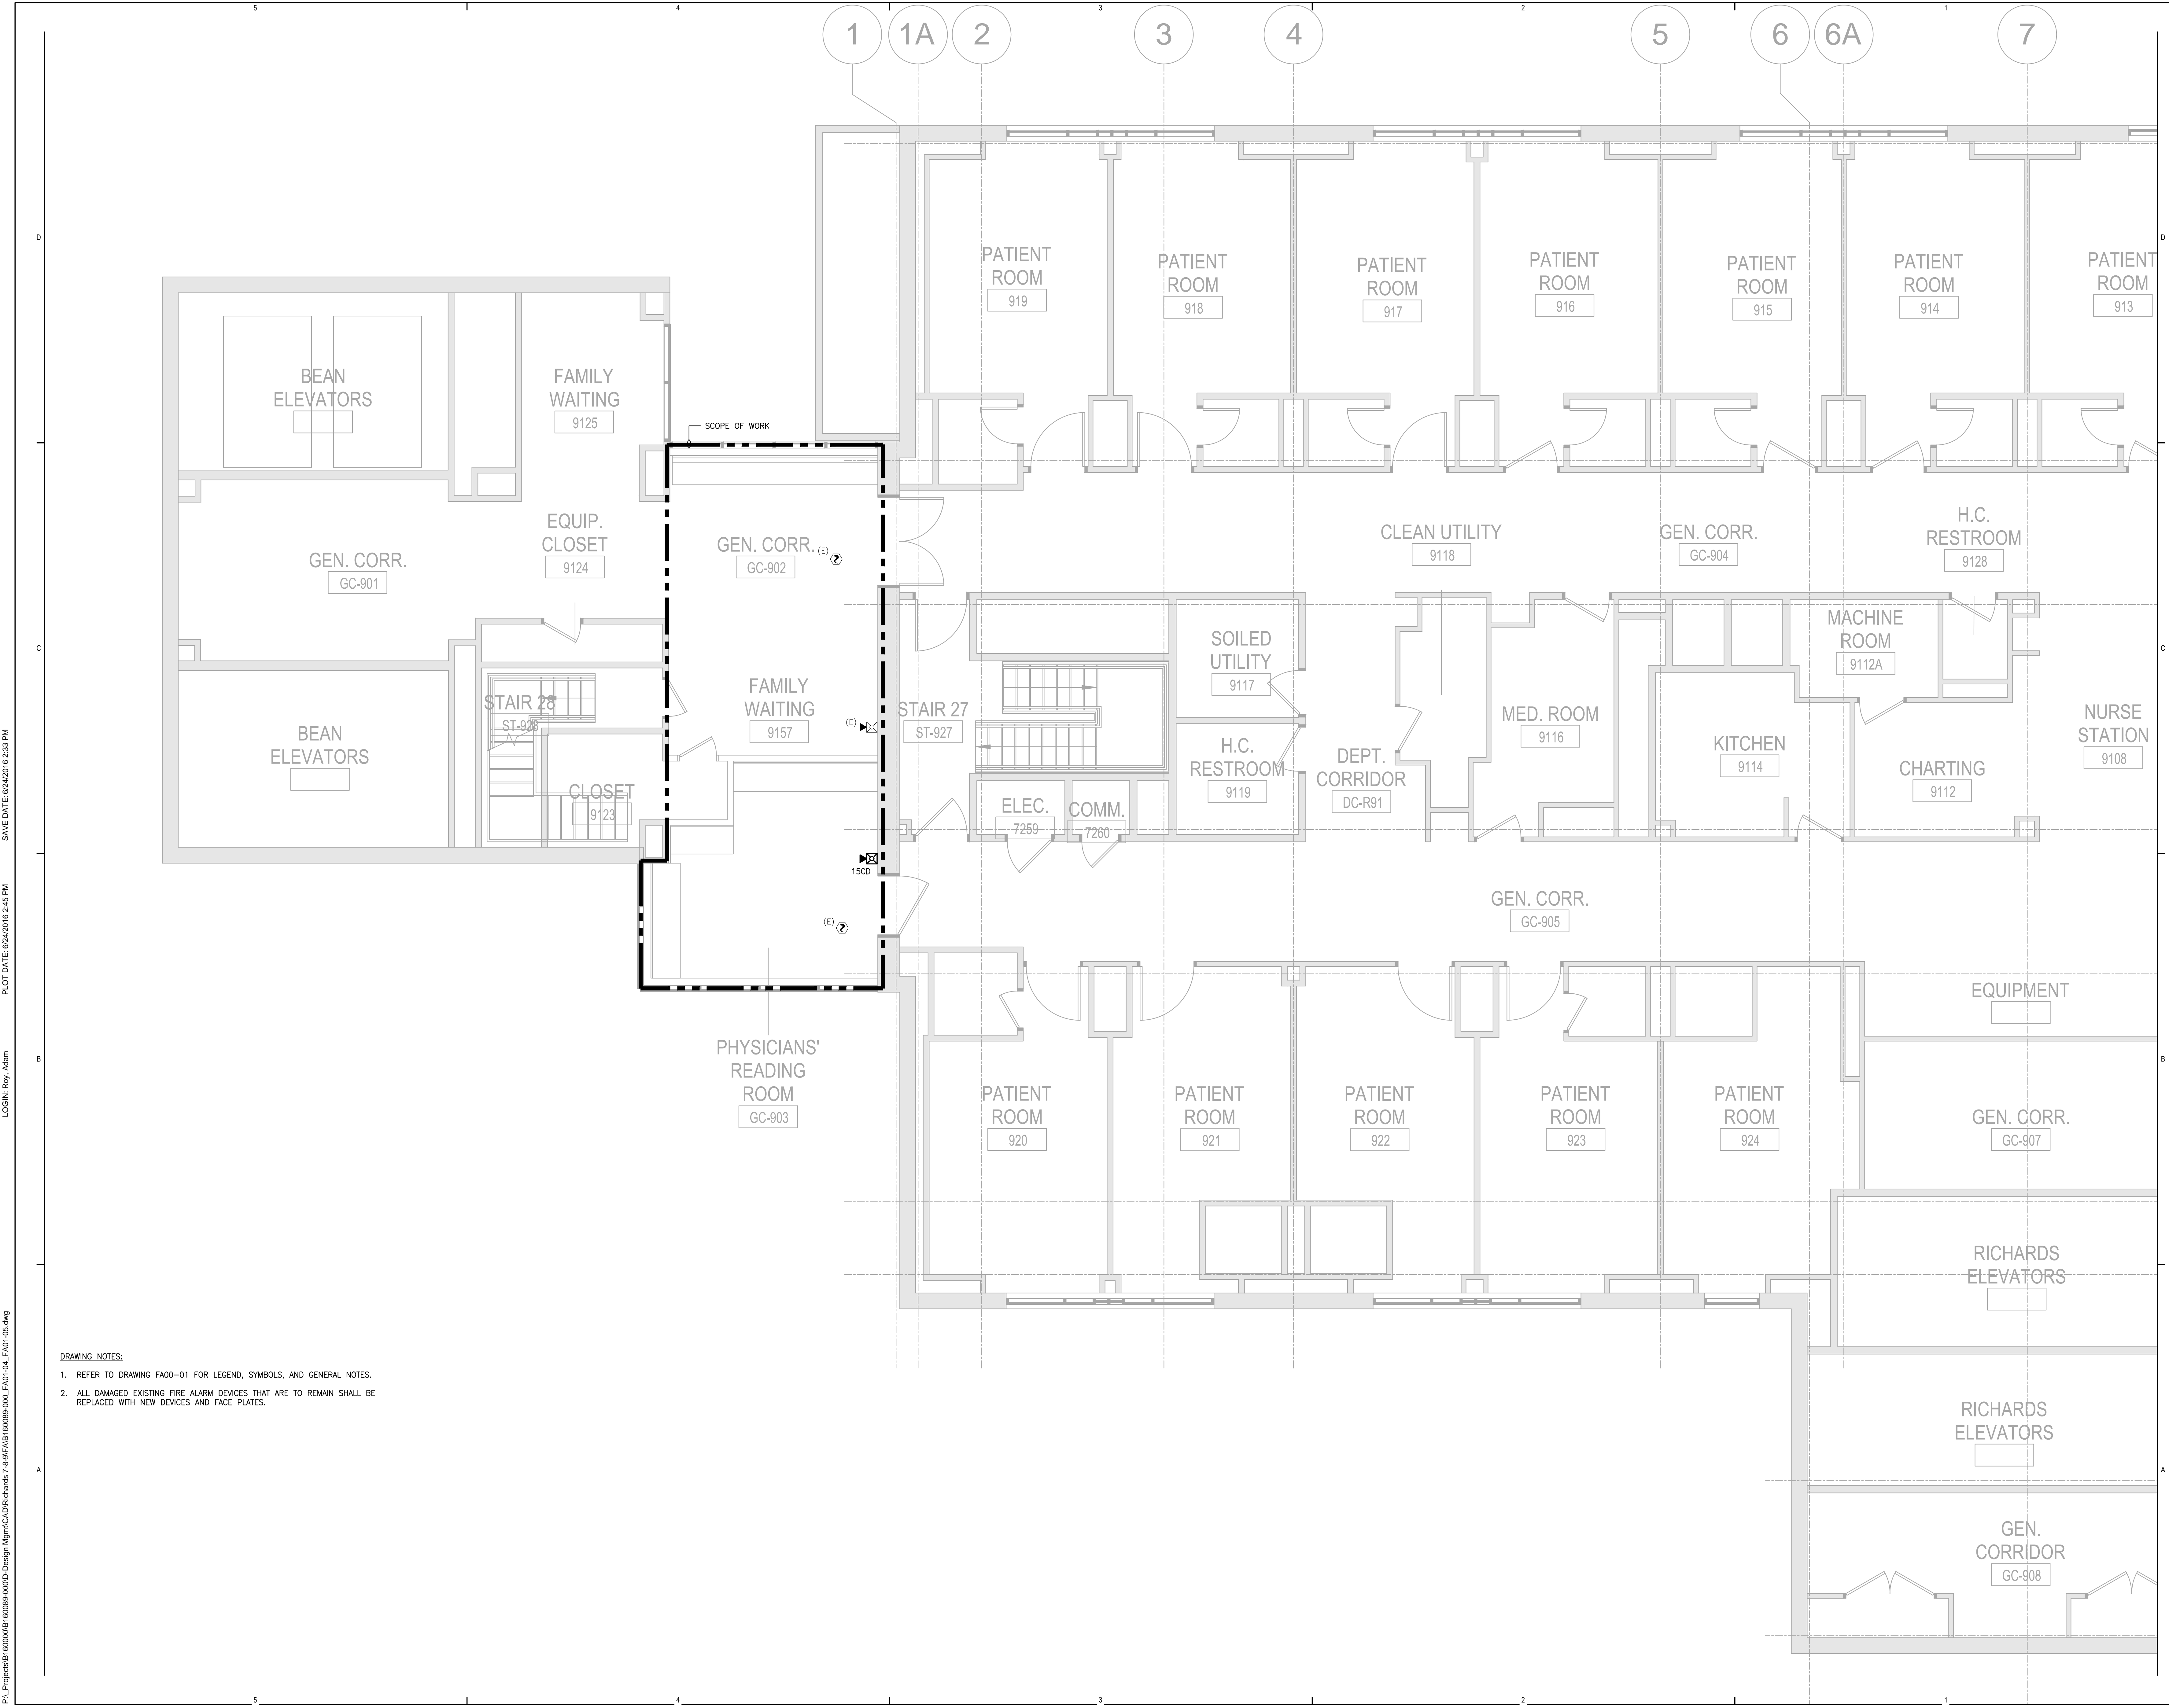

- DRAWING NOTES:**
1. REFER TO DRAWING FA00-01 FOR LEGEND, SYMBOLS, AND GENERAL NOTES.
  2. ALL DAMAGED EXISTING FIRE ALARM DEVICES THAT ARE TO REMAIN SHALL BE REPLACED WITH NEW DEVICES AND FACE PLATES.

LOGIN: Roy, Adam  
 PLOT DATE: 06/24/2016 2:45 PM  
 SAVE DATE: 06/24/2016 2:33 PM  
 PL: Project\B1600089\B160089-000-DWG\Richards 9 - Fire Alarm\Richards 9 - Fire Alarm\B160089-000\_FA01-04\_FA01-05.dwg