


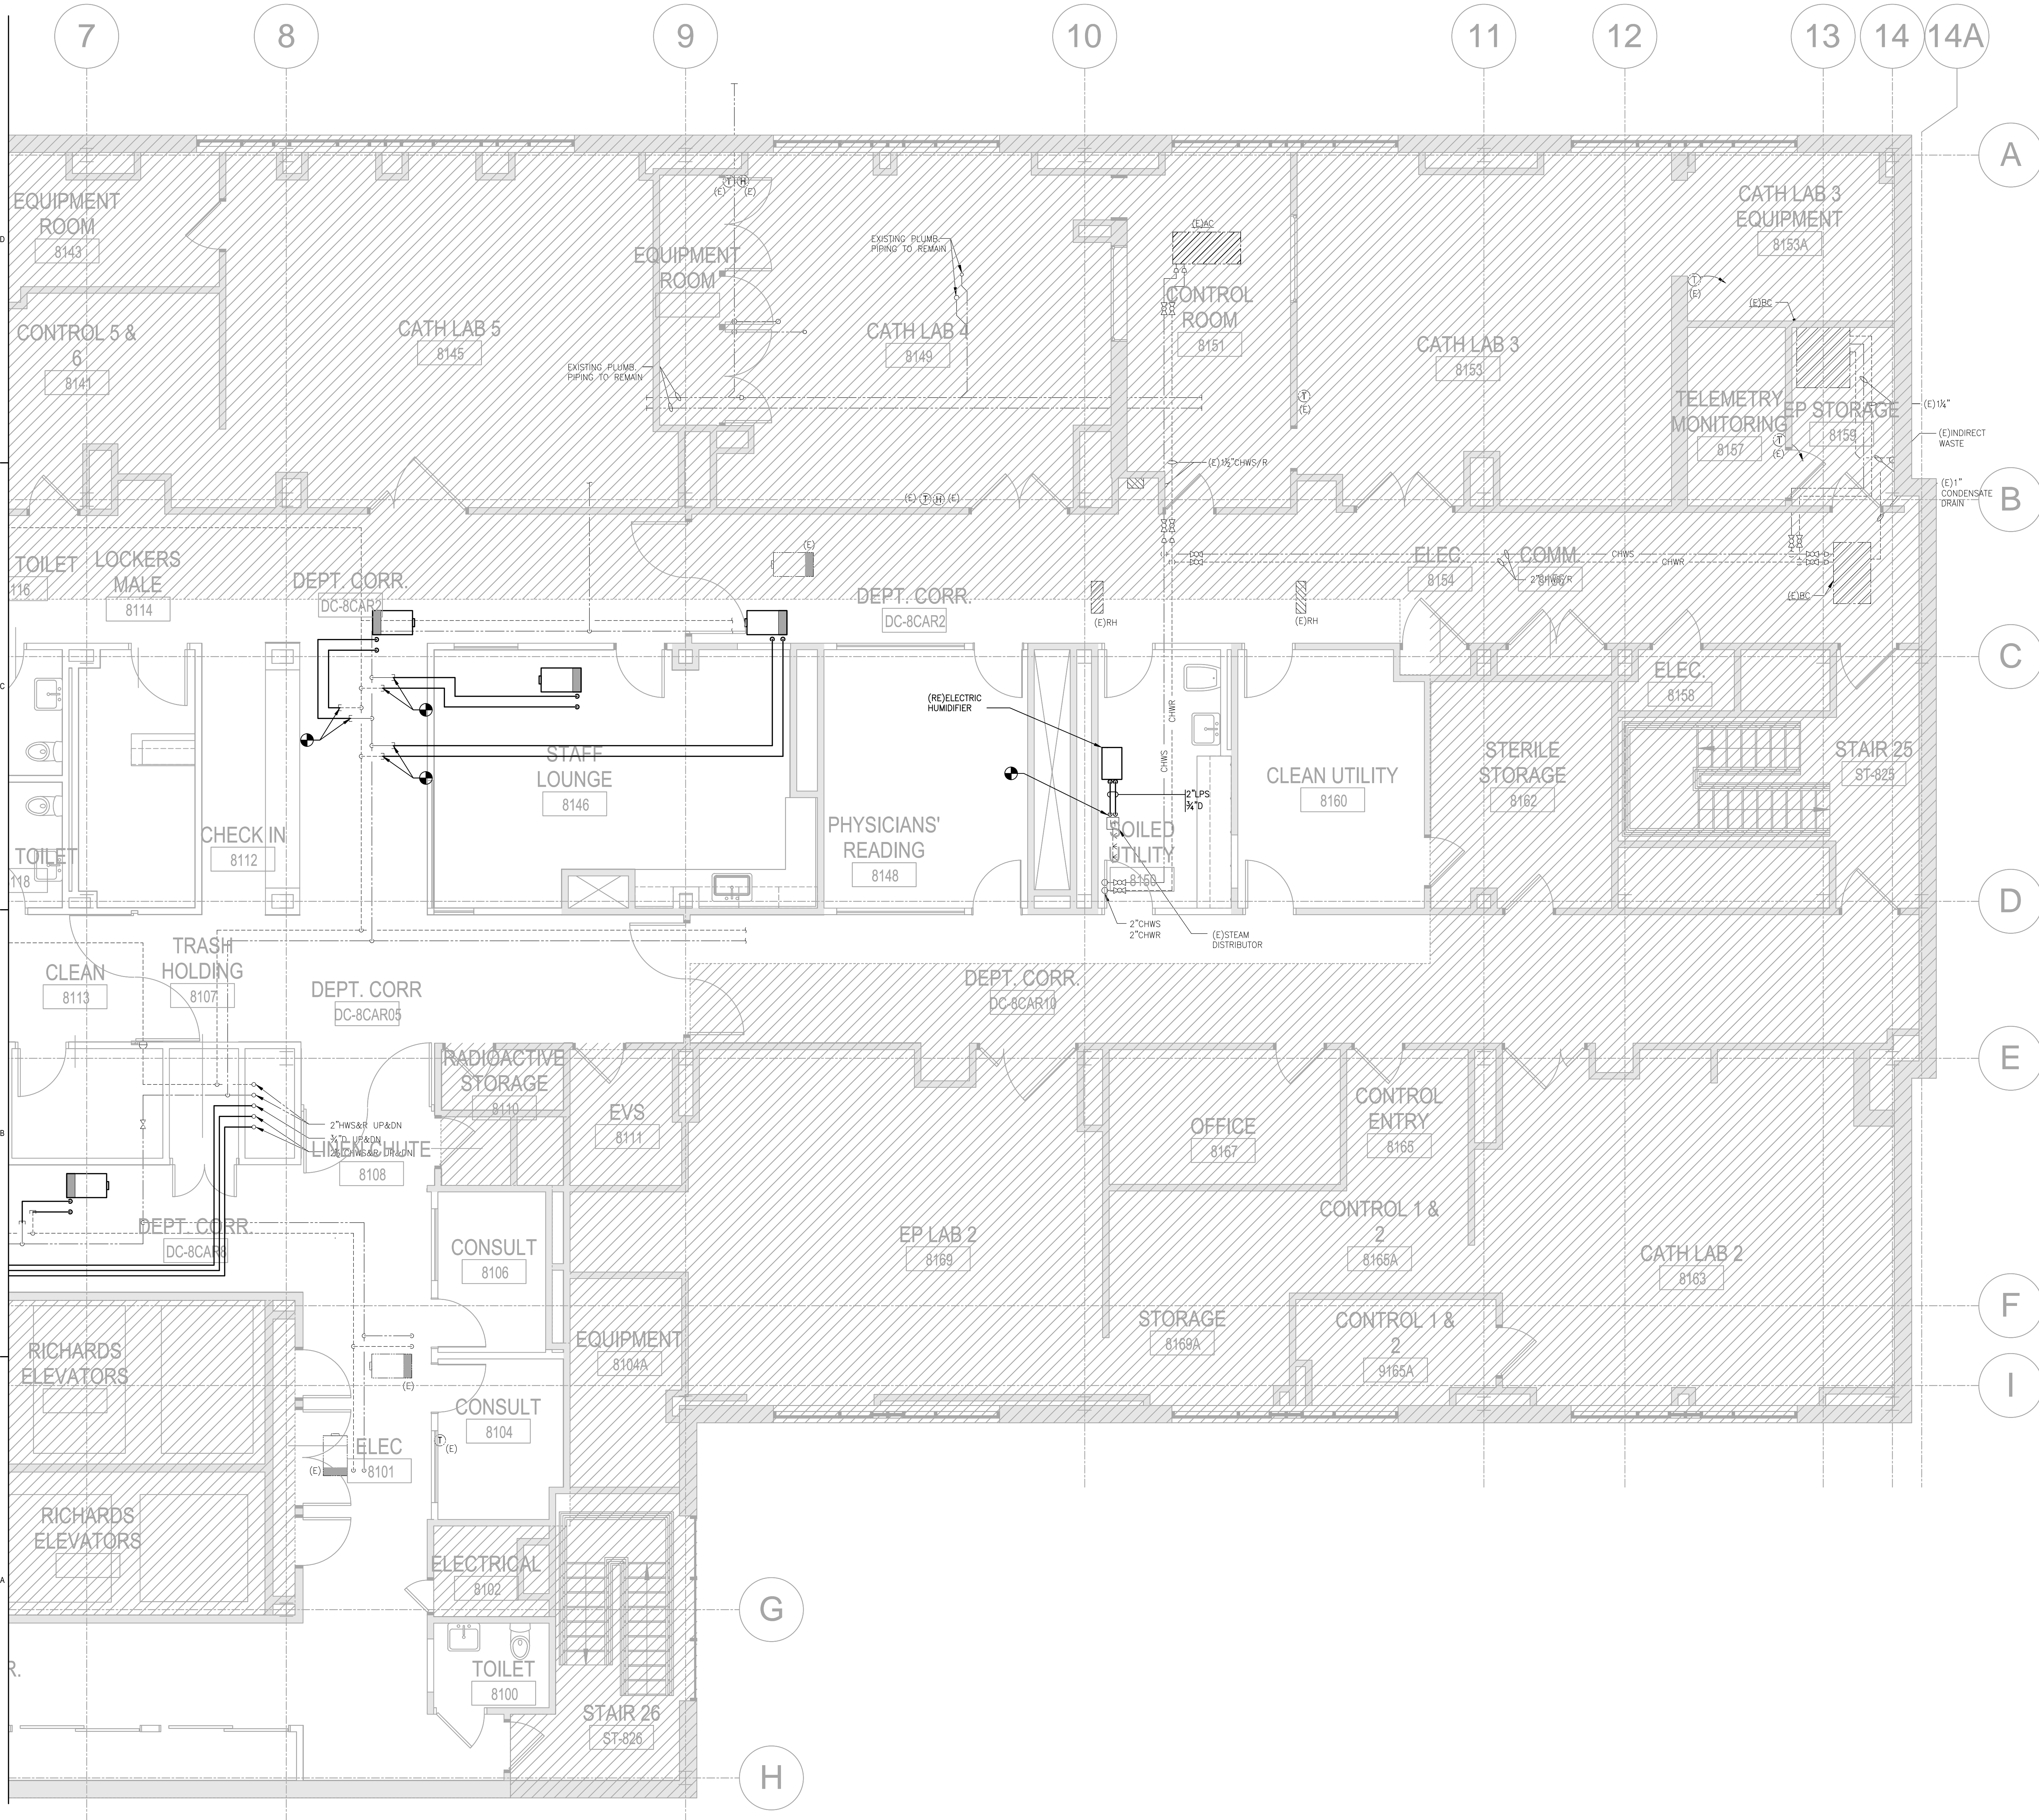


PL:Project\B1600089\B1600089-000\Design\MECH\CAD\Richards 7-9-16\Main\B1600089-000_M04-03_M04-03.dwg LOGIN: Cavanaugh, David PLOT DATE: 06/24/2016 1:56 PM SAVE DATE: 06/24/2016 1:14 PM



PERKINS+WILL
225 Franklin Street, Suite 1100
Boston, MA 02110
1 617 478 0300
1 617 478 0321
www.perkinswill.com

CONSULTANTS
MEPP
AKF GROUP LLC
99 Bedford St., 2nd Floor
Boston, MA 02111
1 617 737 1111
1 617 737 4311
STRUCTURAL
SGH INC.
41 Seyon St.
Waltham, MA 02453
1 781 907 9000
1 781 907 9009

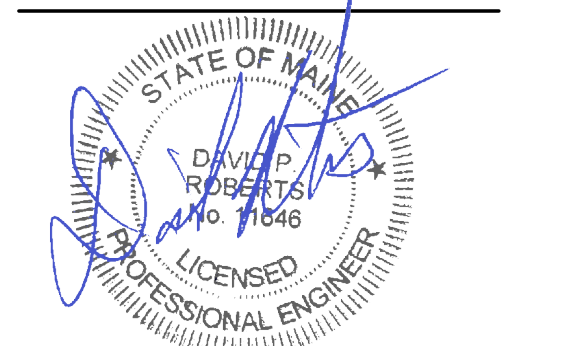

PROJECT
ACCU RELOCATION
22 Bramhall Street
Portland, Maine 04102

Maine Medical Center
MaineHealth

MAINE MEDICAL CENTER
22 Bramhall Street
Portland, Maine 04102

06.24.2016
ISSUE CHART

NO.	ISSUE	DATE
1	ISSUED FOR PERMIT	06.24.2016
2	Job Number	B160089-000
3	Checked	DPR
4	Approved	

TITLE
RICHARDS 8 - MECHANICAL PIPING PLAN - EAST SHEET NUMBER M04-03

Copyright © 2016 Perkins+Will