

**DEMOLITION PLAN NOTES**

1 WORK MAY BE REQUIRED OUTSIDE OF THE PROJECT'S AREA OF RENOVATION. CONTRACTOR SHALL NOT ASSUME THAT AREA OF RENOVATION IS CONSIDERED THE SCOPE OF WORK AREA.

**DEMOLITION KEYED NOTES**

- 1 ALL EXISTING LOW VOLTAGE DEVICES (NURSECALL AND FIRE ALARM) ASSOCIATED WIRING AND RACEWAYS SHALL BE REMOVED BACK TO ITS POINT OF ORIGIN. ASSOCIATED CIRCUIT BREAKER SHALL BE MAINTAINED FOR RE-USE IN THIS PROJECT UNLESS OTHERWISE NOTED.
- 2 NOT USED.
- 3 ALL EXISTING LOW VOLTAGE DEVICES (NURSECALL AND FIRE ALARM) ASSOCIATED WIRING AND RACEWAYS NOTED WITH A "XR" SHALL BE REMOVED AND RELOCATED TO NEW HEADWALL UNIT. ASSOCIATED WIRING SHALL BE MAINTAINED/EXTENDED FOR RE-USE IN THIS PROJECT UNLESS OTHERWISE NOTED.

**SIGNAL GENERAL NOTES**

- 1 ALL DEVICES SHALL BE INSTALLED AT MOUNTING HEIGHTS AND LOCATIONS AS INDICATED ON THE ARCHITECTURAL ELEVATIONS, PART PLANS AND DETAILS. CONTRACTOR SHALL REFER TO THE ARCHITECTURAL DRAWINGS FOR INFORMATION.
- 2 REFER TO DRAWING ED 0 FOR LEGEND & GENERAL NOTES.
- 3 COORDINATE EXACT LOCATION OF ALL MECHANICAL EQUIPMENT WITH HVAC, PLUMBING AND FIRE PROTECTION DRAWINGS.
- 4 CONNECT NEW FIRE ALARM SYSTEM DEVICES TO THE EXISTING SYSTEM (FIELD VERIFY EXACT LOCATION OF FIRE ALARM TERMINAL CABINET). REPROGRAM SYSTEM AND ADD POWER SUPPLIES, SIGNAL MODULES, ETC. AS REQUIRED TO ACCOMMODATE ADDITIONS. INSTALLATION SHALL CONFORM TO BUILDING STANDARDS. THE CONTRACTOR SHALL PROVIDE ALL NECESSARY EQUIPMENT AND FINAL CONNECTIONS, PROGRAMMING AND PERFORM ALL TESTING.
- 5 ALL DATA AND PHONE CABLES ARE TO TERMINATE ON PATCH PANELS SERVING THE AREA.

**SIGNAL KEYED NOTES**

- 1 NOT USED.
- 2 ALL EXISTING DEVICES REMOVED FROM EXISTING HEADWALL SHALL BE RELOCATED TO NEW HEADWALL UNIT. CONNECT TO ASSOCIATED BRANCH CIRCUIT WIRING MAINTAINED/EXTENDED FROM DEMOLITION PHASE.
- 3 PROVIDE PROTECTIVE COVER FOR FIRE ALARM VISUAL DEVICE AS MANUFACTURED BY STI STOPPER COVERS. COORDINATE EXACT SIZE WITH EXISTING FIRE ALARM DEVICE.



1 Electrical First Floor Demolition Signal Plan  
1/4" = 1'-0"




2 Electrical First Floor Signal Plan  
1/4" = 1'-0"

Seals

Consultant

DD Approval Signature Date


Project North

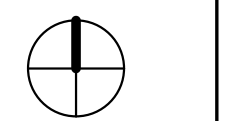

Key Plan N.T.S.


Issued For Construction


Revision Date No

Portland, Maine

**Psych Room  
Renovation**

MorrisSwitzer Project Number 201451  
Date 1/27/2017  
Scale As indicated  
Sheet Title and Number

**ELECTRICAL SIGNAL  
PLANS**

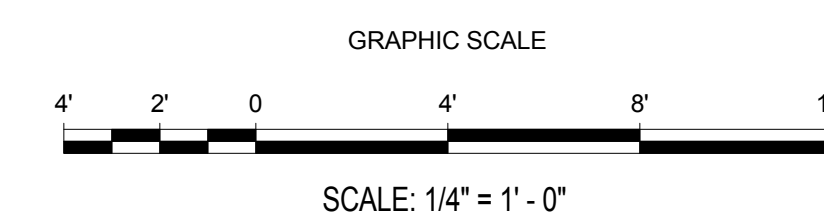

**E3.0**