

Seals

Consultant

DD Approval Signature _____ Date _____

FIRE PROTECTION DEMOLITION NOTES


1 DISCONNECT AND REMOVE EXISTING SPRINKLER AND SWING ARM-OVER. RETAIN EXISTING SPRINKLER BRANCH PIPE FOR REUSE.

FIRE PROTECTION NEW WORK NOTES

1 EXTEND 1" SPRINKLER PIPE FROM EXISTING BRANCH, PROVIDE SWING ARM-OVER AND CONNECT TO NEW SPRINKLER. COORDINATE WITH ALL CEILING MOUNTED EQUIPMENT.



1 FIRST FLOOR FIRE PROTECTION DEMO CEILING
F1.0 1/4" = 1'-0"

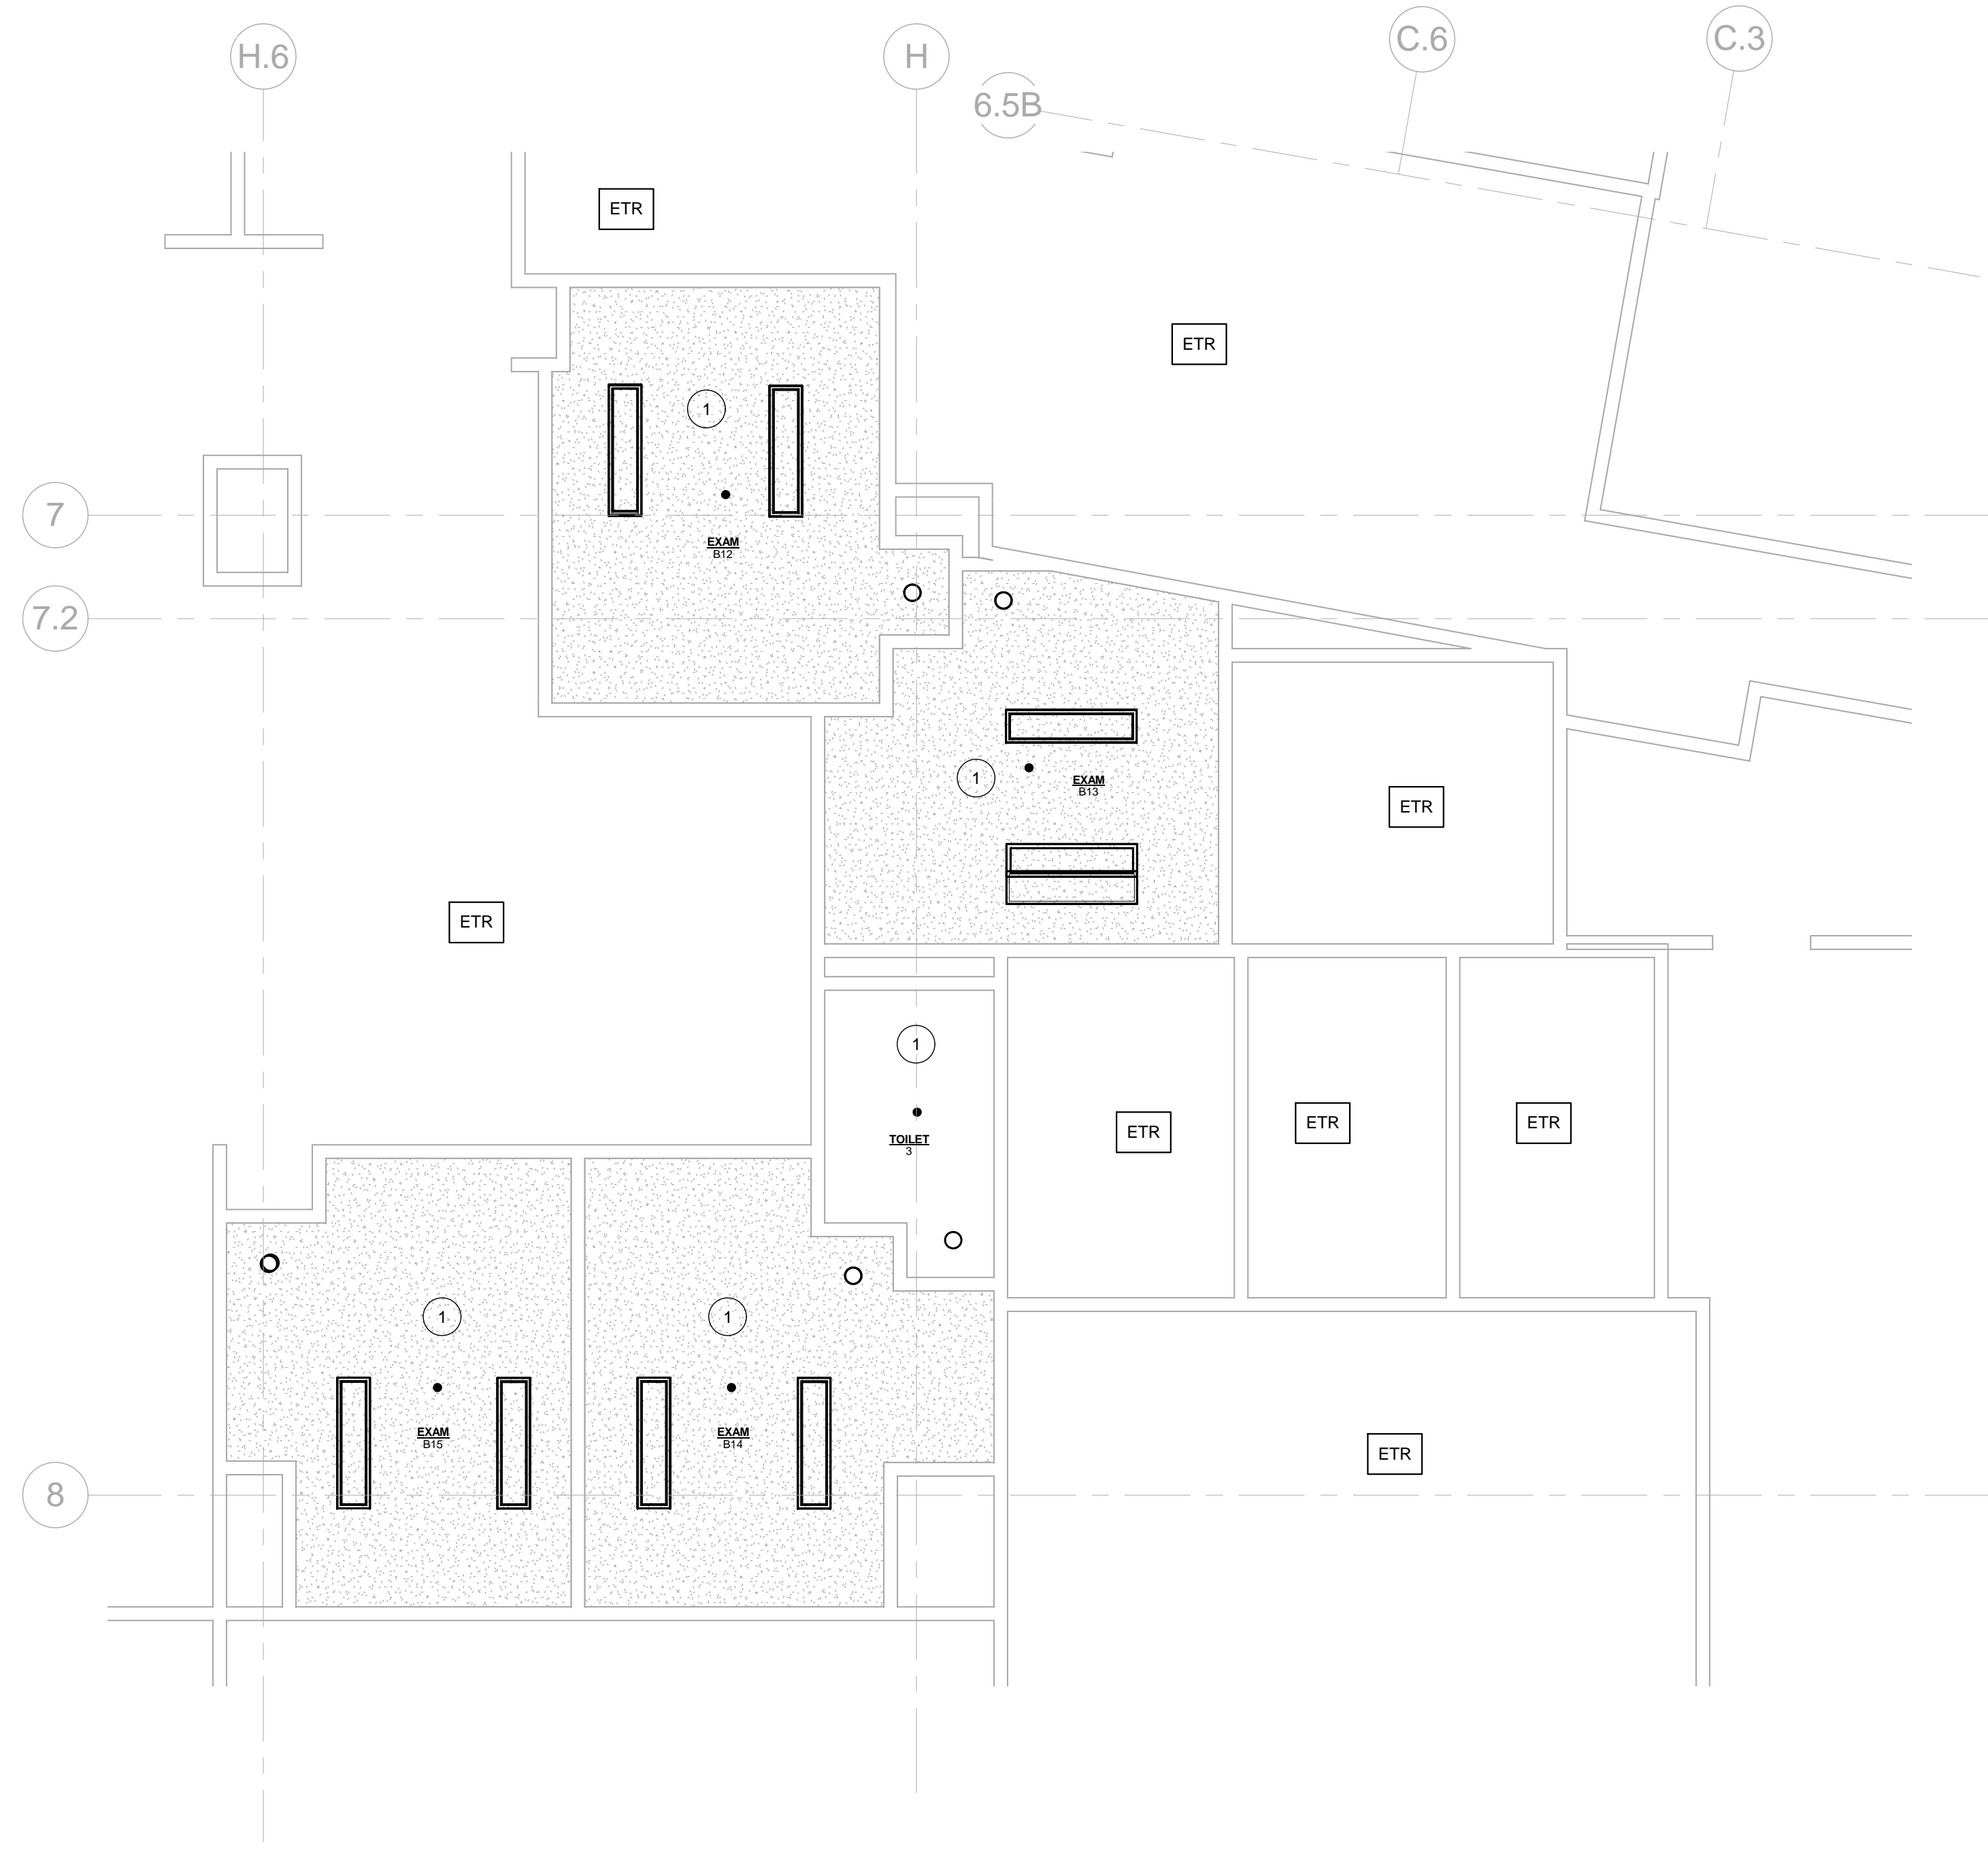

2 FIRST FLOOR FIRE PROTECTION NEW CEILING
F1.0 1/4" = 1'-0"



Key Plan N.T.S.

Issued For Construction
Revision _____ Date _____ No _____

Portland, Maine

**Psych Room
Renovation**

MorrisSwitzer Project Number 201451
Date 1/27/2017
Scale As indicated
Sheet Title and Number

**FIRE PROTECTION
FIRST FLOOR PLAN**

F1.0