

Seals

Consultant


DD Approval Signature \_\_\_\_\_ Date \_\_\_\_\_


**PLUMBING DEMOLITION NOTES**

- 1 NOT USED.
- 2 DISCONNECT AND REMOVE EXISTING PLUMBING FIXTURE AND RETAIN ASSOCIATED WATER AND WASTE CONNECTIONS FOR REUSE.

**PLUMBING NEW WORK NOTES**

- 1 NOT USED
- 2 CONNECT NEW FIXTURE WATER AND WASTE PIPES TO EXISTING WATER AND WASTE PIPE STUBS AT WALL.

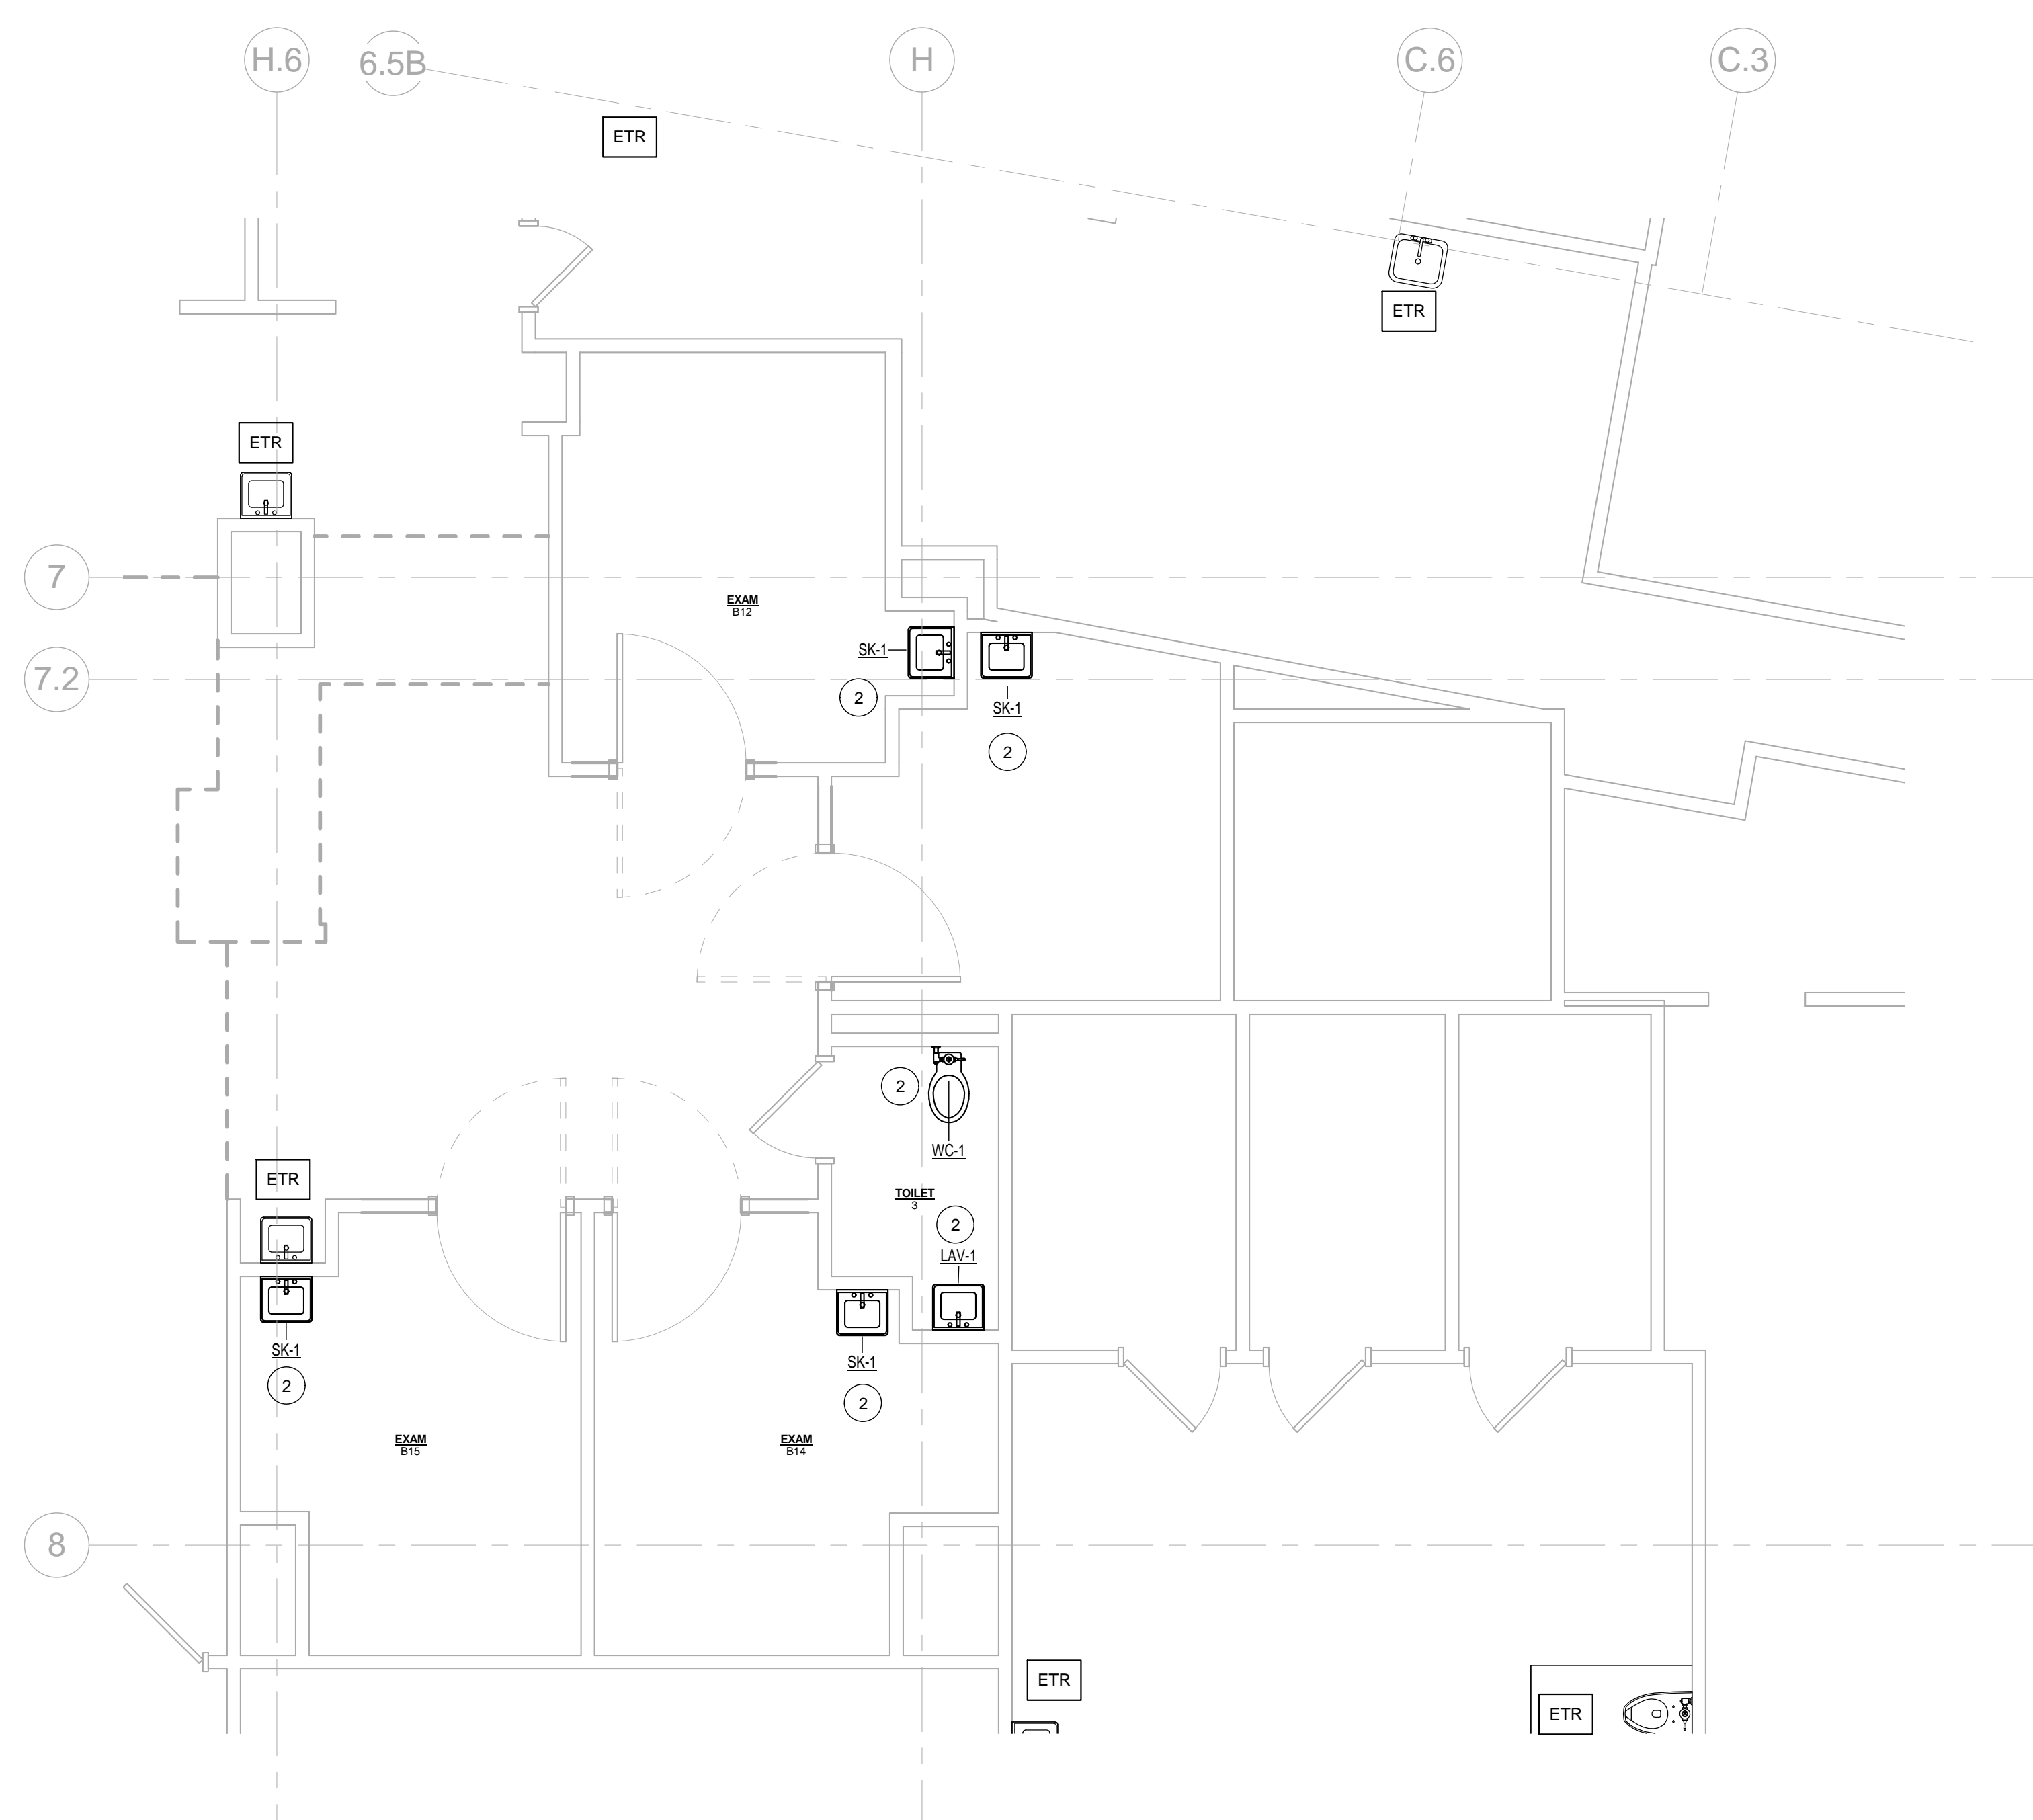

1 FIRST FLOOR PLUMBING DEMO  
P1.0 1/4" = 1'-0"

2 FIRST FLOOR PLUMBING NEW WORK  
P1.0 1/4" = 1'-0"



Key Plan N.T.S.


Issued For Construction	
Revision	Date No

Portland, Maine

**Psych Room  
Renovation**

MorrisSwitzer Project Number 201451  
Date 1/27/2017  
Scale As indicated  
Sheet Title and Number

**PLUMBING FIRST  
FLOOR PLAN**

**P1.0**