

© 2017 RYAN SENATORE ARCHITECTURE

MMC - LOBBY COFFEE BAR DESIGN
 22 BRAMHALL STREET
 PORTLAND, ME 04102



RYAN SENATORE ARCHITECTURE
 565 CONGRESS STREET
 PORTLAND, MAINE 04101
 207-650-6414
 senatorearchitecture.com

CONSULTANTS:

REVISIONS:

DATE: JUNE 22, 2017

PROJECT No. 1709


DRAWN BY: JPF

CHECKED BY: RJS

SCALE: AS NOTED

SHEET TITLE:
EQUIPMENT PLAN

A1-1

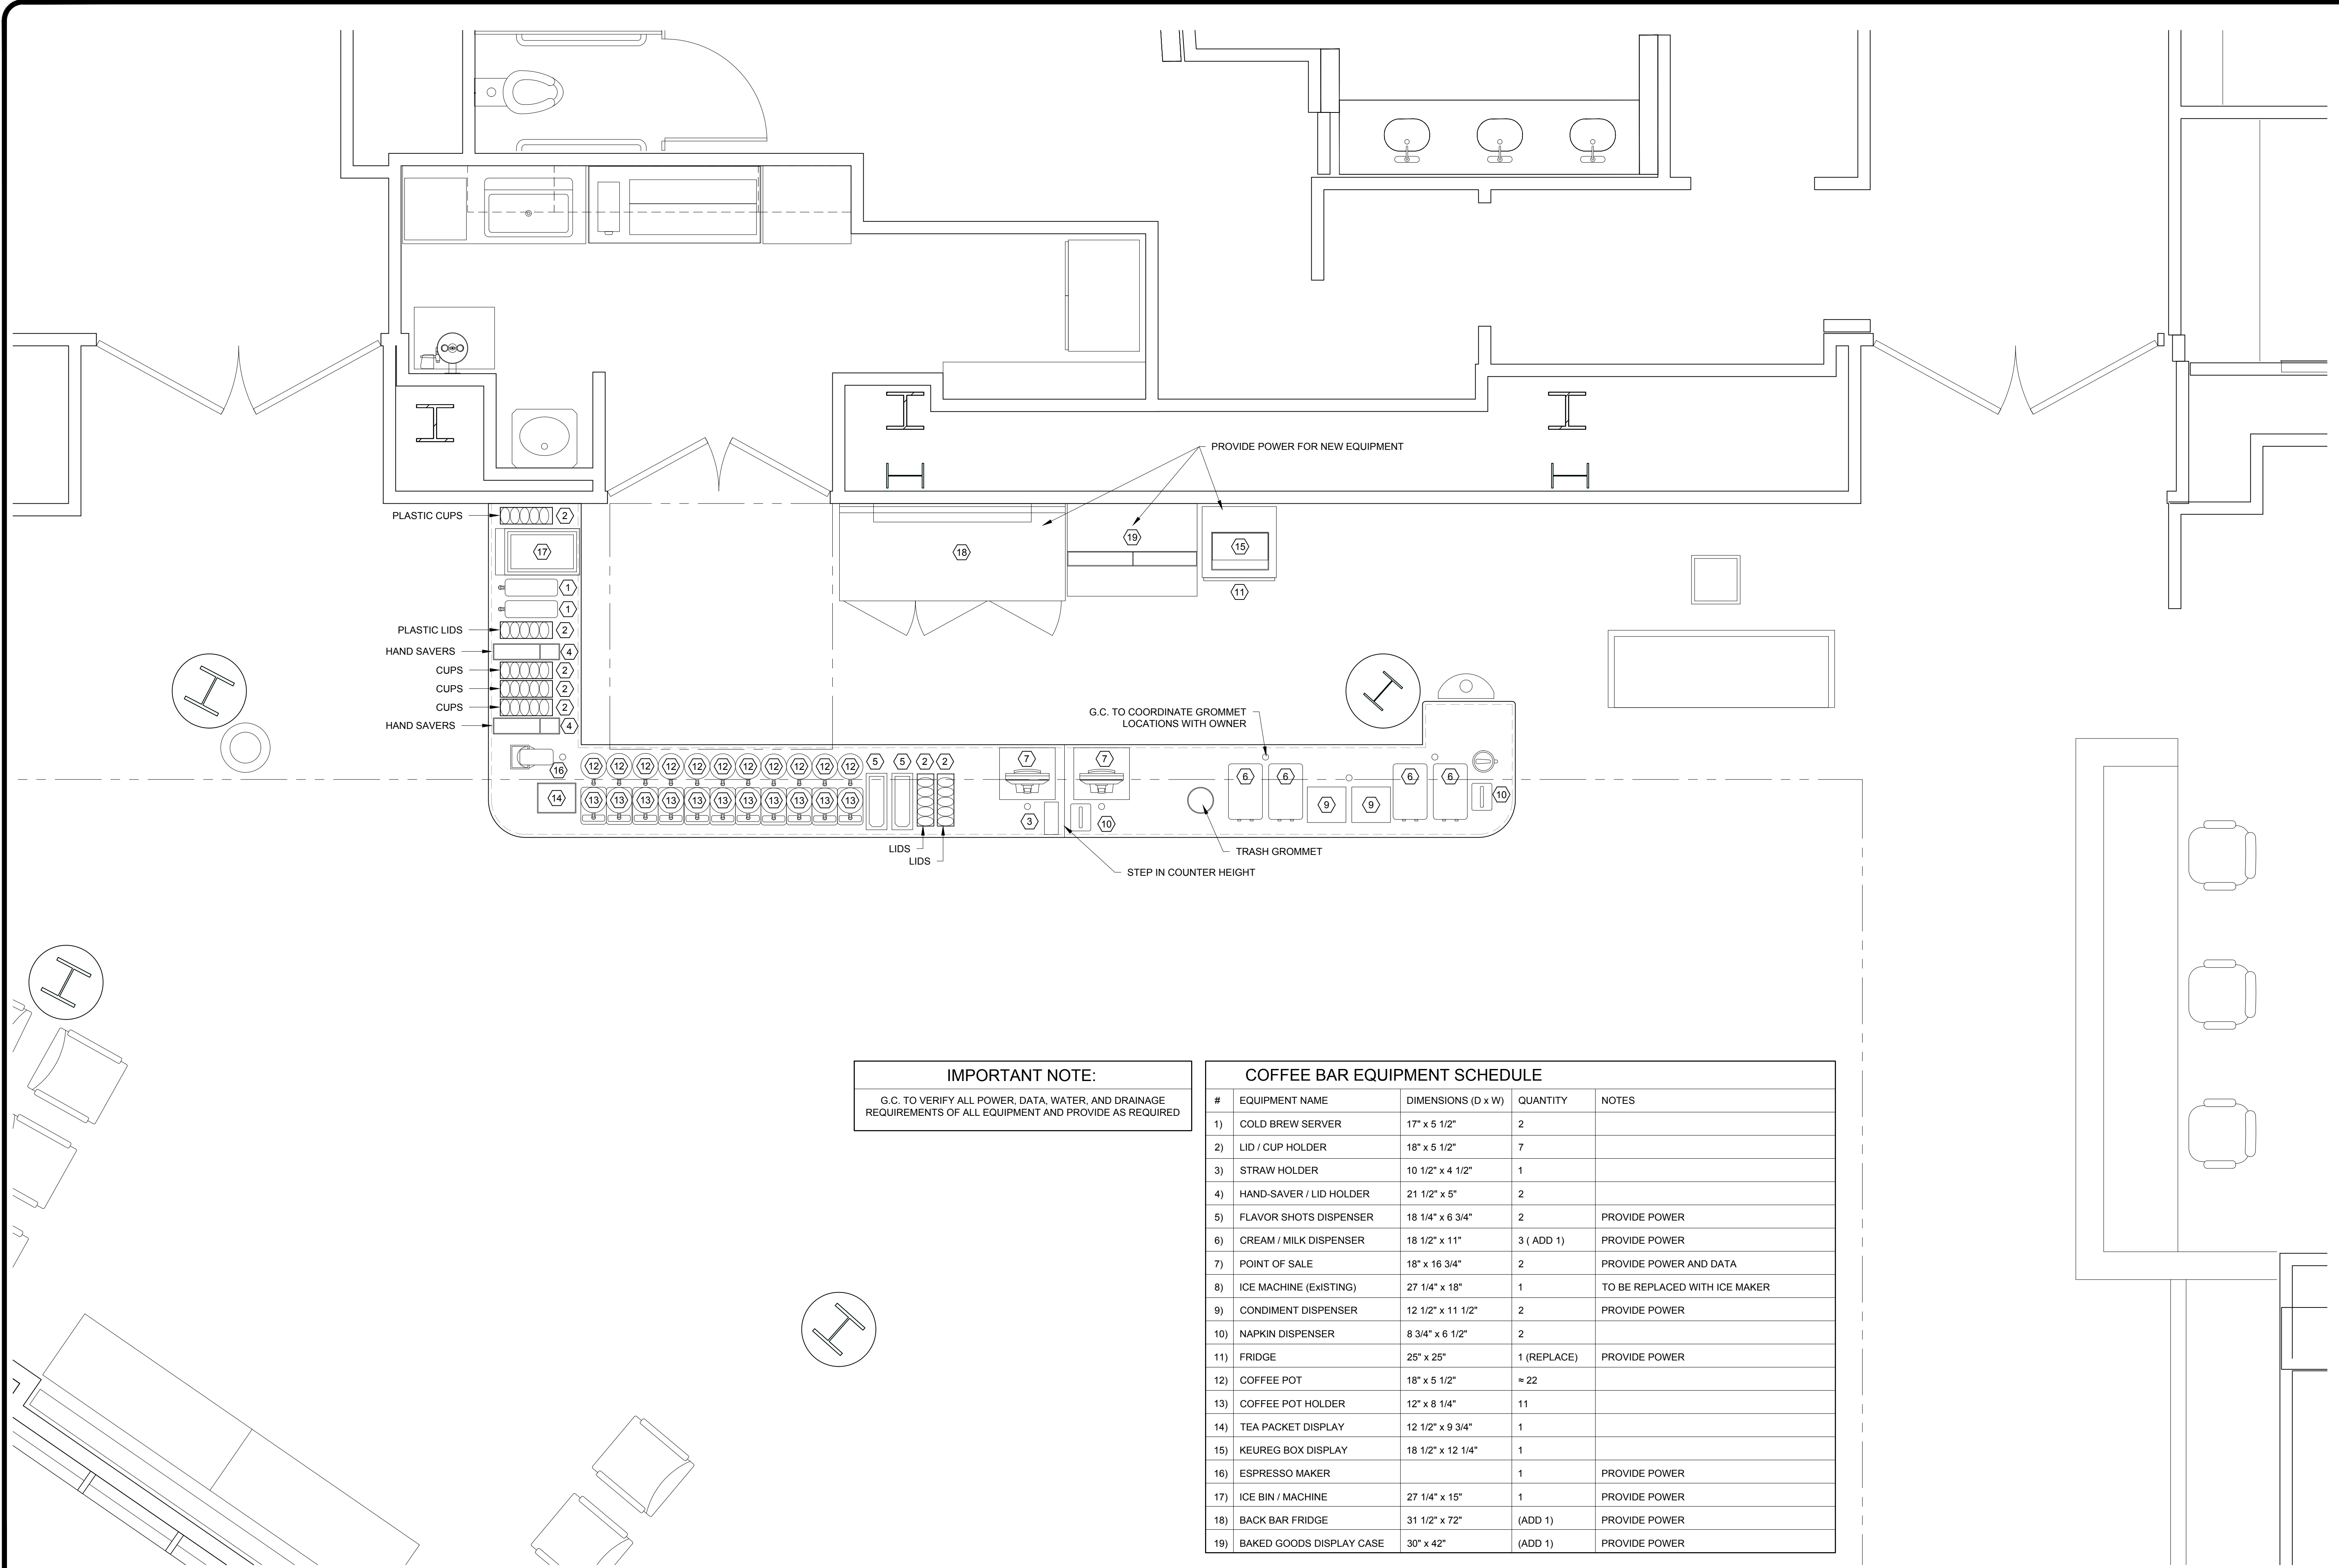

IMPORTANT NOTE:
 G.C. TO VERIFY ALL POWER, DATA, WATER, AND DRAINAGE REQUIREMENTS OF ALL EQUIPMENT AND PROVIDE AS REQUIRED

#	EQUIPMENT NAME	DIMENSIONS (D x W)	QUANTITY	NOTES
1)	COLD BREW SERVER	17" x 5 1/2"	2	
2)	LID / CUP HOLDER	18" x 5 1/2"	7	
3)	STRAW HOLDER	10 1/2" x 4 1/2"	1	
4)	HAND-SAVER / LID HOLDER	21 1/2" x 5"	2	
5)	FLAVOR SHOTS DISPENSER	18 1/4" x 6 3/4"	2	PROVIDE POWER
6)	CREAM / MILK DISPENSER	18 1/2" x 11"	3 (ADD 1)	PROVIDE POWER
7)	POINT OF SALE	18" x 16 3/4"	2	PROVIDE POWER AND DATA
8)	ICE MACHINE (EXISTING)	27 1/4" x 18"	1	TO BE REPLACED WITH ICE MAKER
9)	CONDIMENT DISPENSER	12 1/2" x 11 1/2"	2	PROVIDE POWER
10)	NAPKIN DISPENSER	8 3/4" x 6 1/2"	2	
11)	FRIDGE	25" x 25"	1 (REPLACE)	PROVIDE POWER
12)	COFFEE POT	18" x 5 1/2"	≈ 22	
13)	COFFEE POT HOLDER	12" x 8 1/4"	11	
14)	TEA PACKET DISPLAY	12 1/2" x 9 3/4"	1	
15)	KEUREG BOX DISPLAY	18 1/2" x 12 1/4"	1	
16)	ESPRESSO MAKER		1	PROVIDE POWER
17)	ICE BIN / MACHINE	27 1/4" x 15"	1	PROVIDE POWER
18)	BACK BAR FRIDGE	31 1/2" x 72"	(ADD 1)	PROVIDE POWER
19)	BAKED GOODS DISPLAY CASE	30" x 42"	(ADD 1)	PROVIDE POWER

1 EQUIPMENT FLOOR PLAN
 1/2" = 1'-0"