



2 SECOND FLOOR BEREAVEMENT DUCT PLAN  
 M302 1/4" = 1'-0"

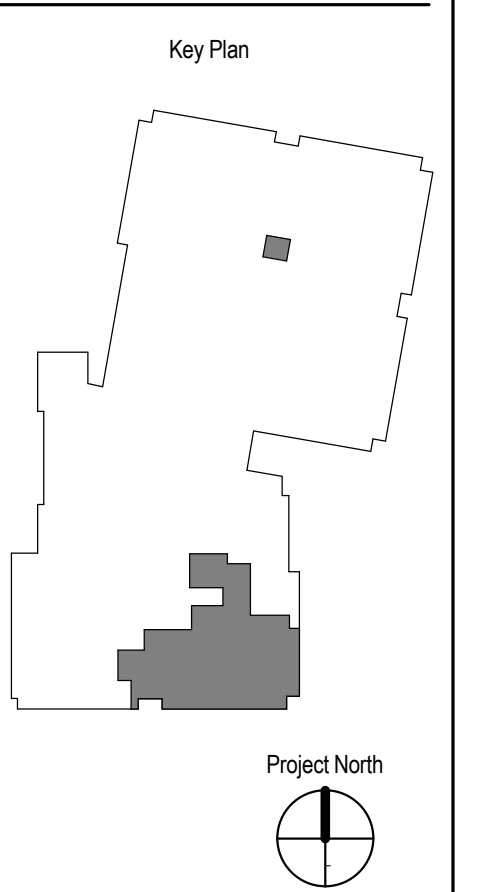


REV	DESCRIPTION	DATE
PERMIT SET		7.27.2017

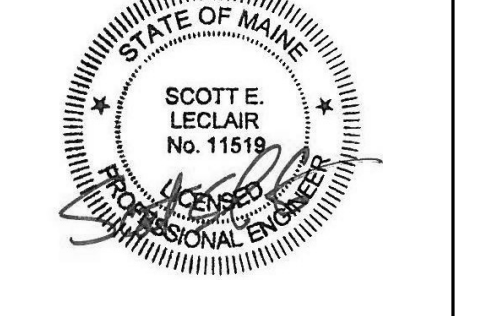

SEAL:  
 PROJECT NUMBER: 2017009  
 DATE: 07/27/2017  
 SHEET TITLE AND NUMBER:

**M302**  
 MECHANICAL NEW DUCTWORK PLAN

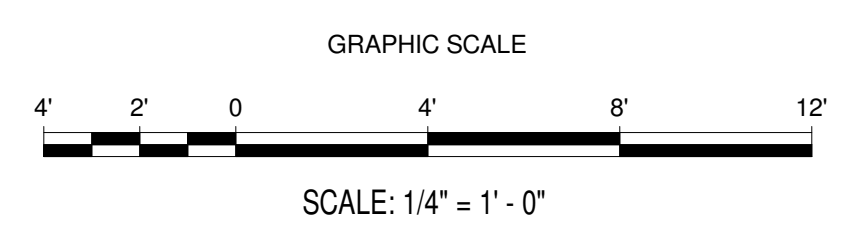

SCALE: 1/4" = 1'-0"