


- DRAWING NOTES:**
1. REFER TO DRAWING FA0.0 FOR LEGEND, SYMBOLS, DEMOLITION NOTES, GENERAL NOTES, AND CIRCUIT TRACING NOTE.
  2. CONTRACTOR SHALL VERIFY ANY DEVICE AND/OR CIRCUIT IN QUESTION PRIOR TO ANY DEMOLITION.
  3. ALL DAMAGED EXISTING FIRE ALARM DEVICES THAT ARE TO REMAIN SHALL BE REPLACED WITH NEW DEVICES AND FACE PLATES.

**AKF**  
 99 Bedford Street, 2nd Fl.  
 Boston, MA 02111  
 T: 617.737.1111 F: 617.737.4311  
 BOSTON | BOSTON | BOSTON | BOSTON | BOSTON | BOSTON | BOSTON | BOSTON | BOSTON | BOSTON  
 NEW HAVEN | NEW YORK | PHOENIX | RICHMOND | SEATTLE  
 WASHINGTON, DC | WASHINGTON, DC | WASHINGTON, DC | WASHINGTON, DC | WASHINGTON, DC | WASHINGTON, DC | WASHINGTON, DC | WASHINGTON, DC | WASHINGTON, DC | WASHINGTON, DC

**1 DEMOLITION PLAN**  
 SCALE: 1/4"=1'-0"

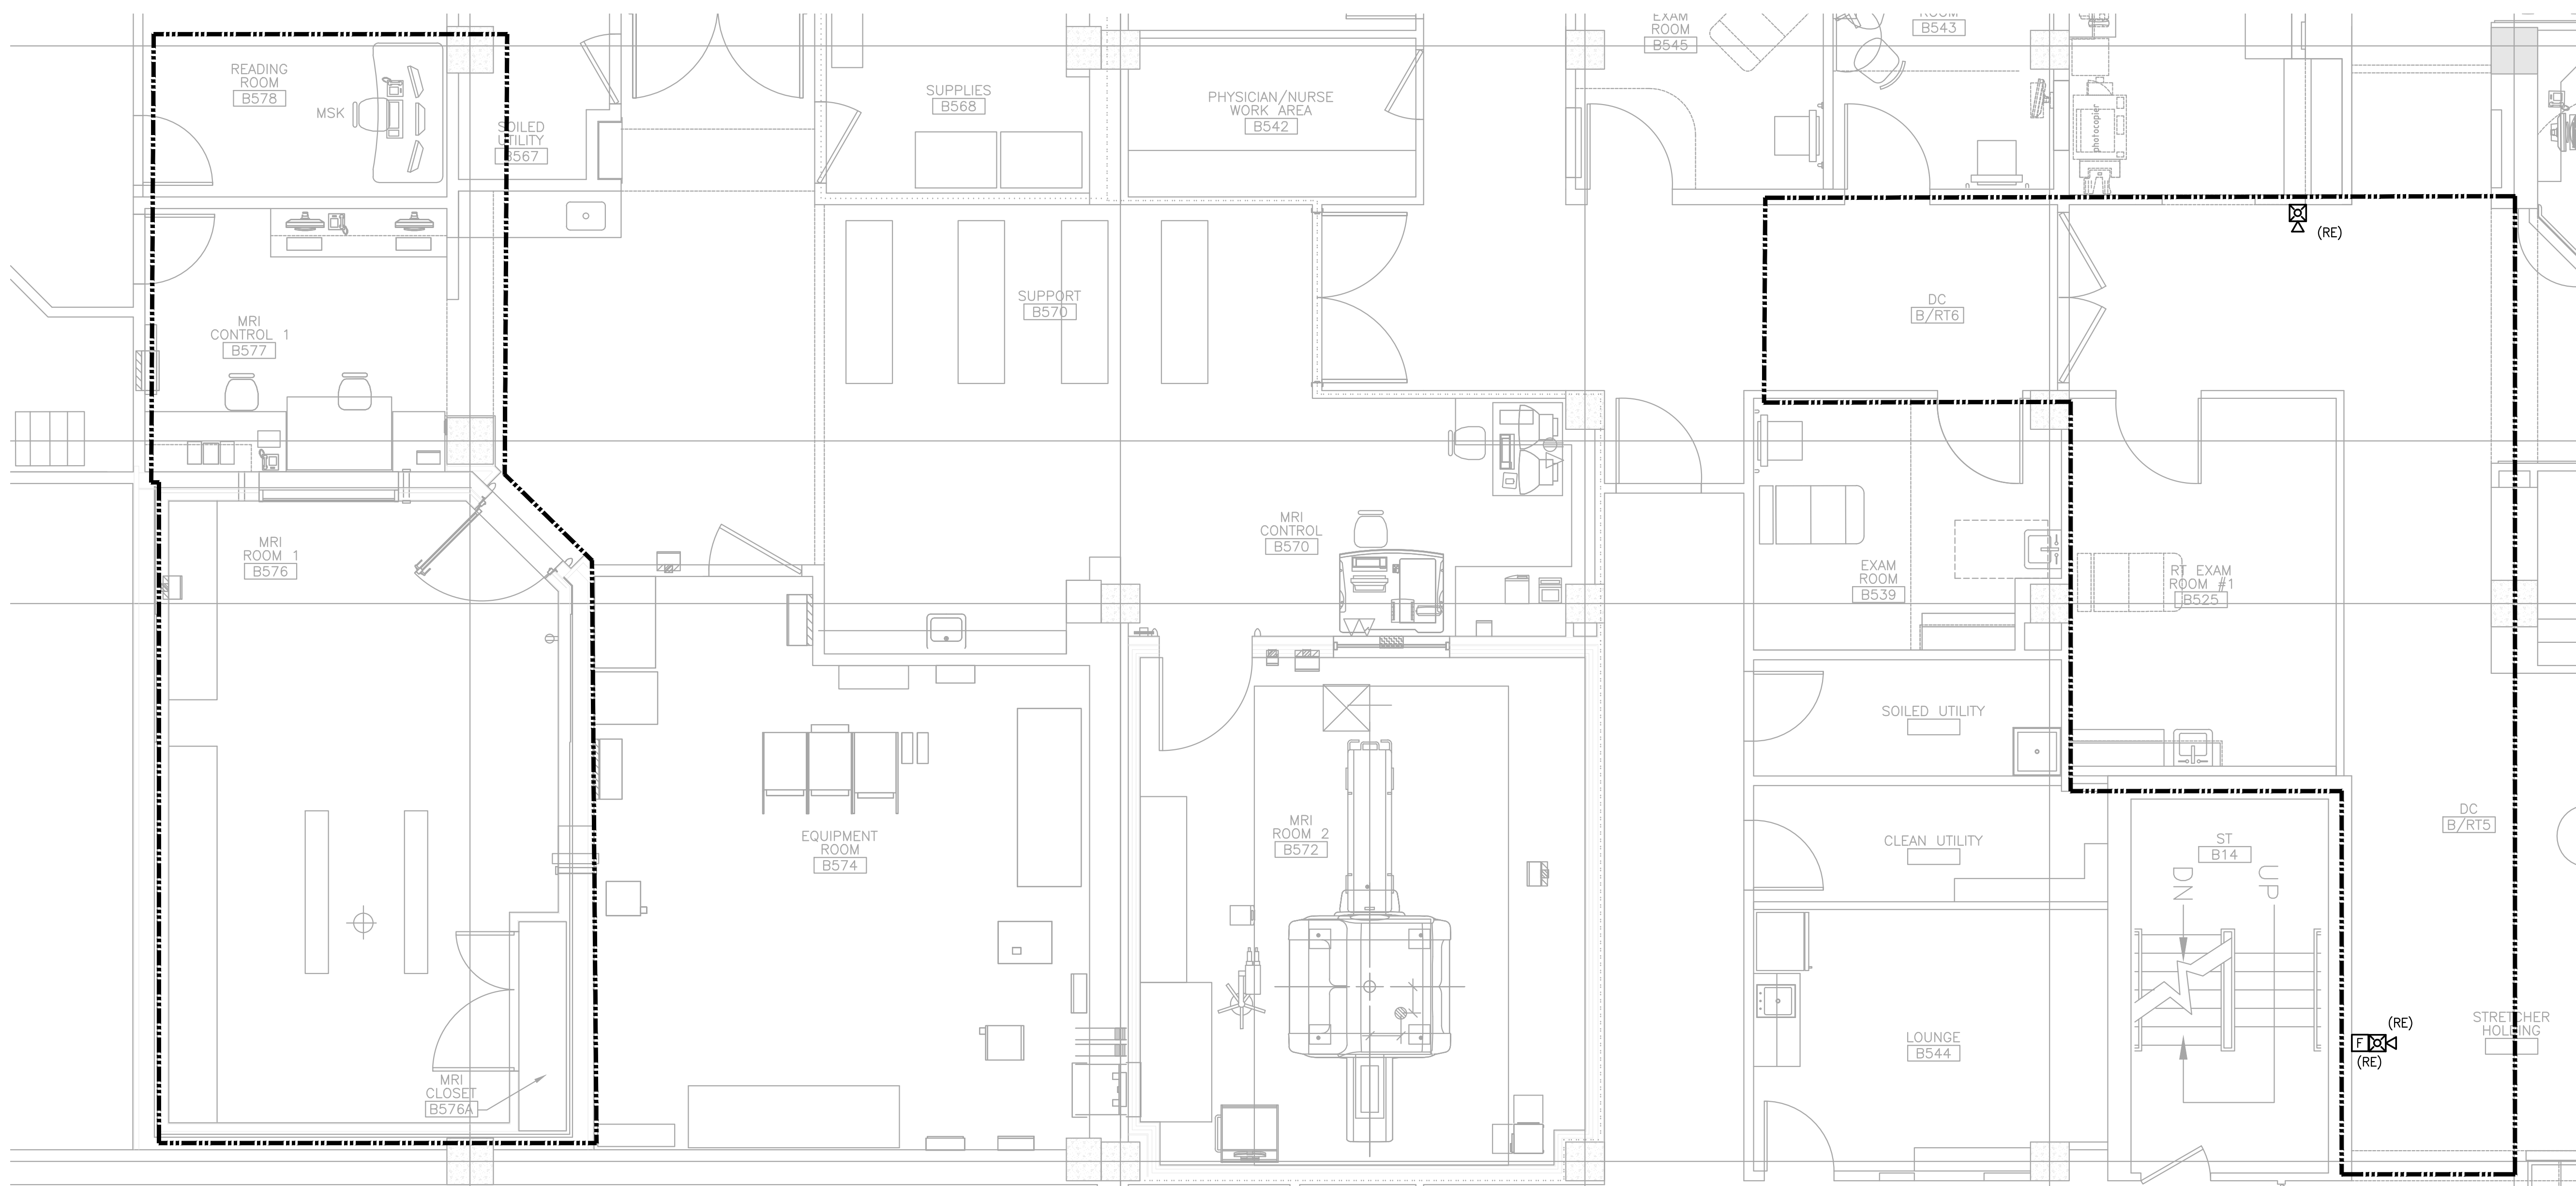


**2 NEW FLOOR PLAN**  
 SCALE: 1/4"=1'-0"

REV	DESCRIPTION	DATE
0	ISSUED FOR CONSTRUCTION	2-27-17

**ISSUED FOR CONSTRUCTION**  
 2-27-17

CURRENT ISSUE STATUS:

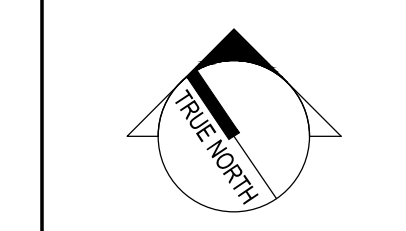


**PROJECT NORTH:**  
 SMRT Architects and Engineers  
 144 Fore Street  
 Portland, Maine 04104  
 1.877.700.7678  
 www.smrtinc.com



**MAINE MEDICAL CENTER  
 BRAMHALL CAMPUS  
 MRI #1 REPLACEMENT  
 PORTLAND, MAINE**

**FIRE ALARM FLOOR PLAN-  
 DEMO AND NEW**

SHEET TITLE:

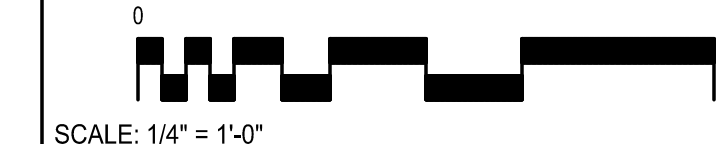

PROJECT MANAGER:	PROJECT NO: B180143-004
A/E OF RECORD:	
JOB CAPTAIN:	
DRAWN BY: AJR	<b>FA1.0</b>
SMRT FILE:	SHEET No.

SAVE DATE: 2/27/2017 4:08 PM

PLOT DATE: 2/27/2017 4:09 PM

LOGIN: Roy, Adam

\\mainframe\Projects\Projects\B180143-004\Design\Main\CA01\FA180143-004\_FA1.0.dwg