
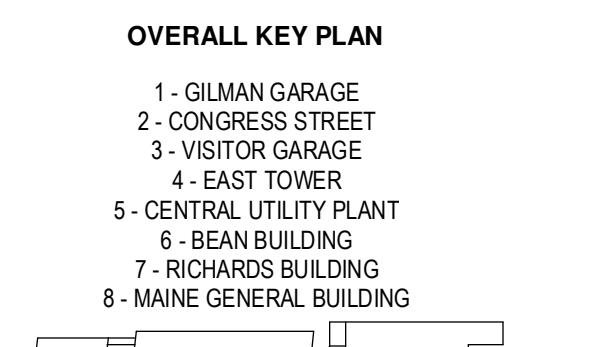
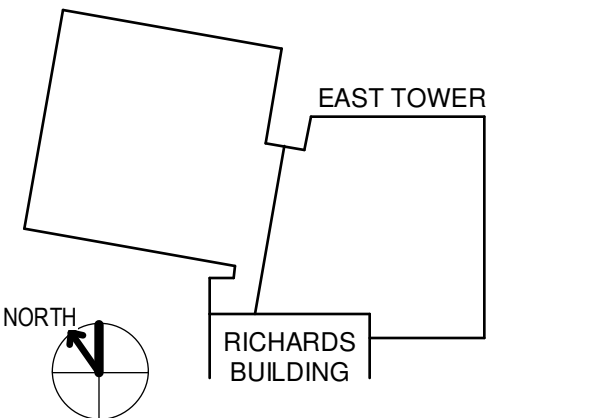


- CVL/LANDSCAPE ARCHITECT  
**Sebago Technics**  
75 John Roberts Road, Suite 1A, South Portland ME 04106
- STRUCTURAL ENGR./BUILDING ENVELOPE CONSULTANT  
**Stinson Gumpertz & Heper Inc.**  
41 Sevon Street, Building 1, Suite 500, Waltham MA 02453
- MEP/ELECTRICAL ENGINEER  
**AKF Group LLC**  
99 Bedford Street, 2nd Floor, Boston MA 02111
- CONSTRUCTION MANAGER  
**Turner Construction**  
2 Seaport Lane, Suite 200, Boston MA 02210
- ELEVATOR CONSULTANT  
**VDA (Van Dusen & Associates)**  
101 Summer Street, 4th Floor, Boston MA 02110
- COST ESTIMATOR  
**D. G. Jones International**  
3 Baldwin Green Common, Suite 202, Woburn MA 01801

**East Tower 6 & 7 Addition**  
22 Bramhall Street  
Portland ME 04102

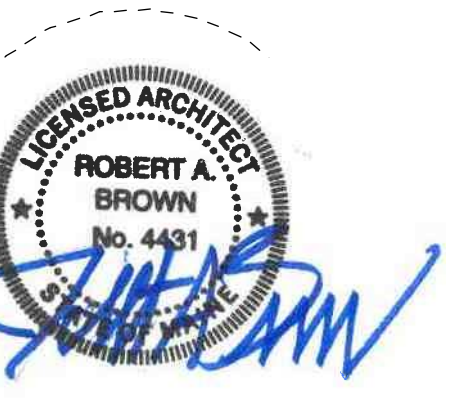


NO	ISSUE	DATE
2	ADDENDUM NO. 2	3/28/18
1	ADDENDUM NO. 1	3/22/18
NO	ISSUE	DATE


Job Number: 152181.000  
Drawn: TEAM  
Checked: JK  
Approved: JK

**KEYNOTES**


- 05 12 00.A STL BEAM
- 05 12 00.A3 STL PL
- 05 12 00.A4 STL BENT PL
- 05 12 00.A5 STL TUBE
- 05 12 00.A7 STL CHANNEL
- 05 40.00 COLD-FORMED METAL FRAMING
- 05 19.0.A METAL GRATE TREAD
- 05 19.0.B TREADPLATE RISER
- 05 19.0.C GALV CHANNEL STRINGER
- 05 12.0.3 PIPE AND TUBE RAILINGS
- 05 12.0.3.F GALV FENCING
- 05 12.0.3.F1 GALV FENCING FRAME
- 05 19.0.3.B FIRE RETARDANT TREATED WOOD BLOCKING
- 06 16.00.A1 FIRE RETARDANT TREATED PLYWOOD
- 06 16.00.B3 CLASS-MAT GYPSUM WALL SHEATHING
- 07 21.00.A POLYISO BOARD INSUL
- 07 21.00.H MINERAL WOOL BD INS
- 07 21.00.M CLOSED-CELL SPRAY POLYURETHANE FOAM
- 07 42.13.13 FORMED METAL WALL PANELS
- 07 53.23 ETHYLENE-PROPYLENE-DIENE-MONOMER (EPDM) ROOFING
- 07 53.23.D VAPOR BARRIER
- 07 53.23.J PIPE BOOTS
- 07 53.23.J1 SSI BOOT CLAMP
- 07 60.00.J FORMED METL GUTTER
- 07 81.00.A SPRAYED FIRE RESISTIVE MATERIAL
- 07 84.43 JOINT FIRESTOPPING
- 09 91.13.A CONCRETE SEALER
- 11 24.29 FACILITY FALL PROTECTION

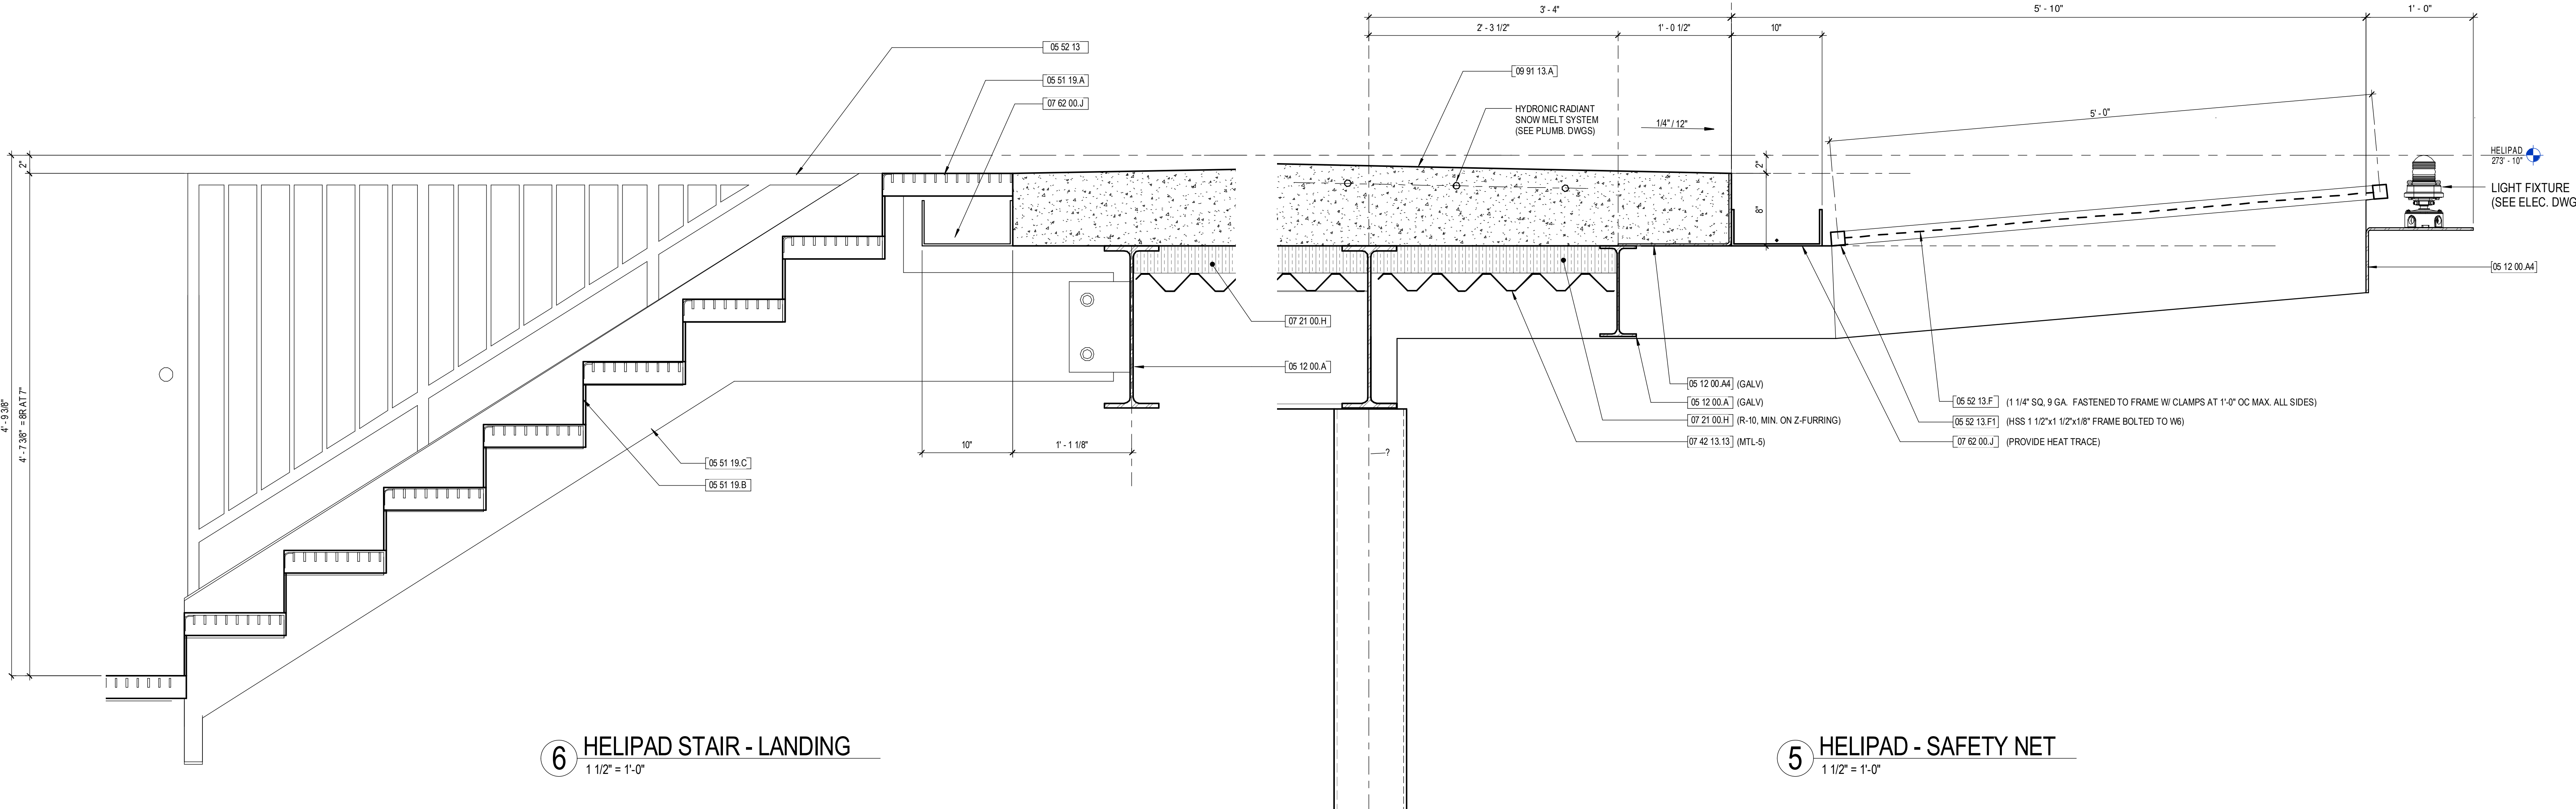


**5 HELIPAD - SAFETY NET**  
1 1/2" = 1'-0"

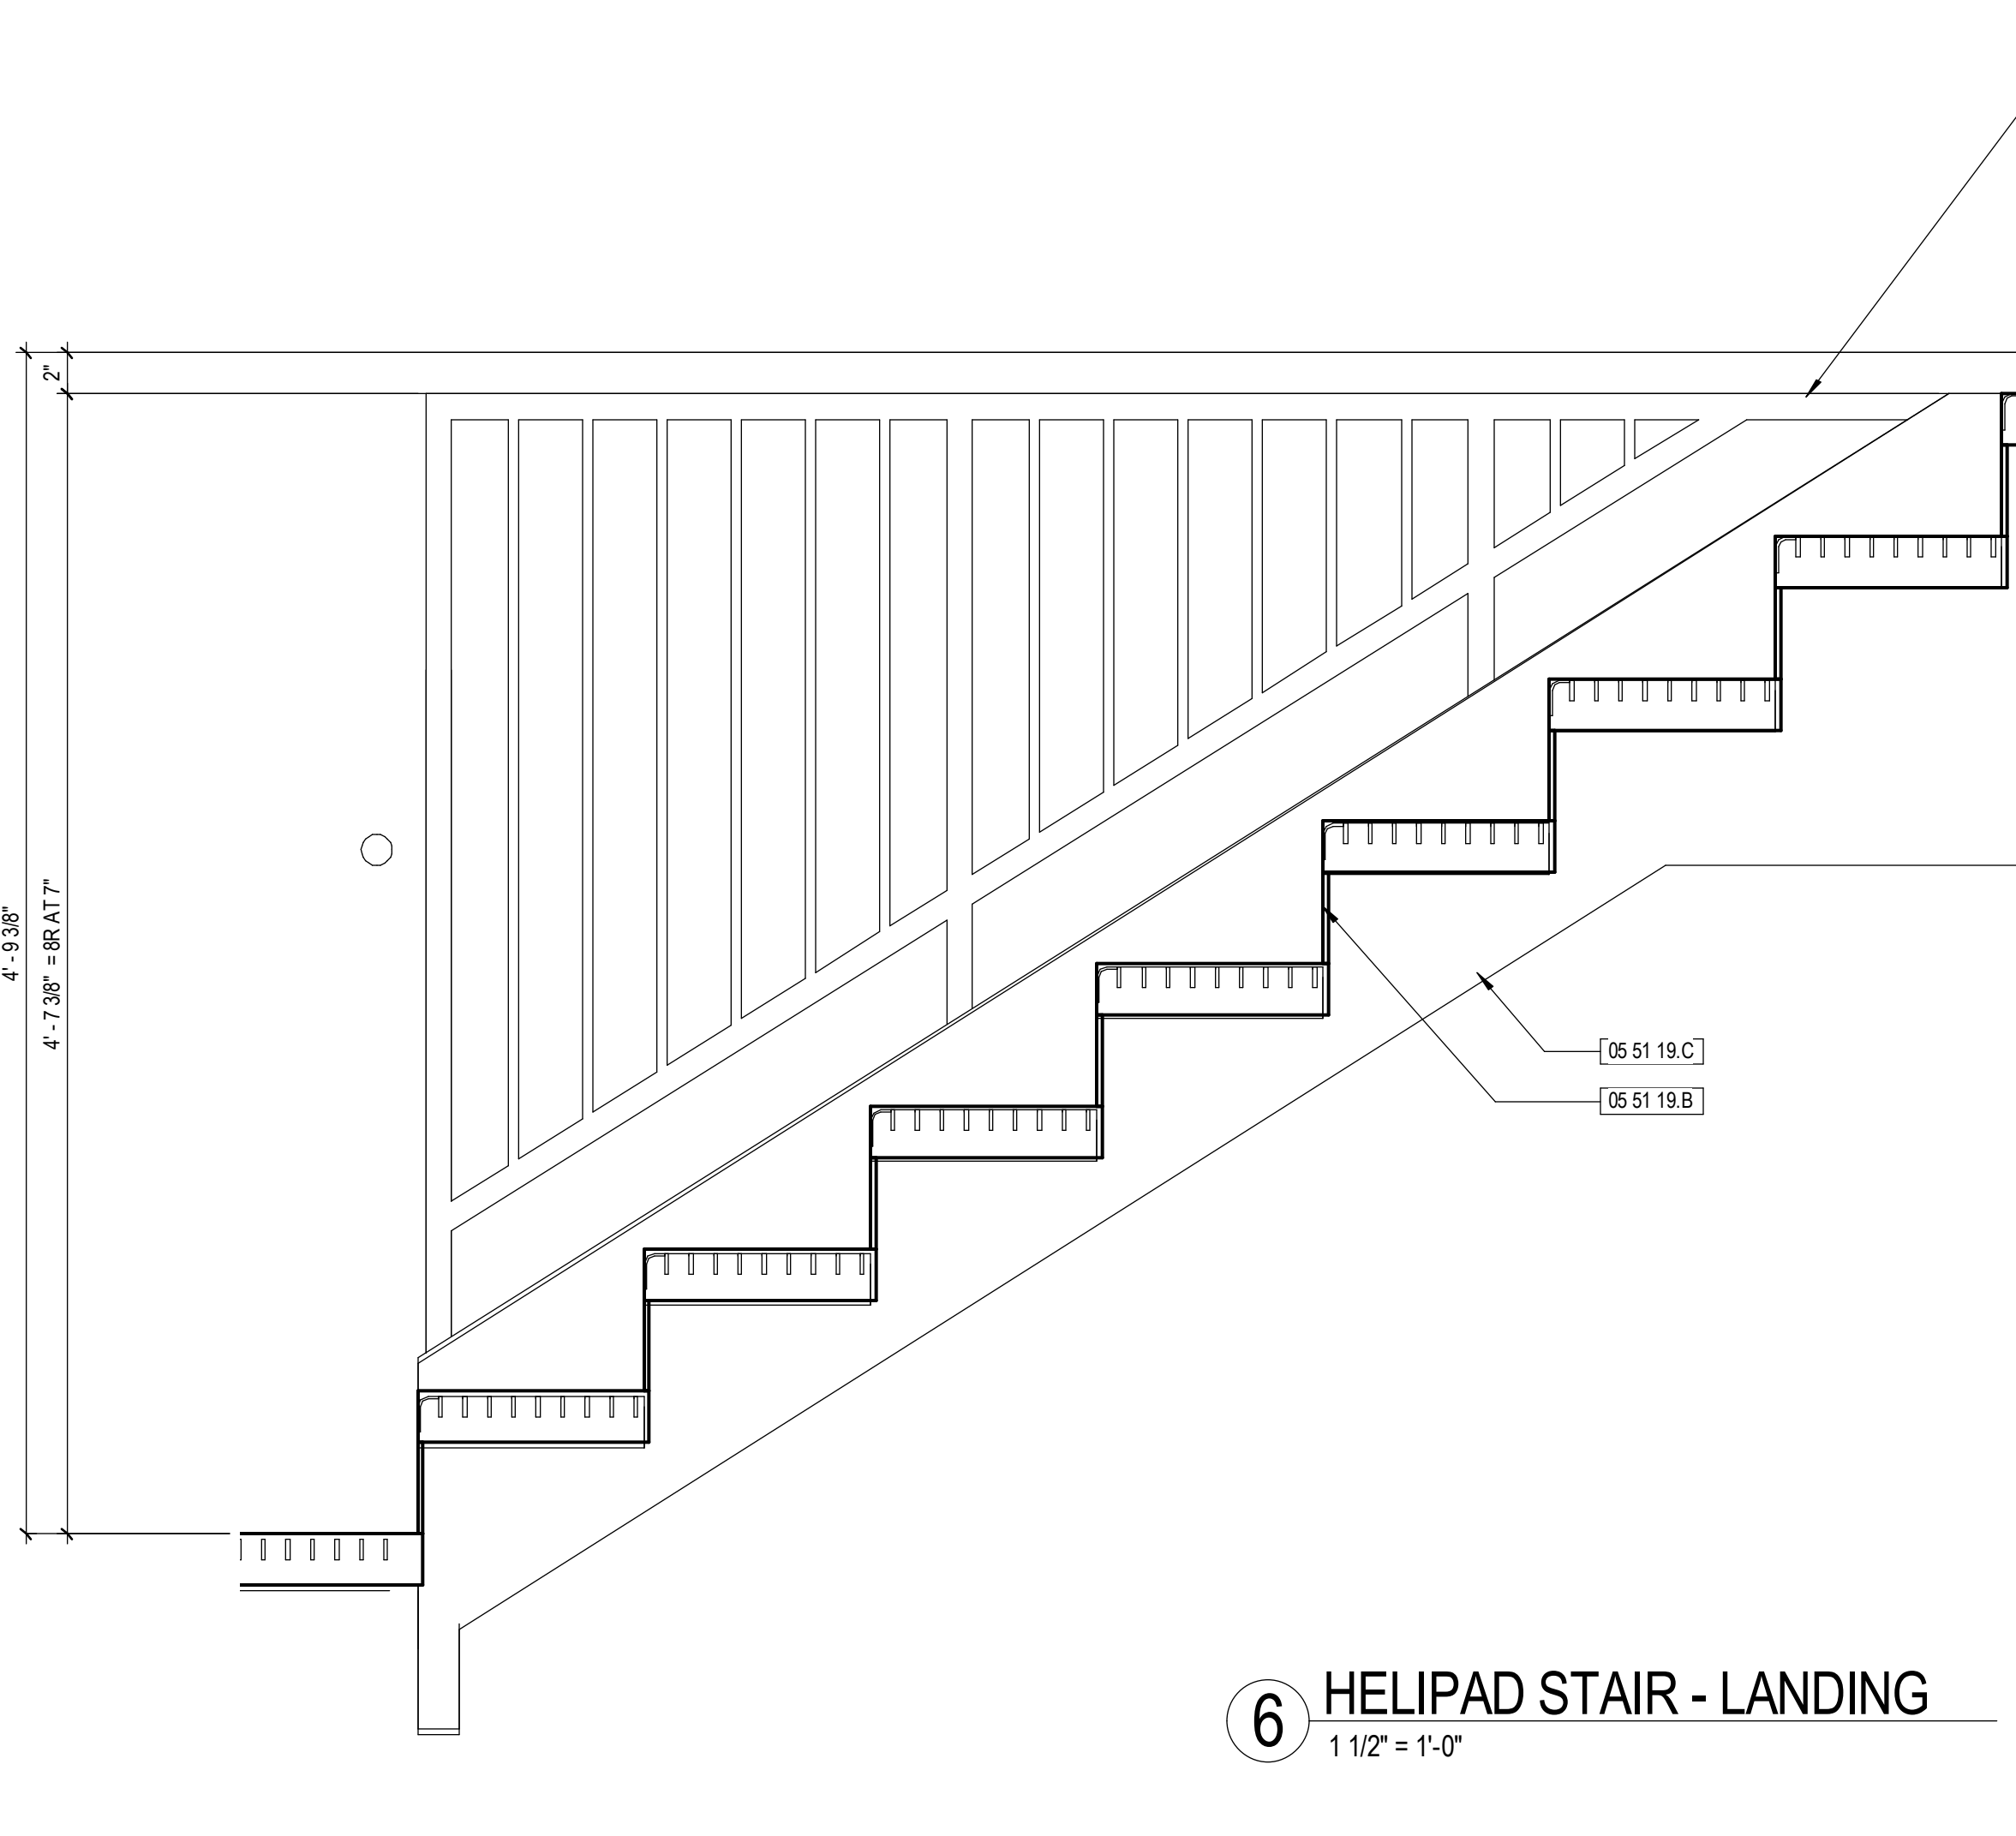


**6 HELIPAD STAIR - LANDING**  
1 1/2" = 1'-0"

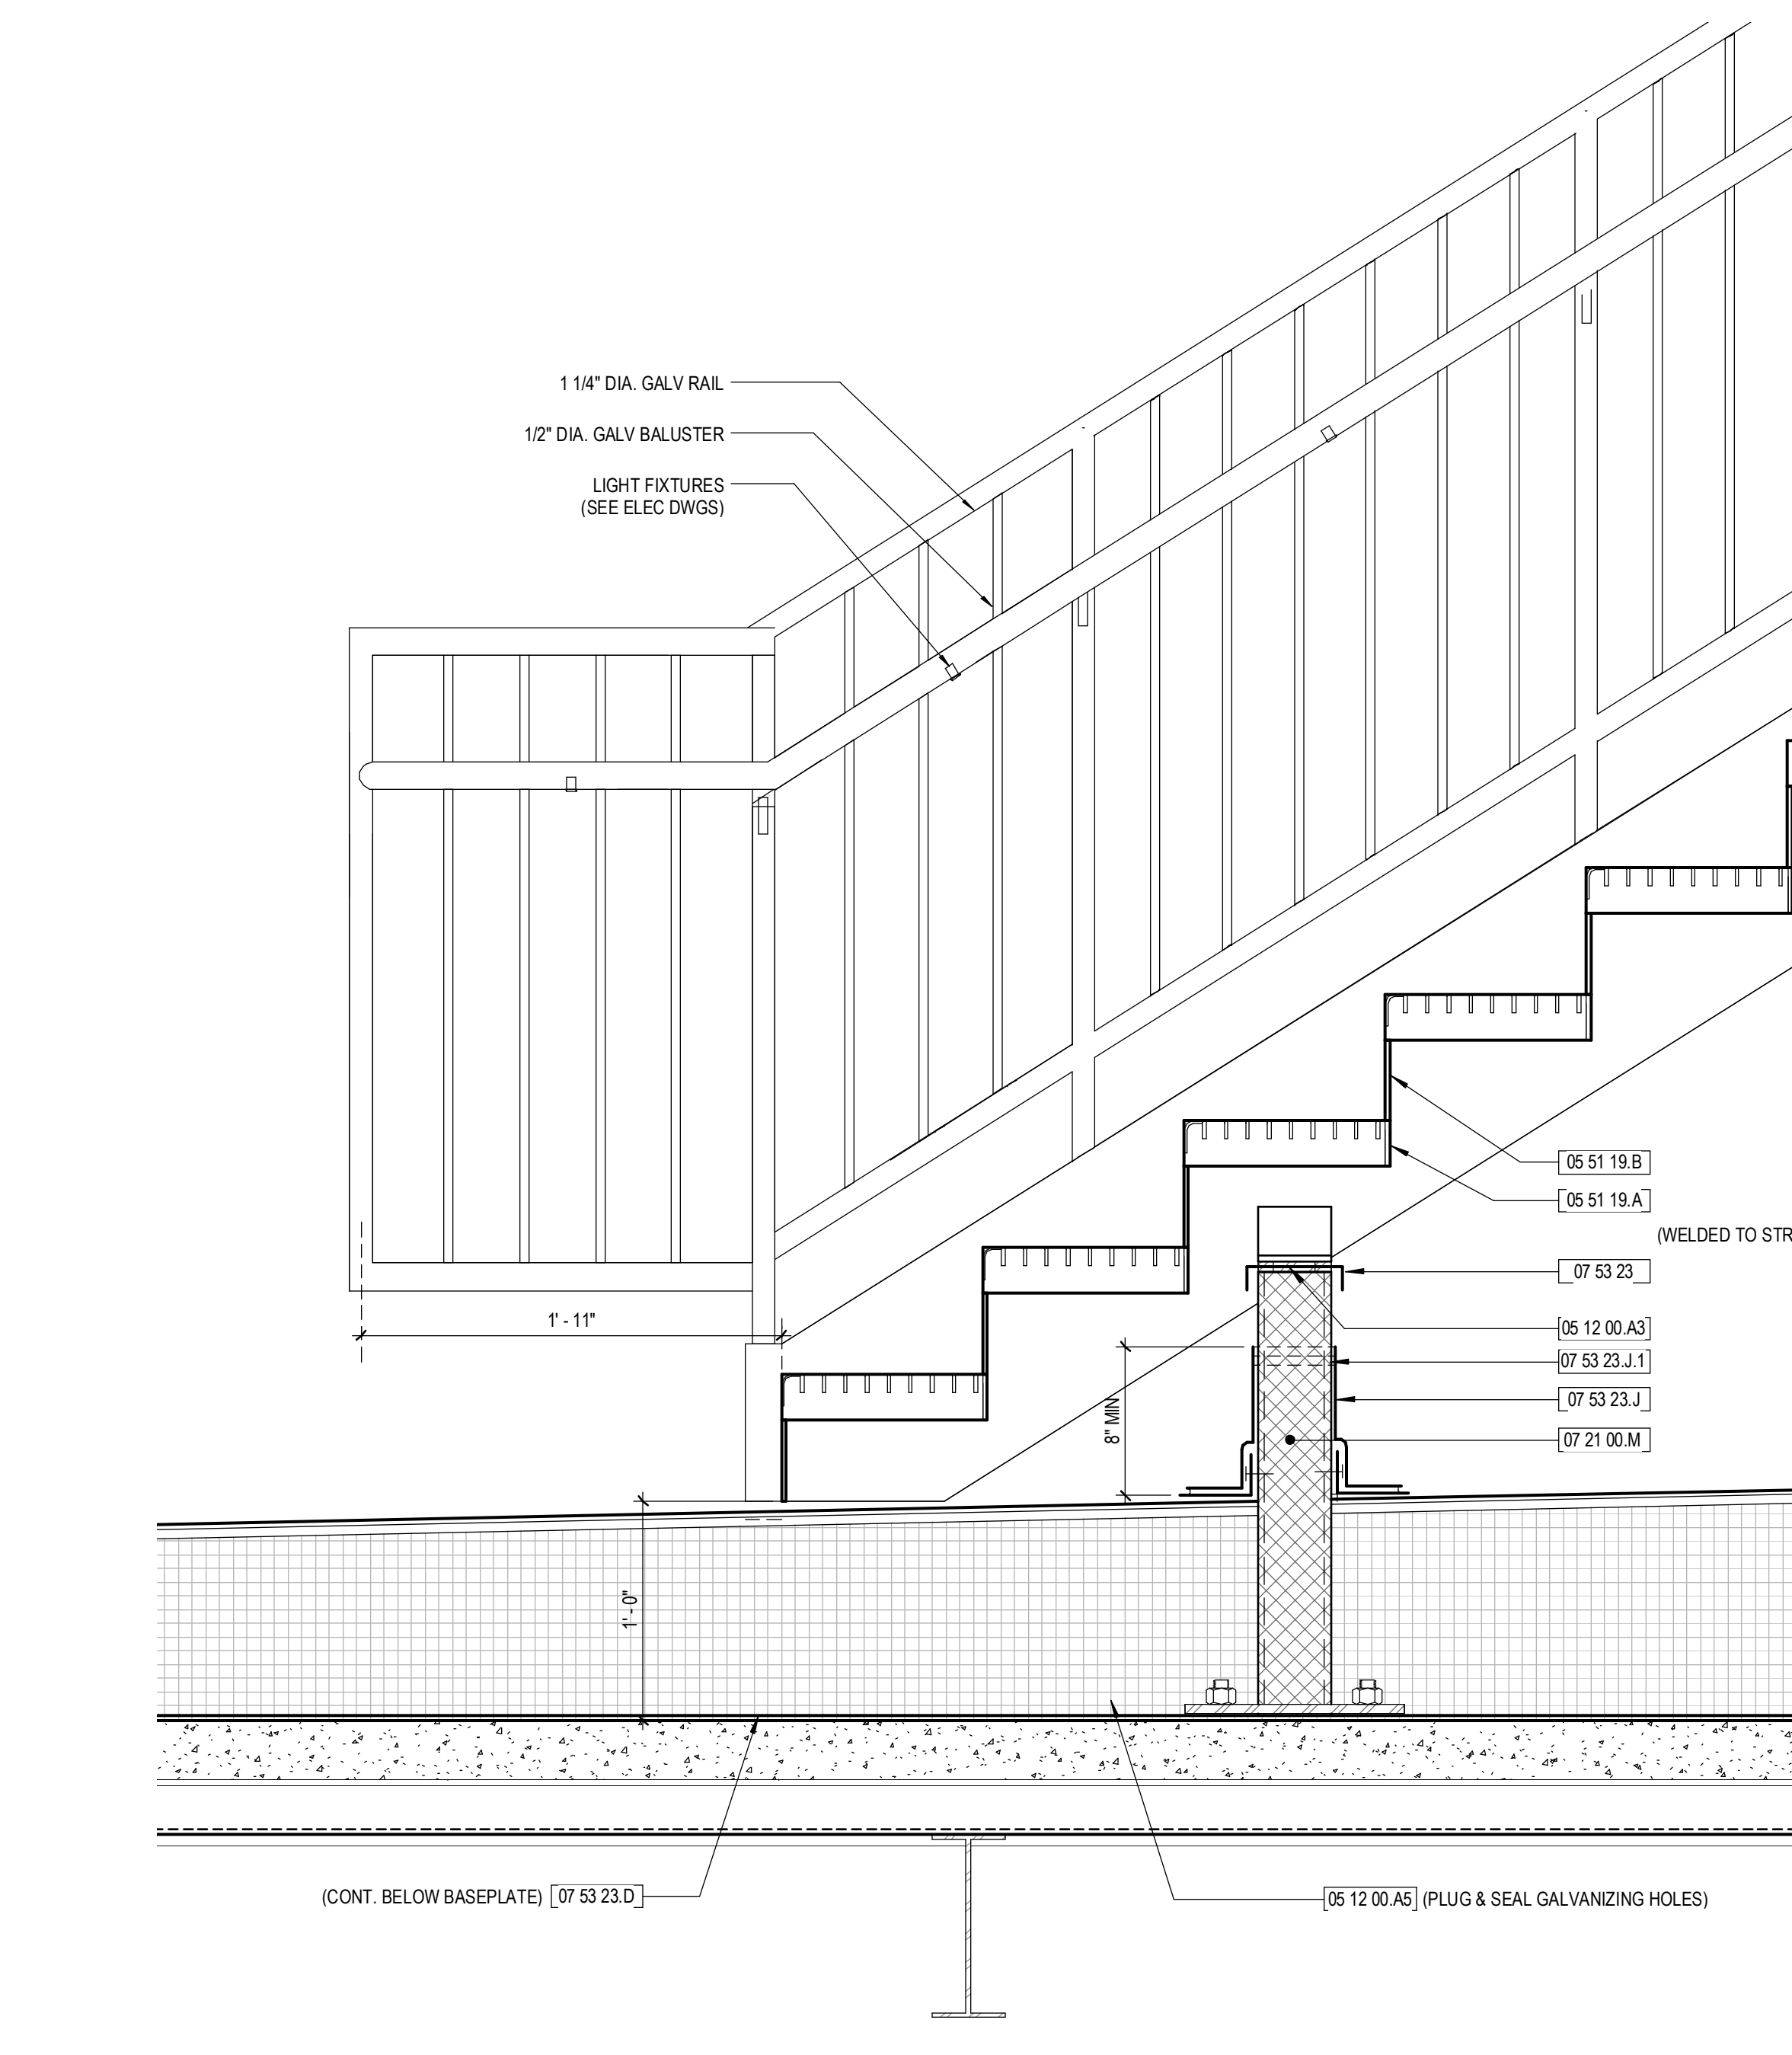


**4 HELIPAD STAIR - ROOF**  
1 1/2" = 1'-0"

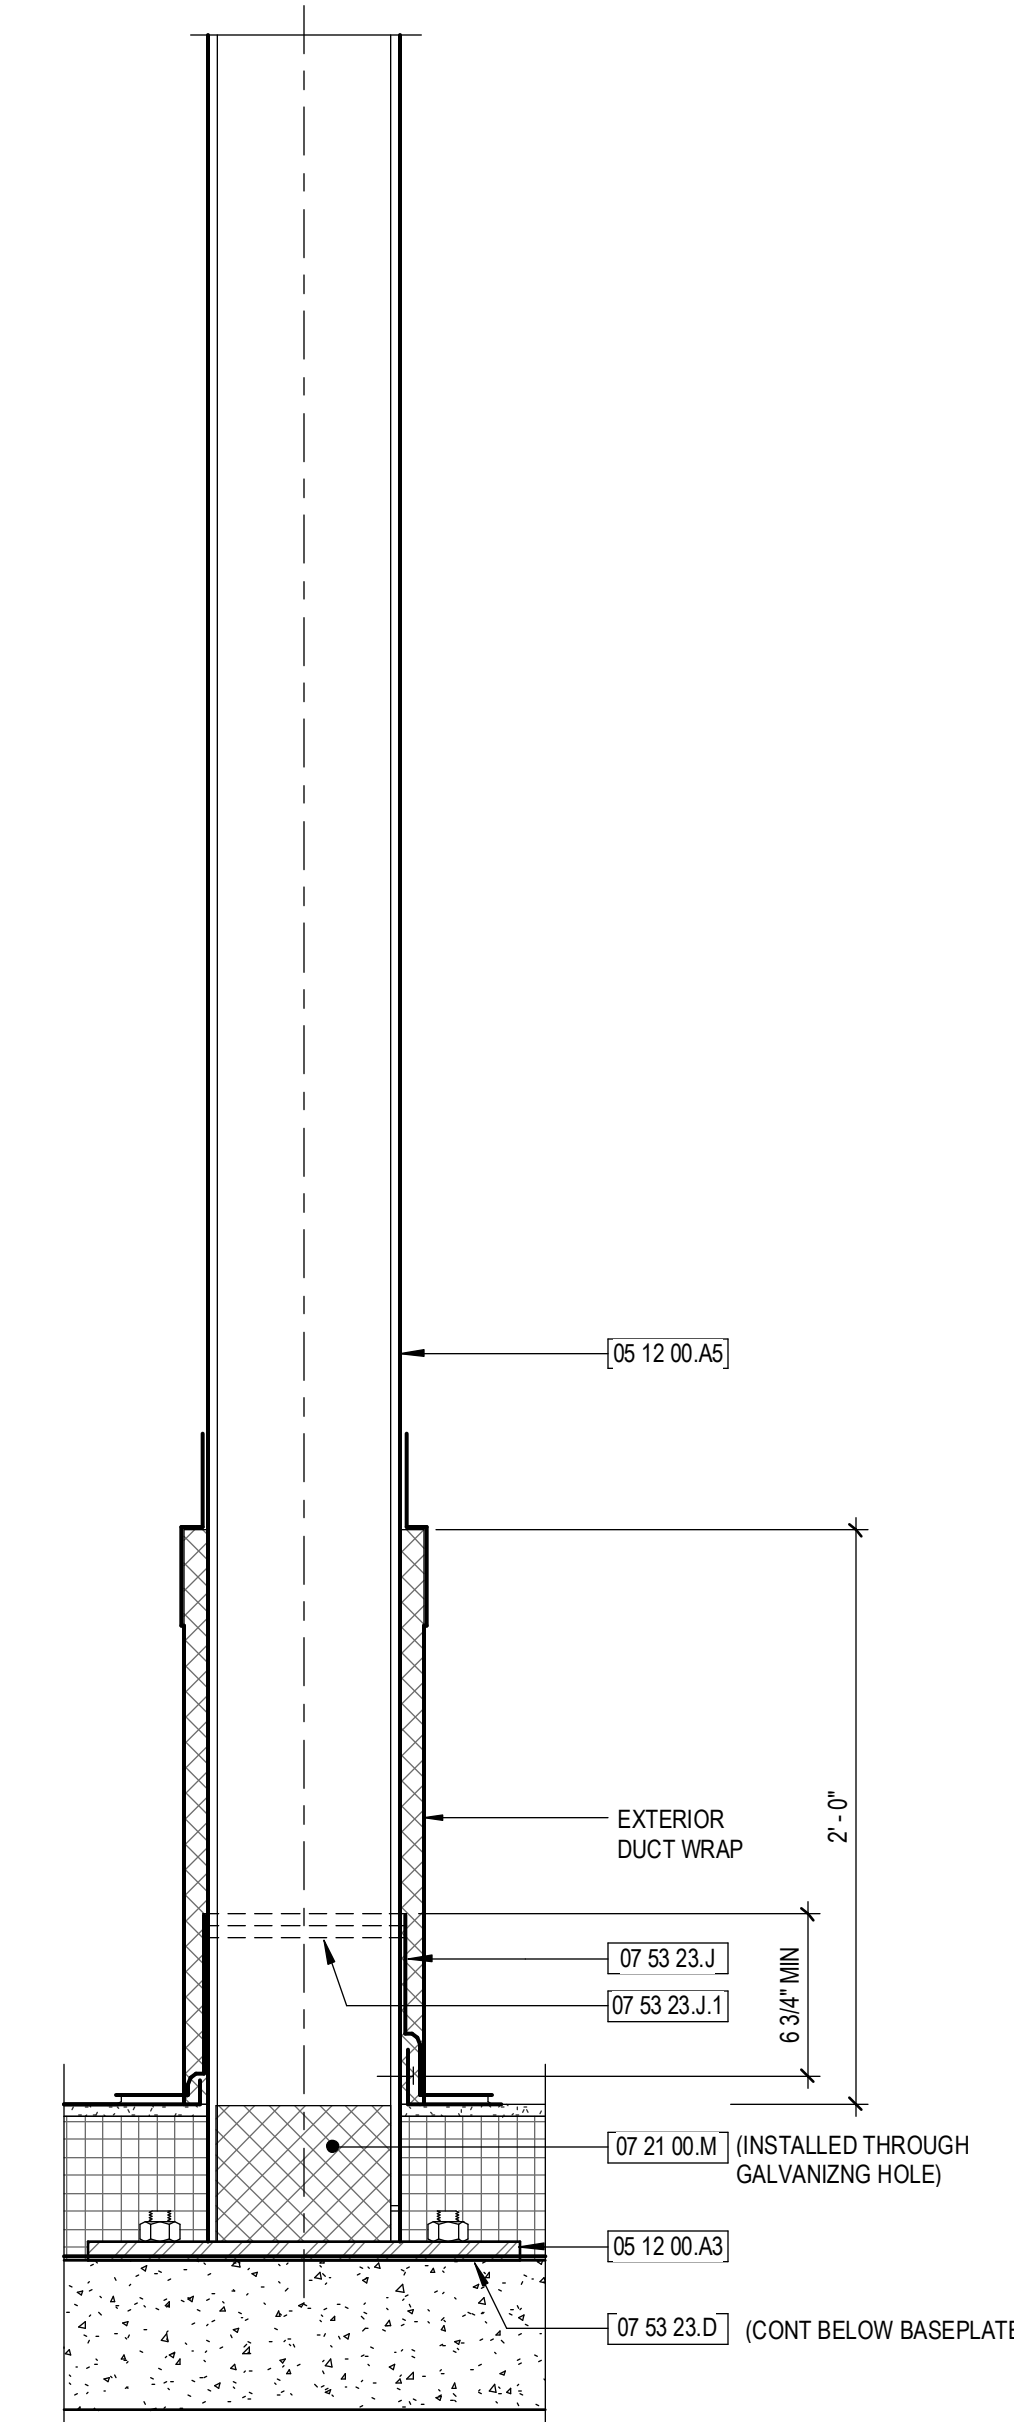

**3 HELIPAD COLUMN - ROOF**  
1 1/2" = 1'-0"

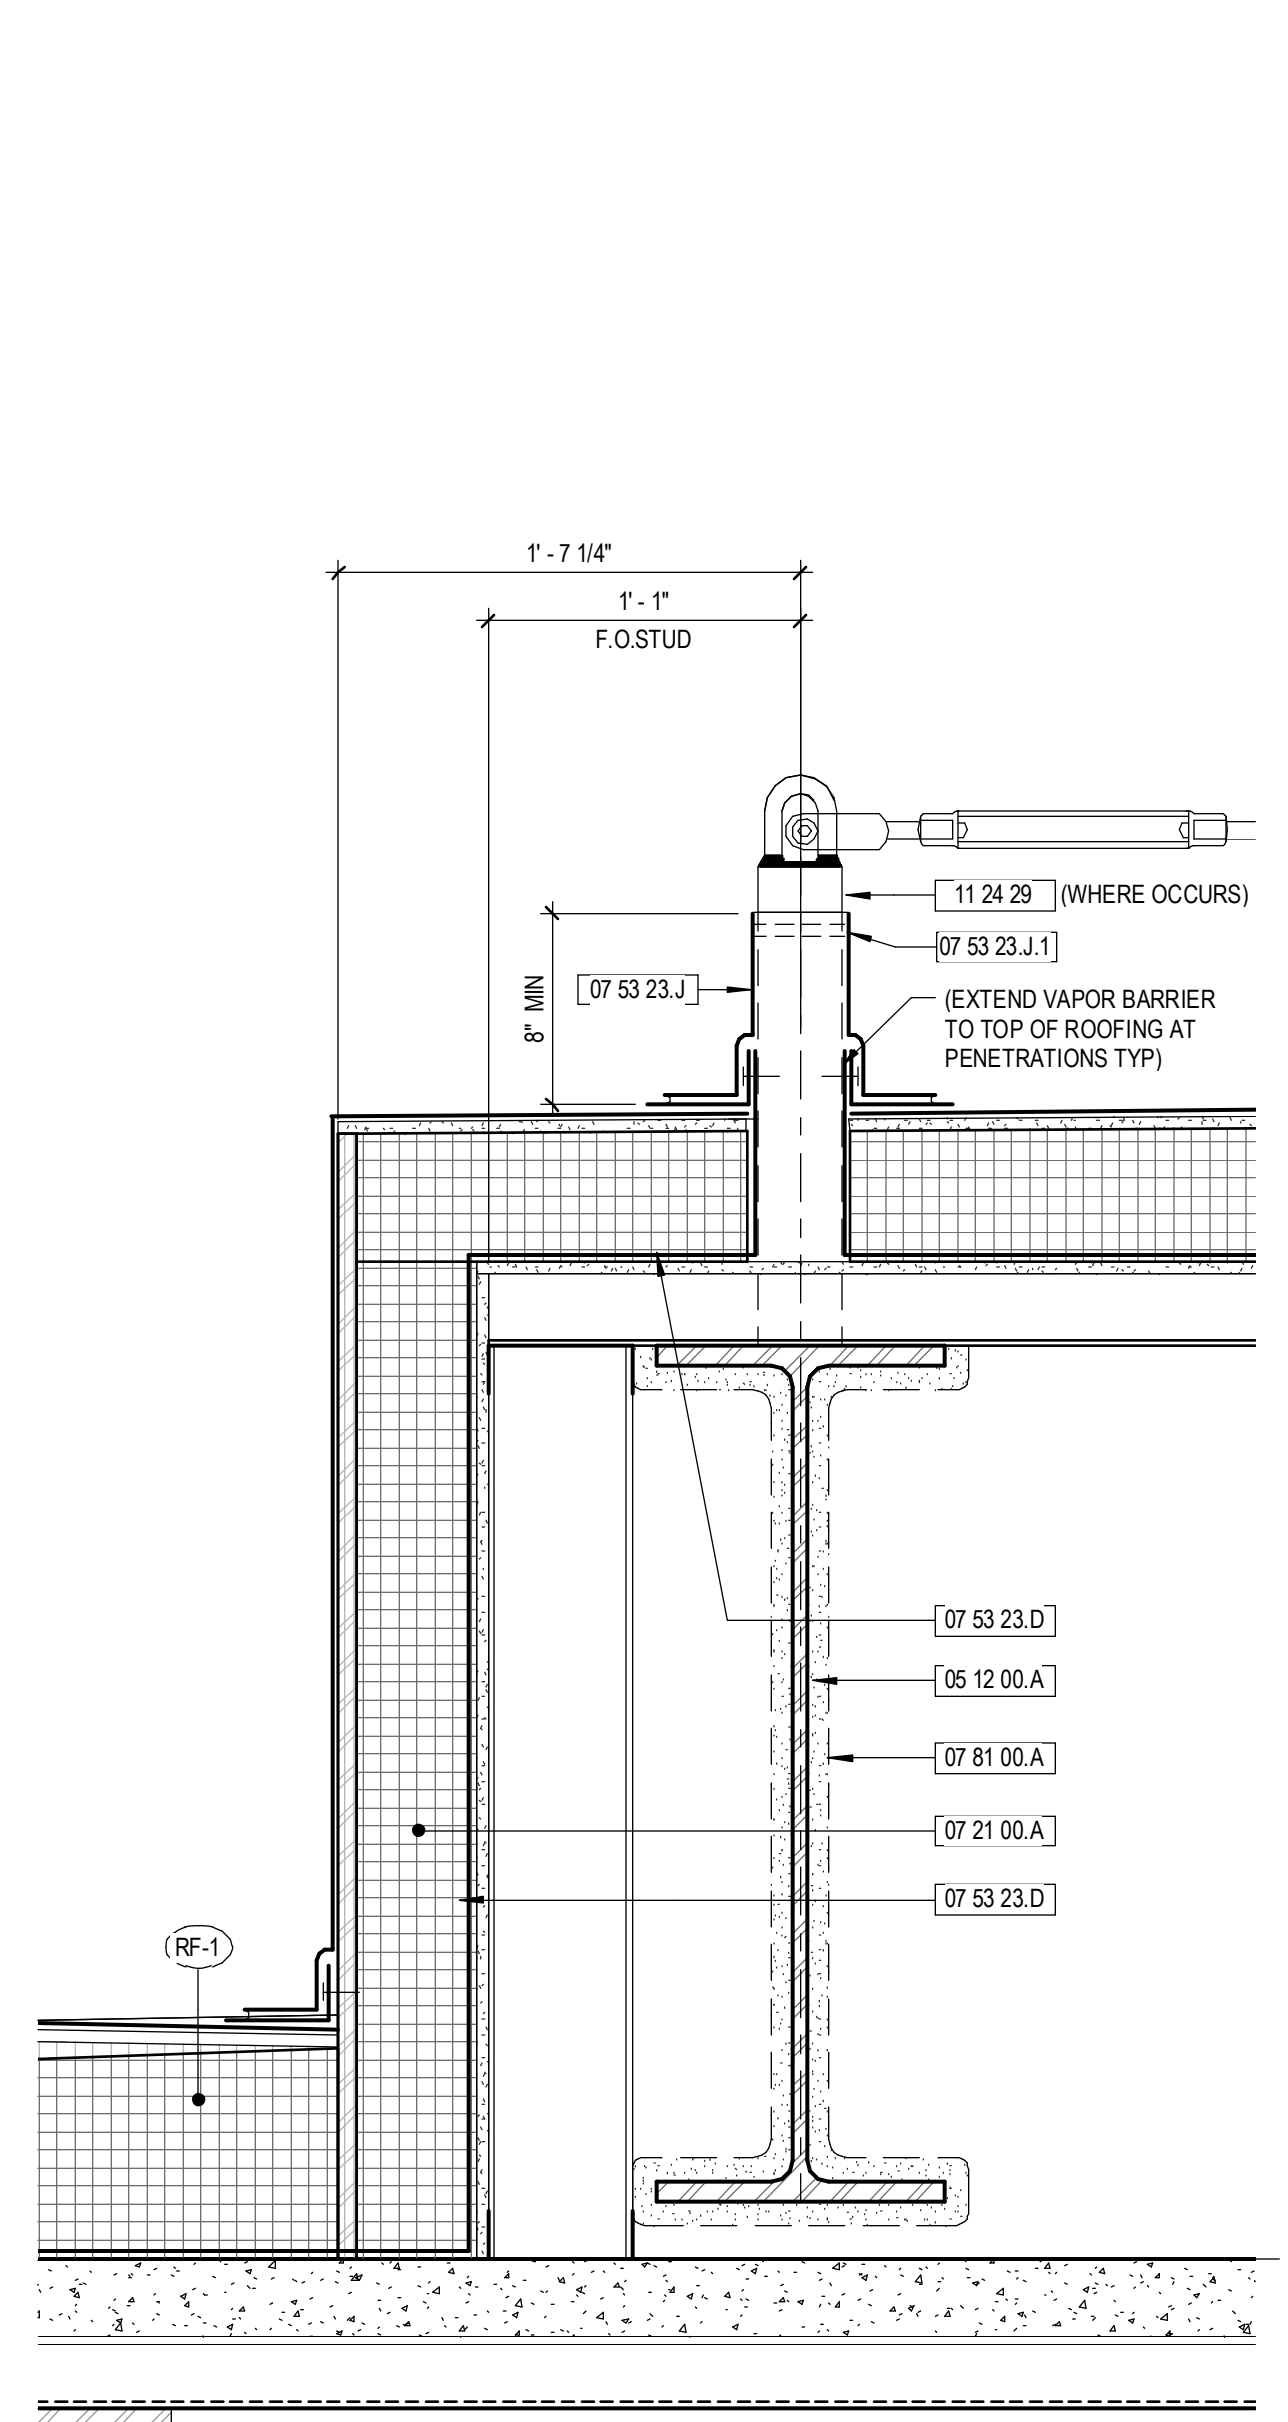

**2 HELIPAD - DUNNAGE AT ROOF**  
1 1/2" = 1'-0"

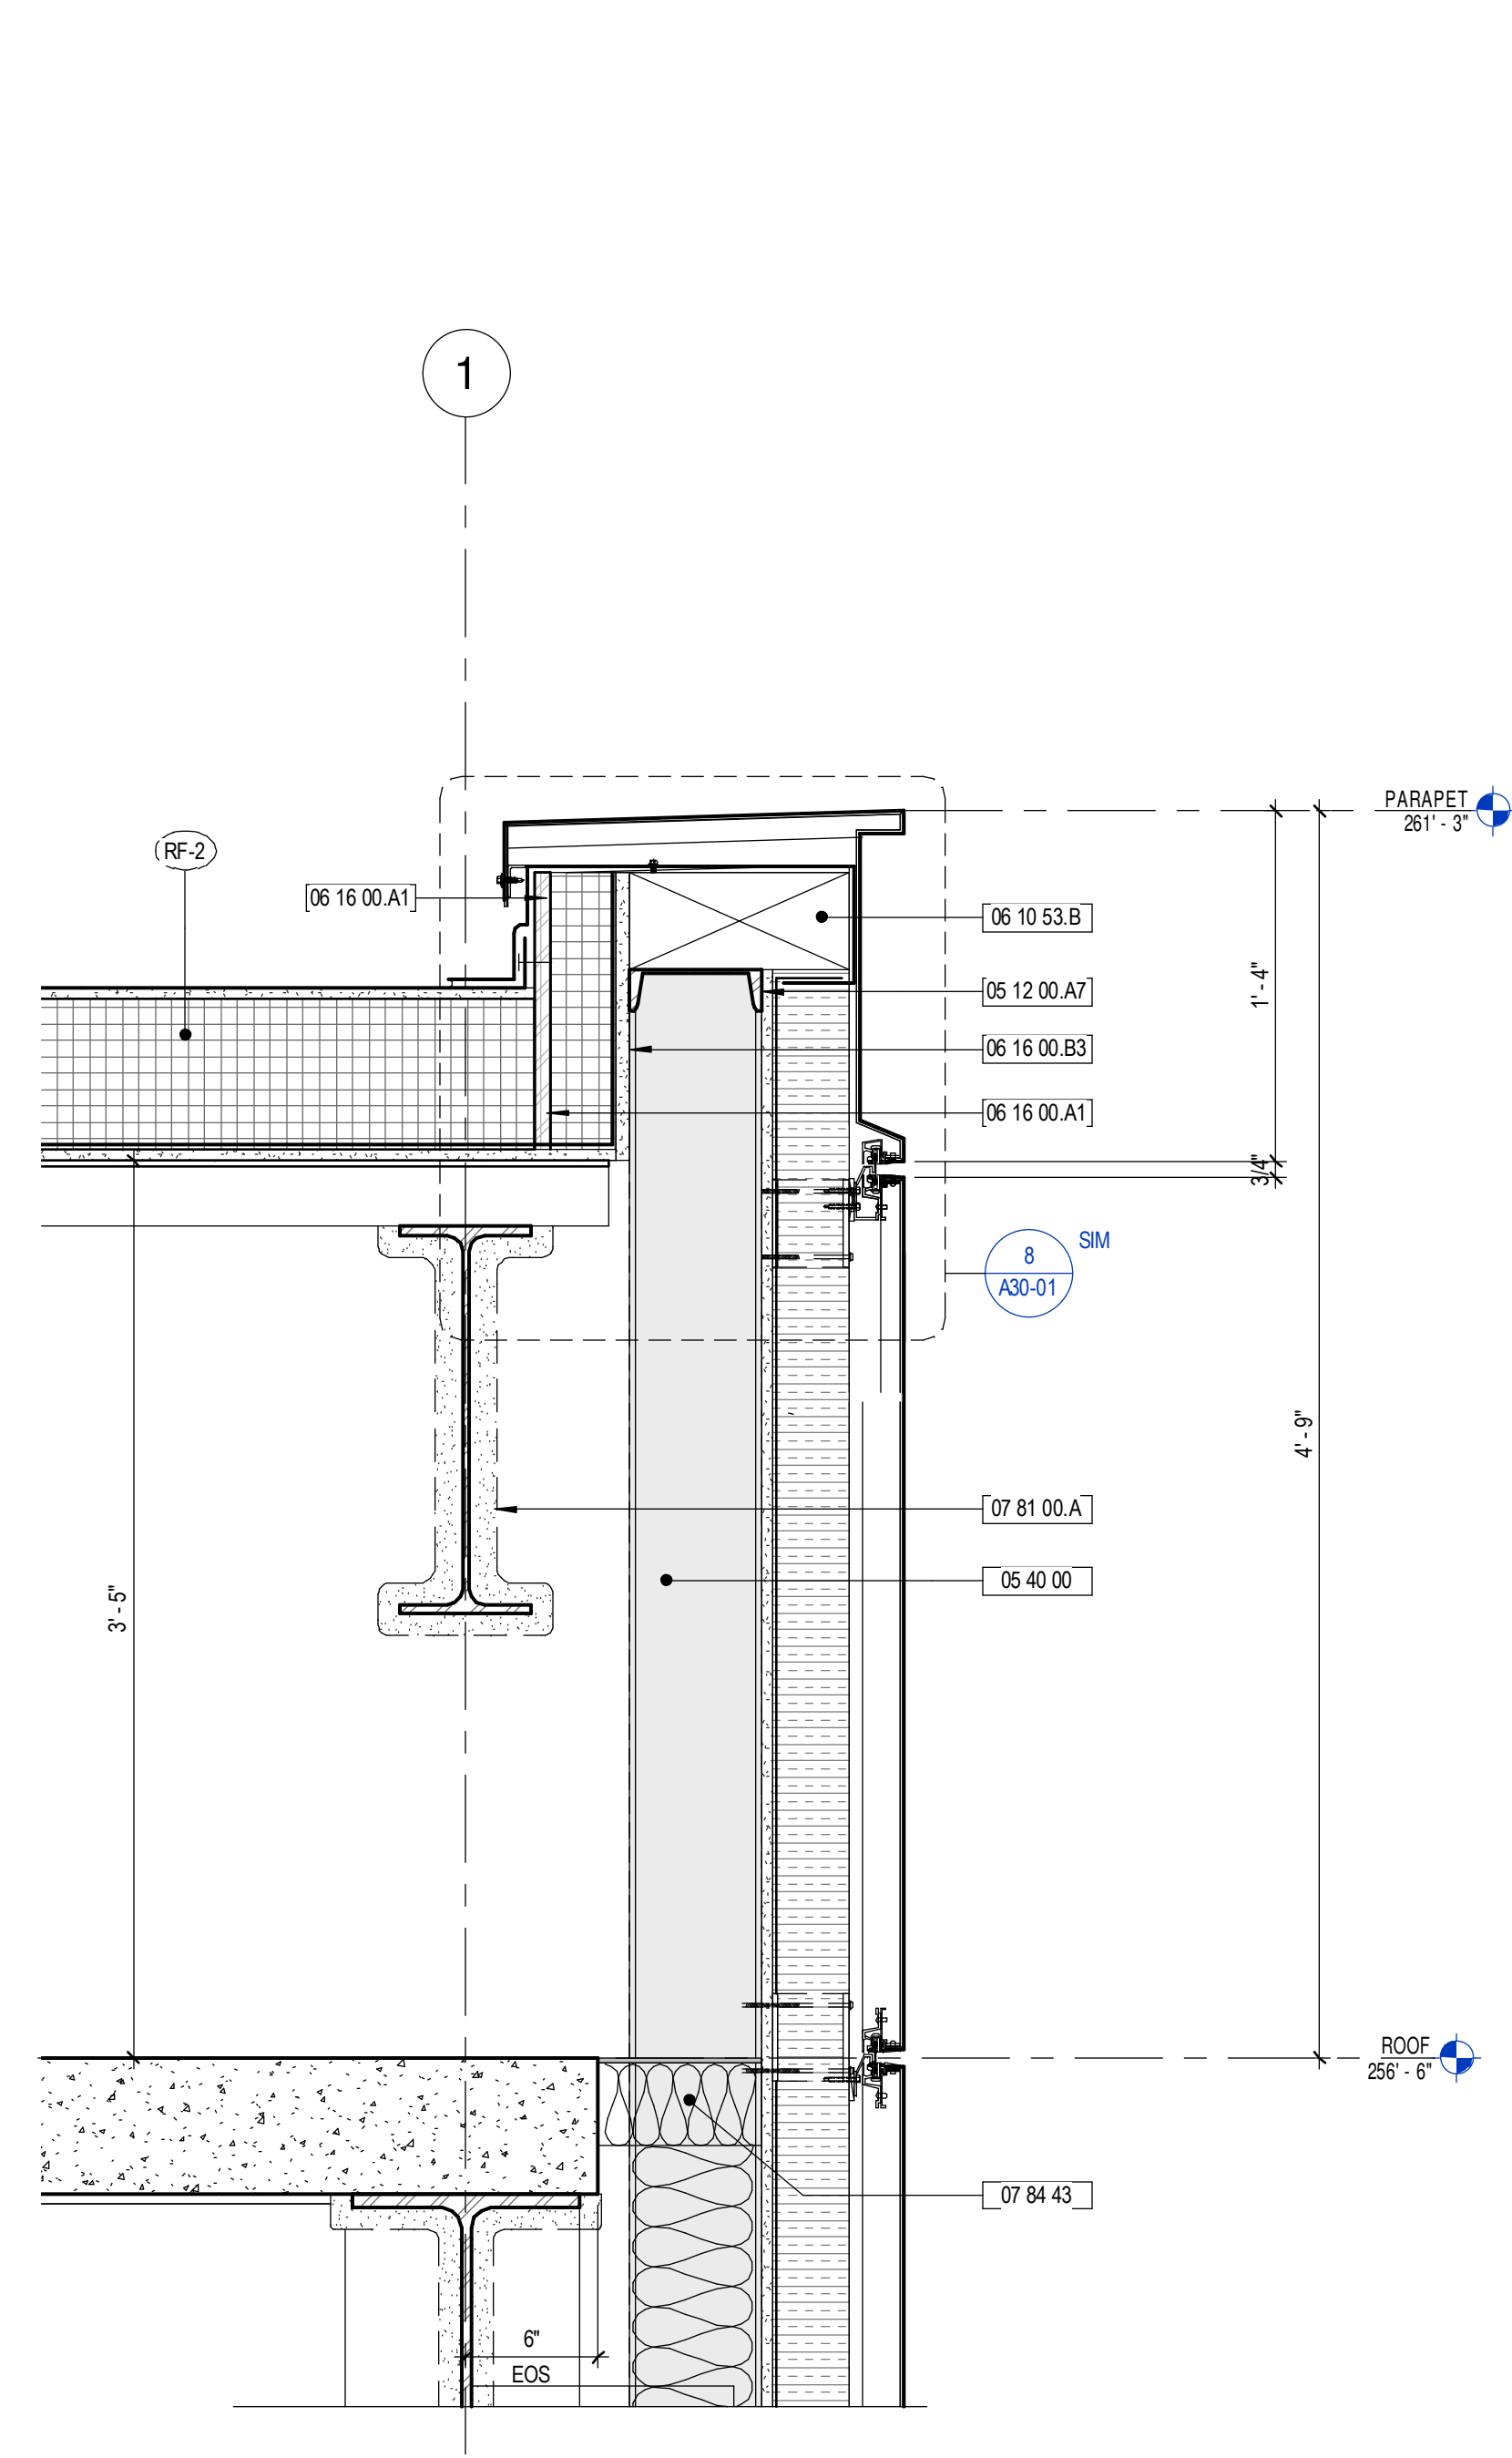

**1 HELIPAD - DUNNAGE AT PARAPET**  
1 1/2" = 1'-0"