
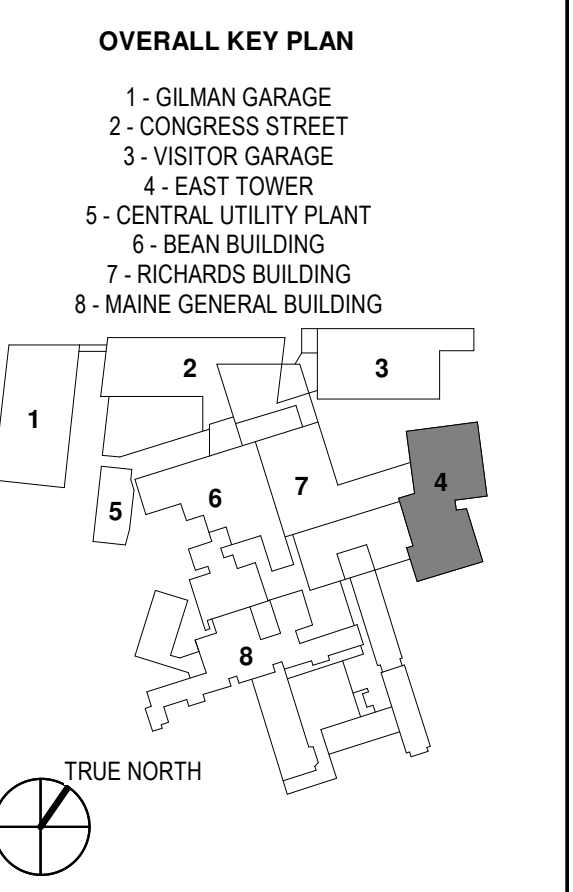


KEY PLANS

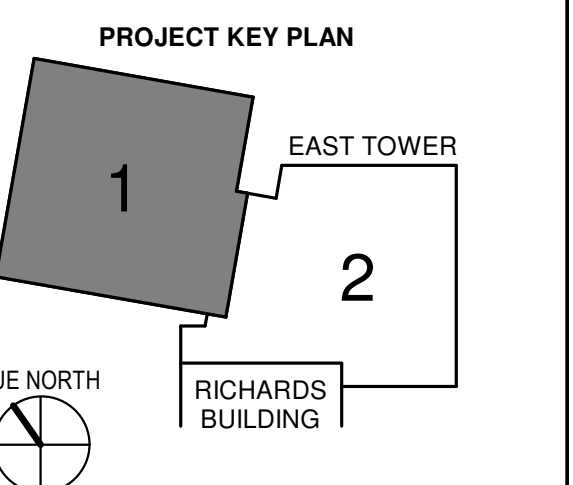

CONSTRUCTION DOCUMENTS
JANUARY 26, 2018


NO	ISSUE	DATE
1	ADDENDUM NO. 2	03/29/18

Job Number: B150012-000
Drawn: MAS
Checked: MFR
Approved: MFR

TITLE
**FIRE ALARM FIFTH
FLOOR PLAN -
SECTOR 1**

SHEET NUMBER

FA11-51

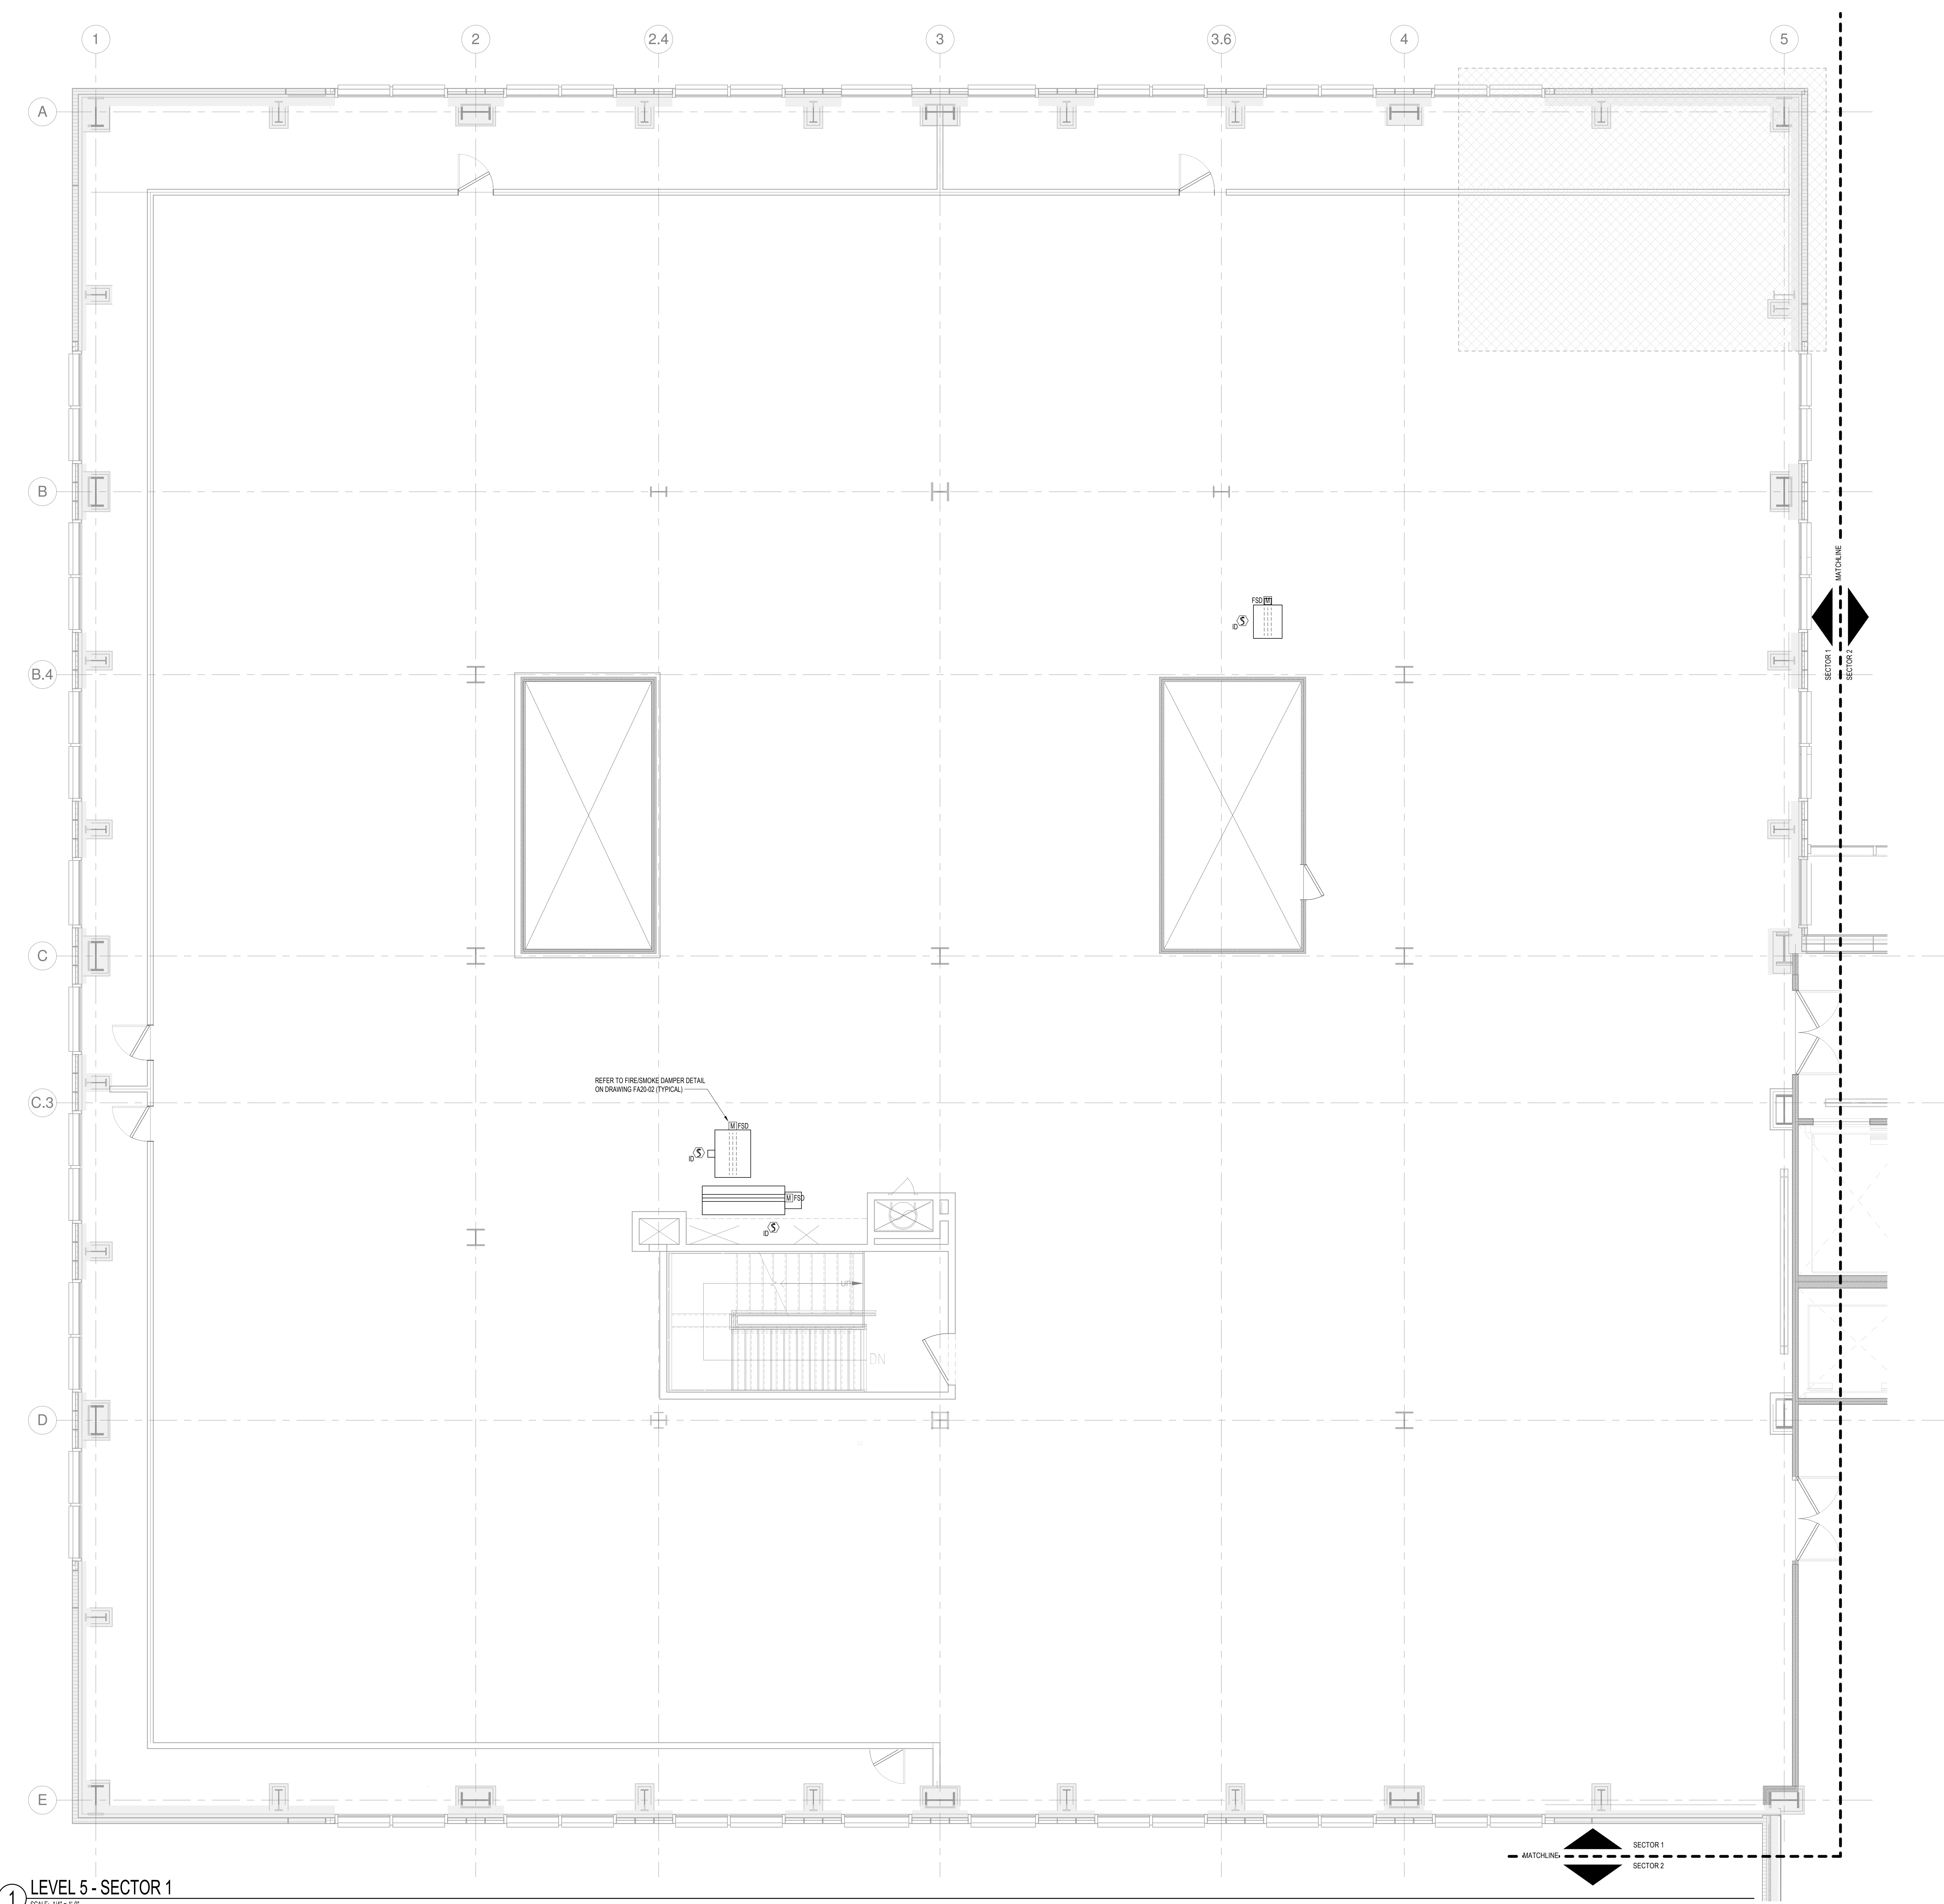

1 LEVEL 5 - SECTOR 1
SCALE: 1/4" = 1'-0"

3/29/2018 11:18:37 AM
C:\Revit Local Files_B150012\000\MDC East Tower 6&7 MEP17_Constral_construction.rvt