
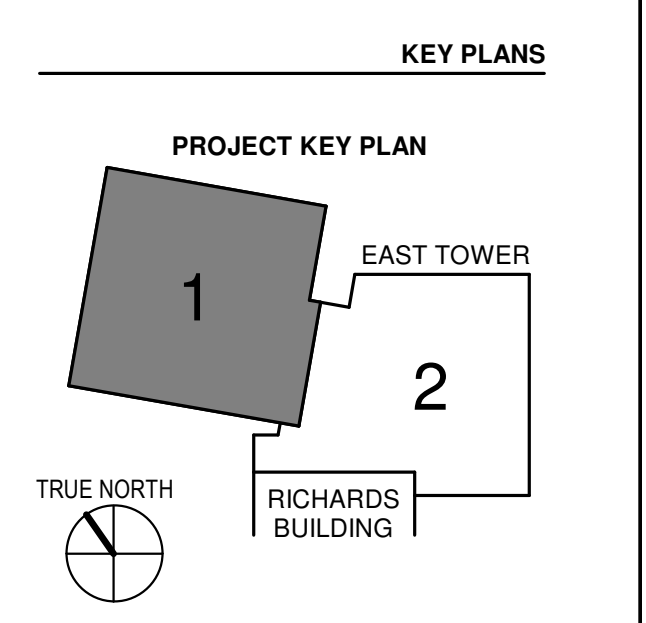


**DRAWING NOTES - SIXTH FLOOR:**  
 1. REFER TO DRAWING FA20-01 FOR FIRE ALARM SYMBOLS, NOTES AND SCHEDULES.  
 2. REFER TO DRAWING FA20-01 FOR FIRE ALARM RISER DIAGRAM.  
 3. REFER TO FRESMOKE DAMPER DETAIL ON DRAWING FA20-02 FOR WIRING INFORMATION.

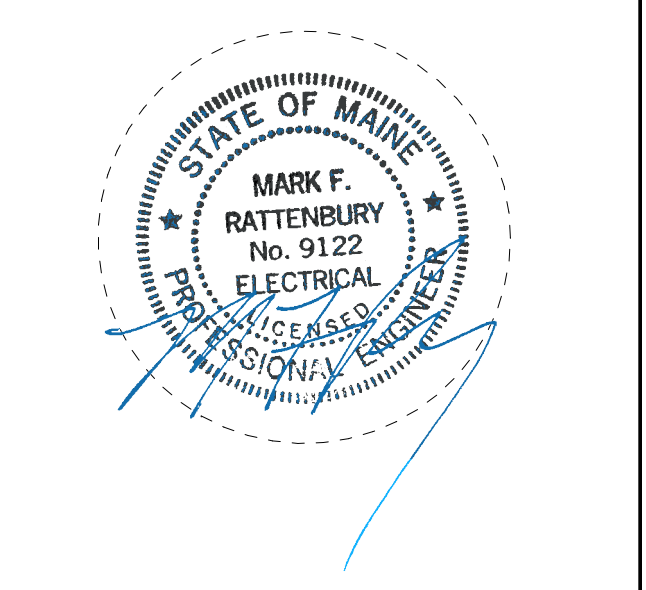

**CONSTRUCTION DOCUMENTS**  
 JANUARY 28, 2018

NO	ISSUE	DATE
1	ADDENDUM NO. 2	03/29/18

Job Number: B150312-000  
 Drawn: MGS  
 Checked: MFR  
 Approved: MFR

**TITLE**  
 FIRE ALARM SIXTH  
 FLOOR PLAN -  
 SECTOR 1

**LEVEL 6 - SECTOR 1**  
 SCALE: 1/8" = 1'-0"

3/29/2018 11:19:23 AM  
 C:\Revit Local Files\_B150312\000\MDC East Tower 6&7 MEP17\_Constr\_documents.rvt