



- OVERALL KEY PLAN
- 1 - GILMAN GARAGE
  - 2 - CONGRESS STREET
  - 3 - VISITOR GARAGE
  - 4 - EAST TOWER
  - 5 - CENTRAL UTILITY PLANT
  - 6 - BEAN BUILDING
  - 7 - RICHARDS BUILDING
  - 8 - MAINE GENERAL BUILDING

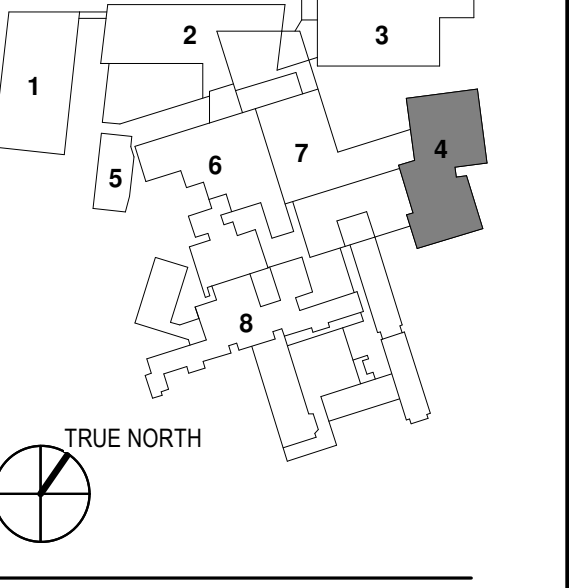


2	ADDENDUM NO. 2	03/29/18
1	ADDENDUM NO. 1	03/22/18
NO	ISSUE	DATE
Job Number	B150312-000	
Drawn	MAG	
Checked	MFR	
Approved	MFR	

- DRAWING NOTES - SEVENTH FLOOR
1. REFER TO DRAWING FA20-01 FOR FIRE ALARM SYMBOLS, NOTES AND SCHEDULES.
  2. REFER TO DRAWING FA20-01 FOR FIRE ALARM RISER DIAGRAM.
  3. REFER TO FRESMOKE DAMPER DETAIL ON DRAWING FA20-02 FOR WIRING INFORMATION.

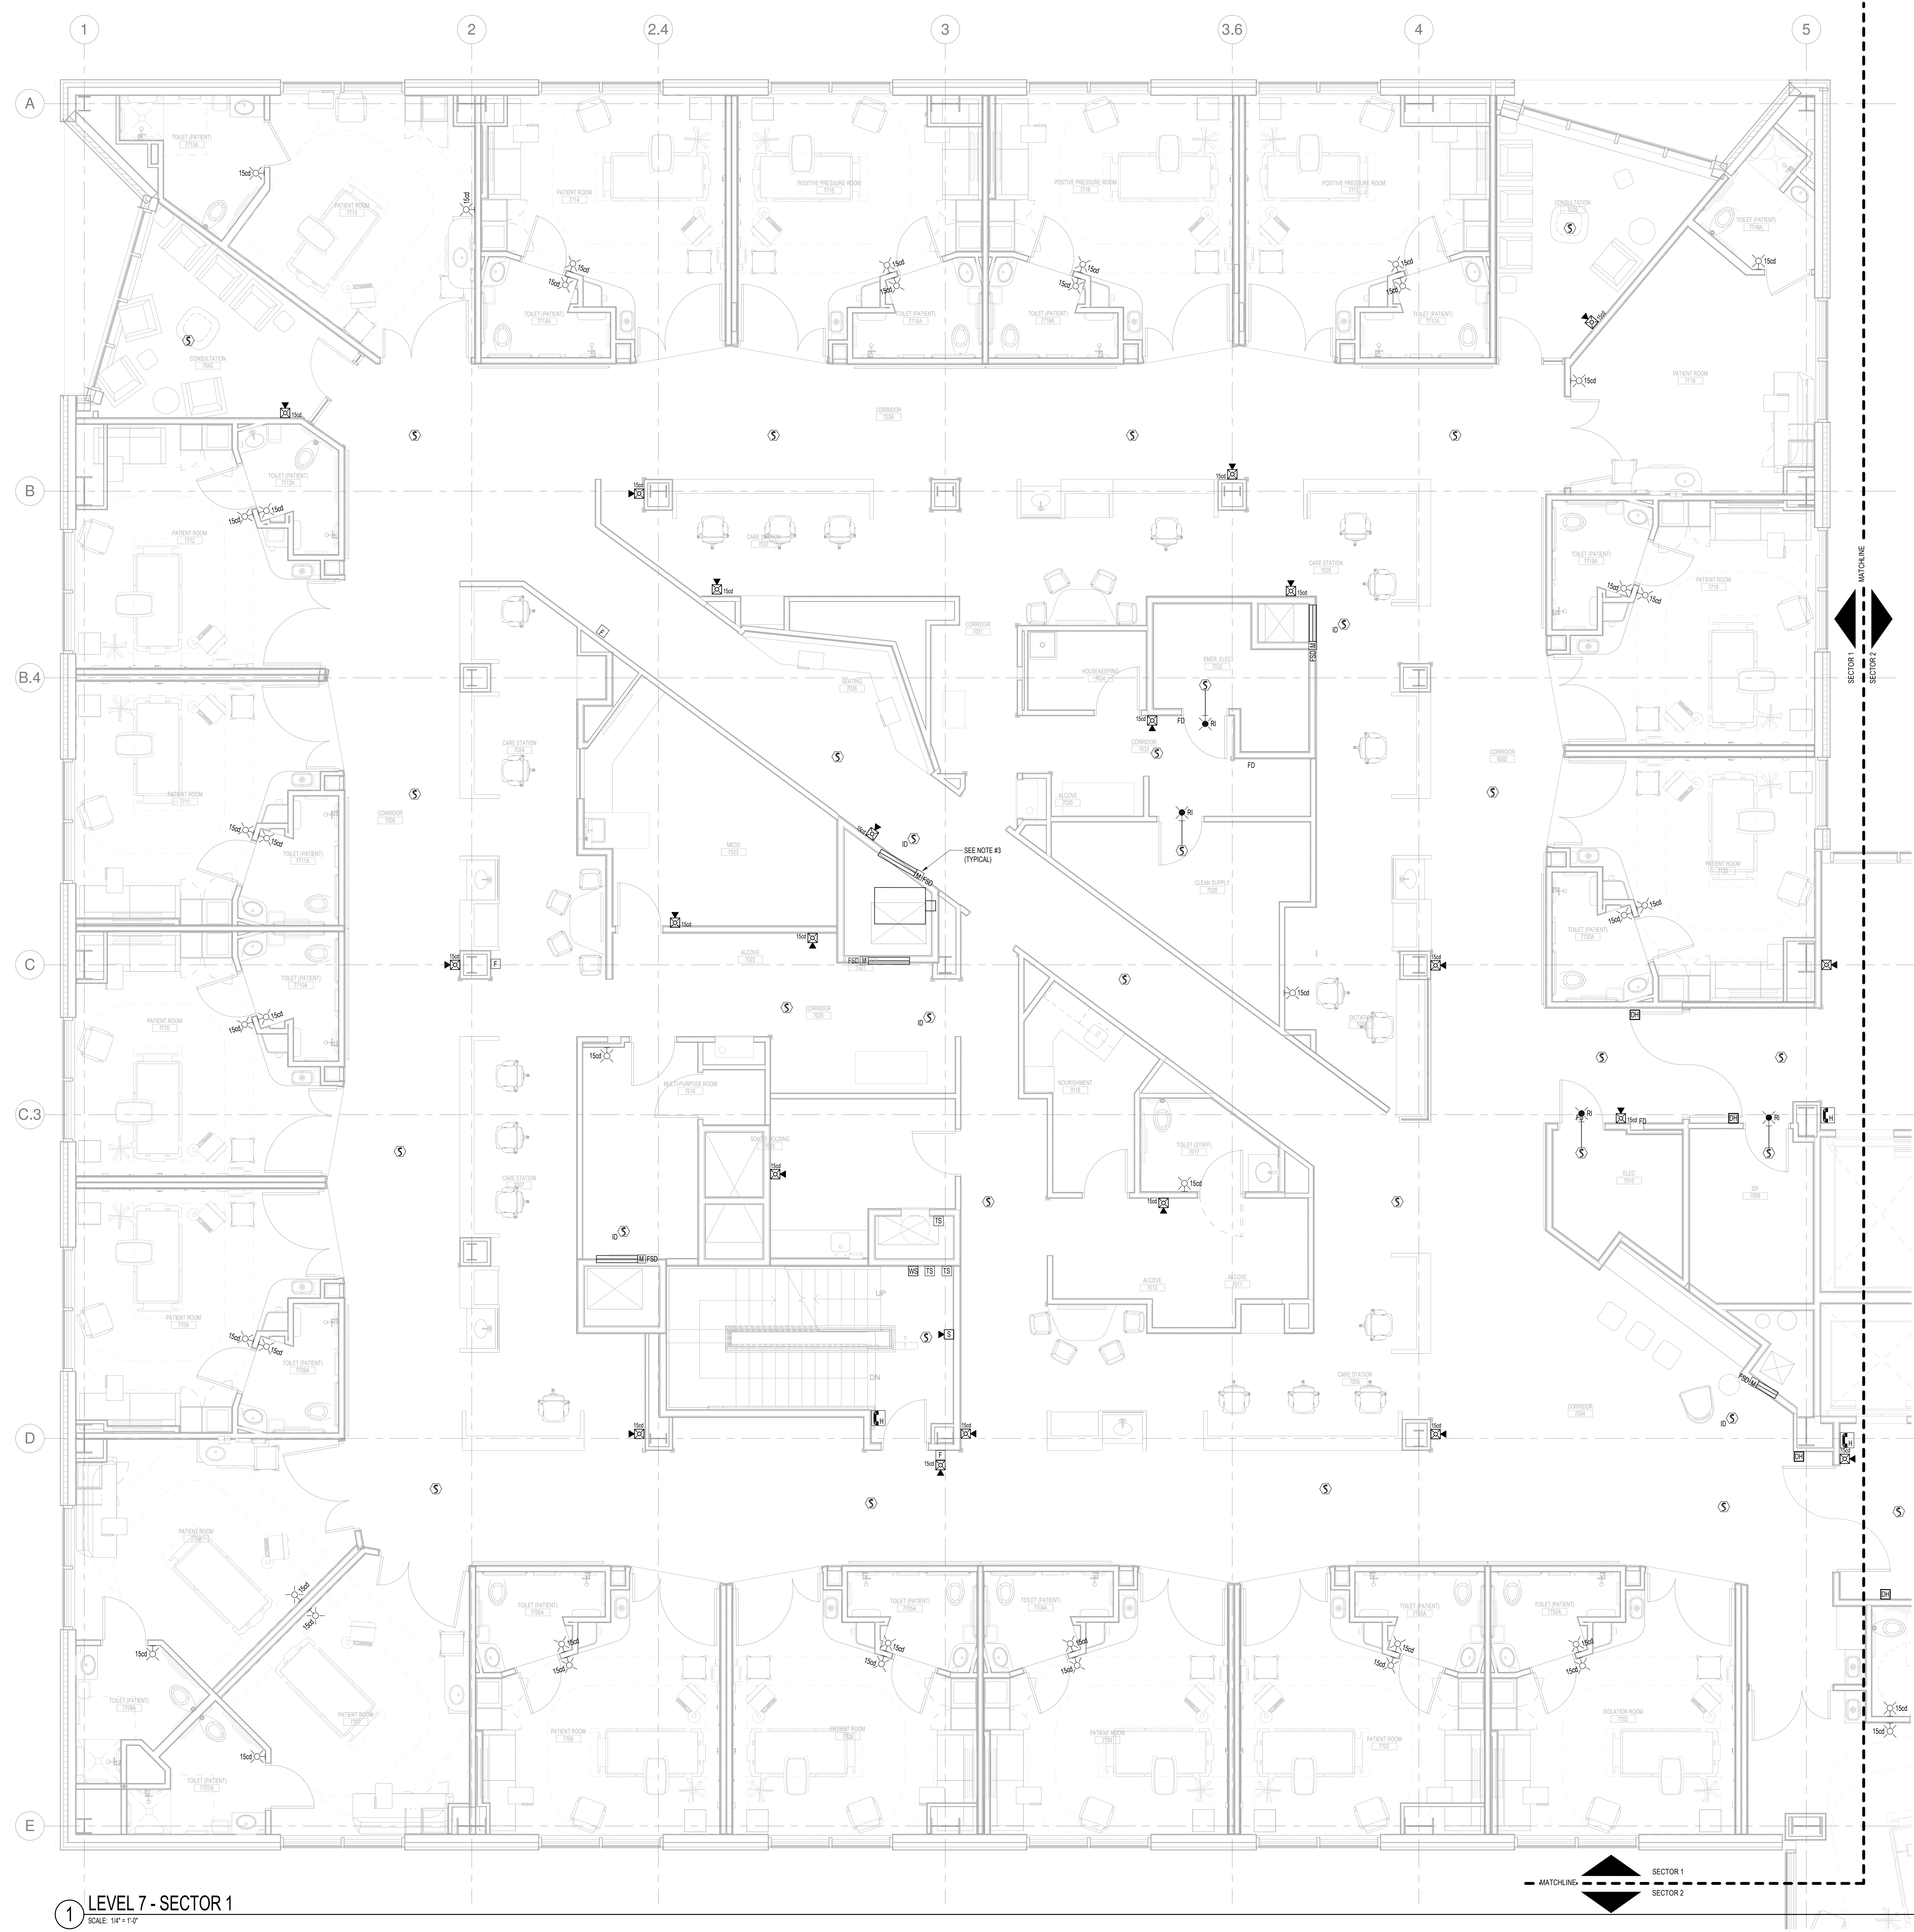

1 LEVEL 7 - SECTOR 1  
SCALE: 1/8" = 1'-0"

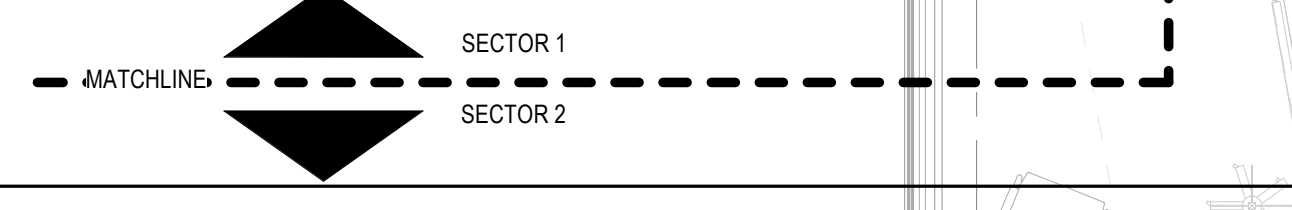

3/29/2018 11:20:31 AM C:\Revit Local Files\_B150312\000\MDC East Tower 6&7 MEP17\_Constr\_documents.rvt