


NO	ISSUE	DATE
Job Number	B150312-000	
Drawn	MMS	
Checked	MFR	
Approved	MFR	

DRAWING NOTES - ROOF  
1. REFER TO DRAWING FA20-01 FOR FIRE ALARM SYMBOLS, NOTES AND SCHEDULES.  
2. REFER TO DRAWING FA20-01 FOR FIRE ALARM RISER DIAGRAM.

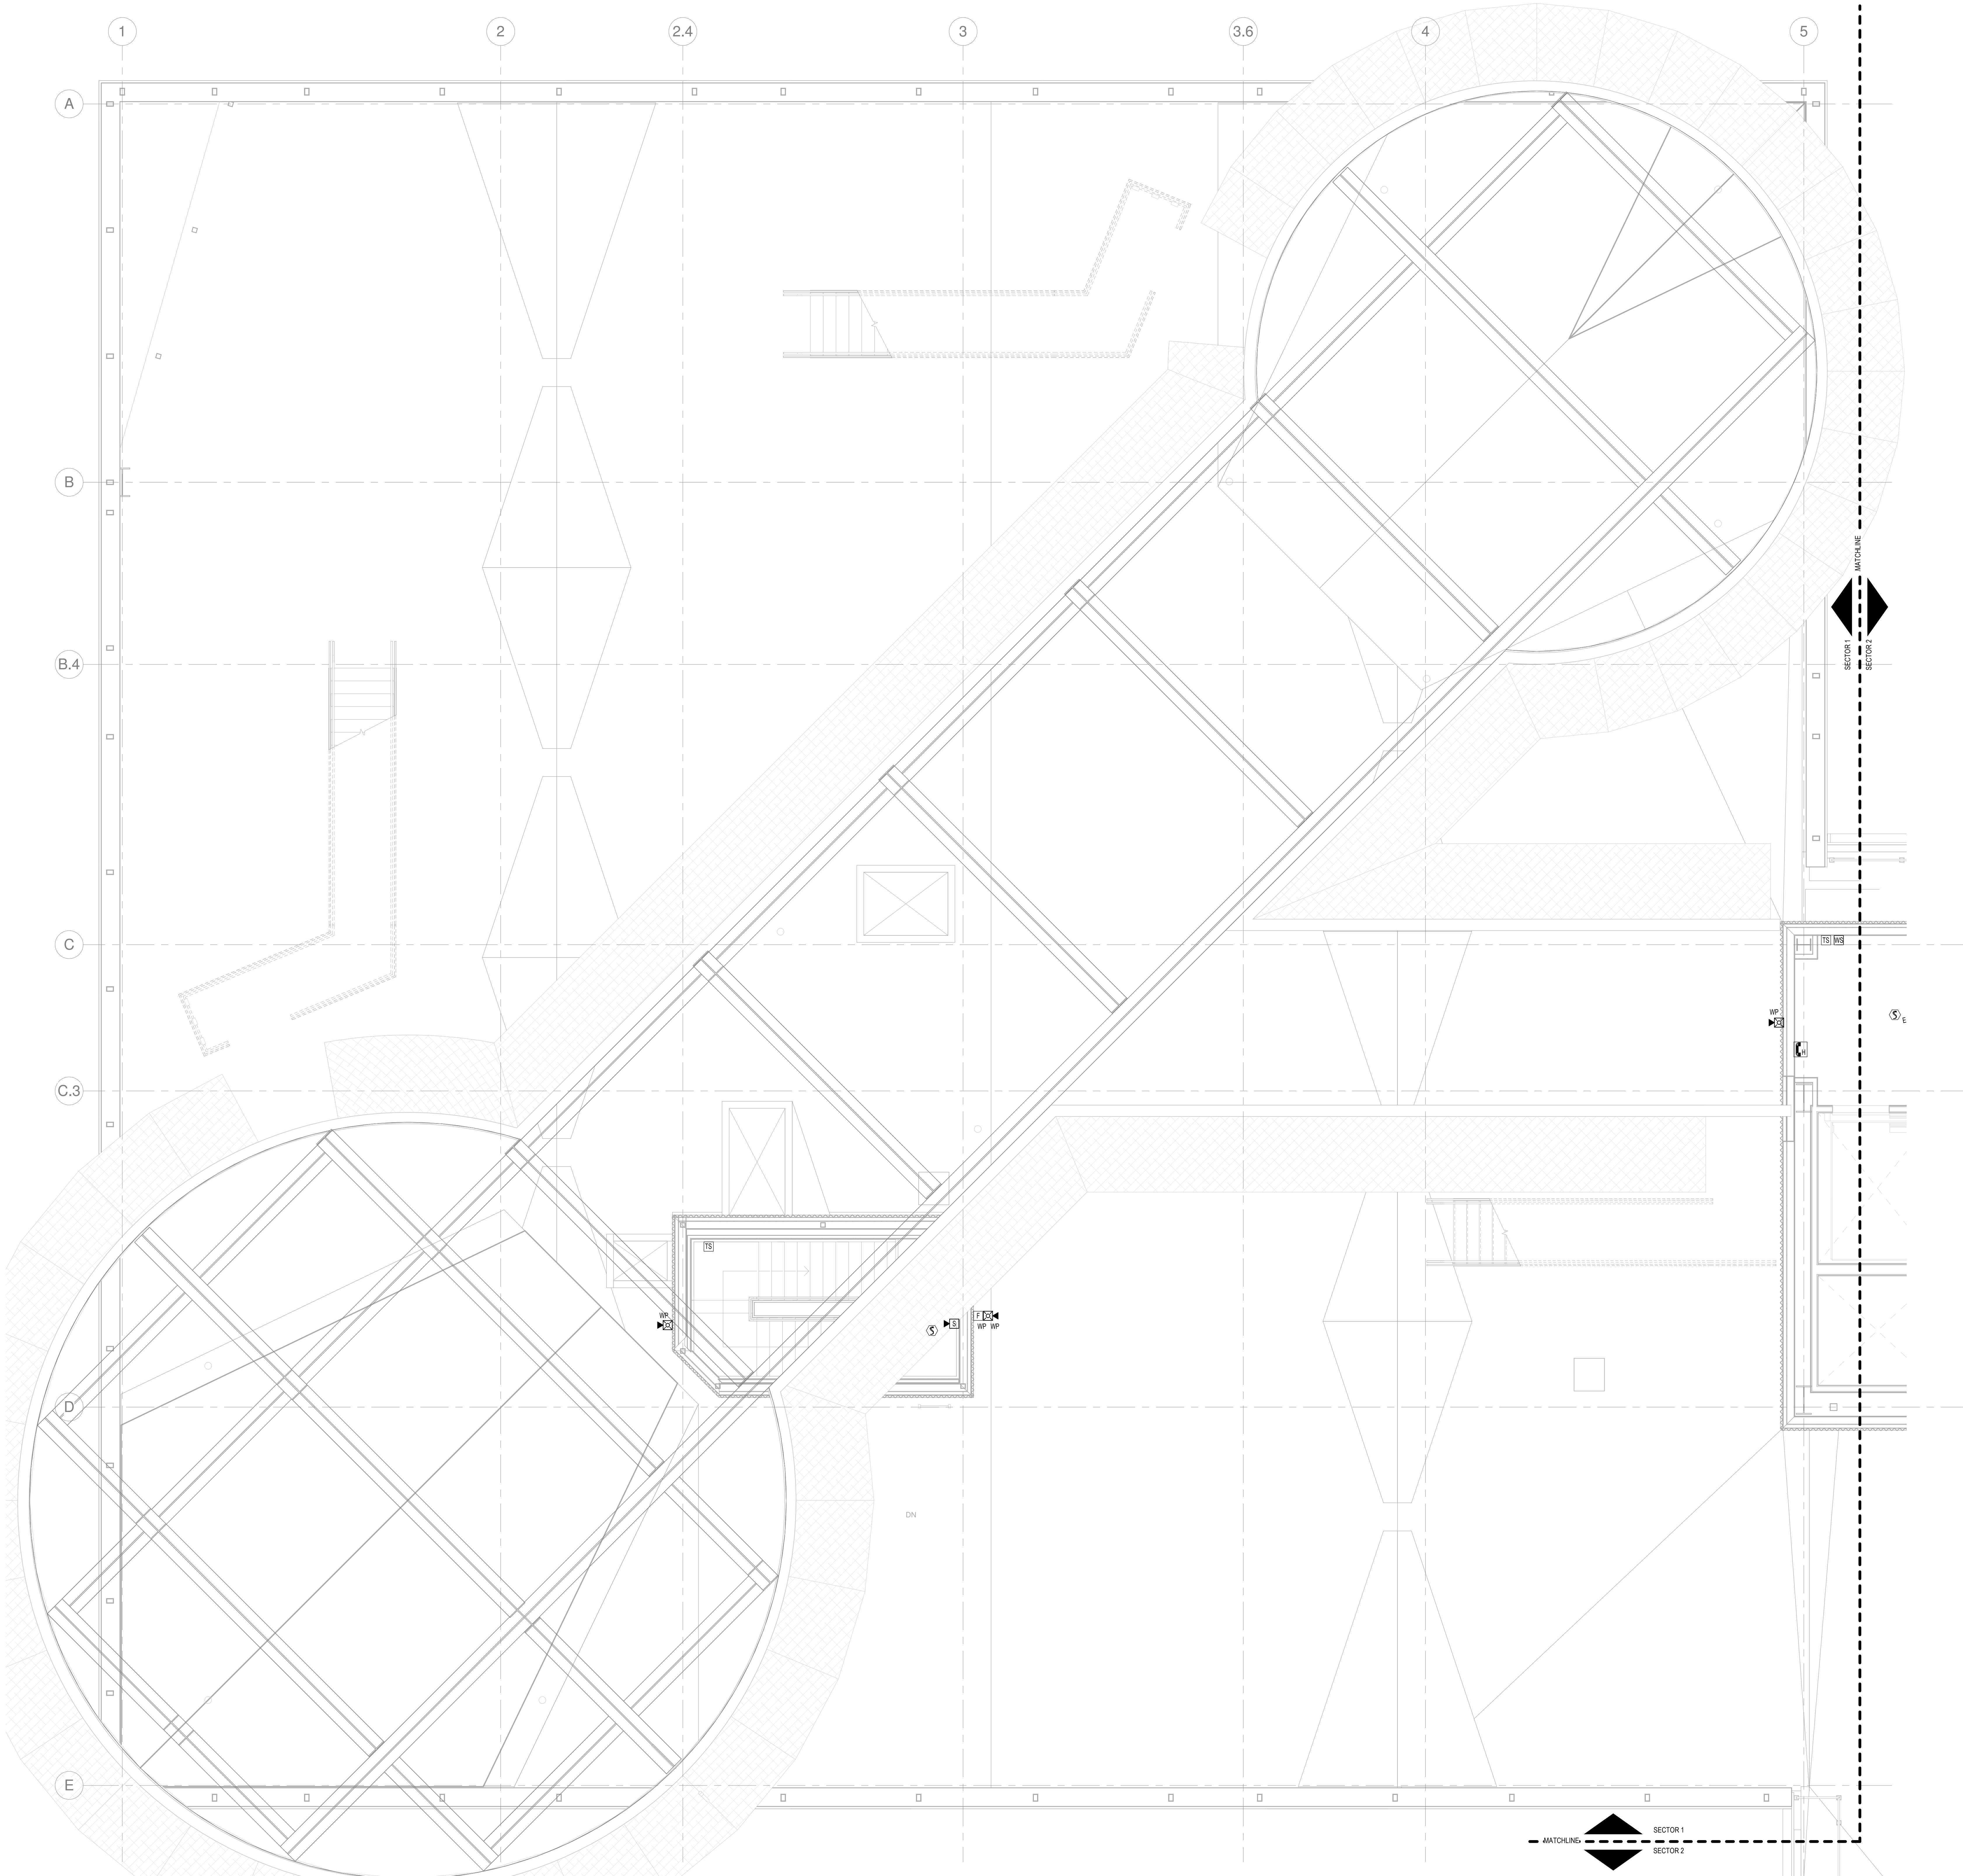

**1 ROOF - SECTOR 1**  
SCALE: 1/4" = 1'-0"

3/23/2018 11:21:25 AM  
C:\Revit Local Files\_\B150312-000\MDC East Tower 6&7 MEP17\_Constral\_construction.rvt