


NO	ISSUE	DATE
Job Number	B150312-000	
Drawn	MMS	
Checked	MFR	
Approved	MFR	

DRAWING NOTES - PENTHOUSE:
1. REFER TO DRAWING FA20-01 FOR FIRE ALARM SYMBOLS, NOTES AND SCHEDULES.
2. REFER TO DRAWING FA20-01 FOR FIRE ALARM RISER DIAGRAM.

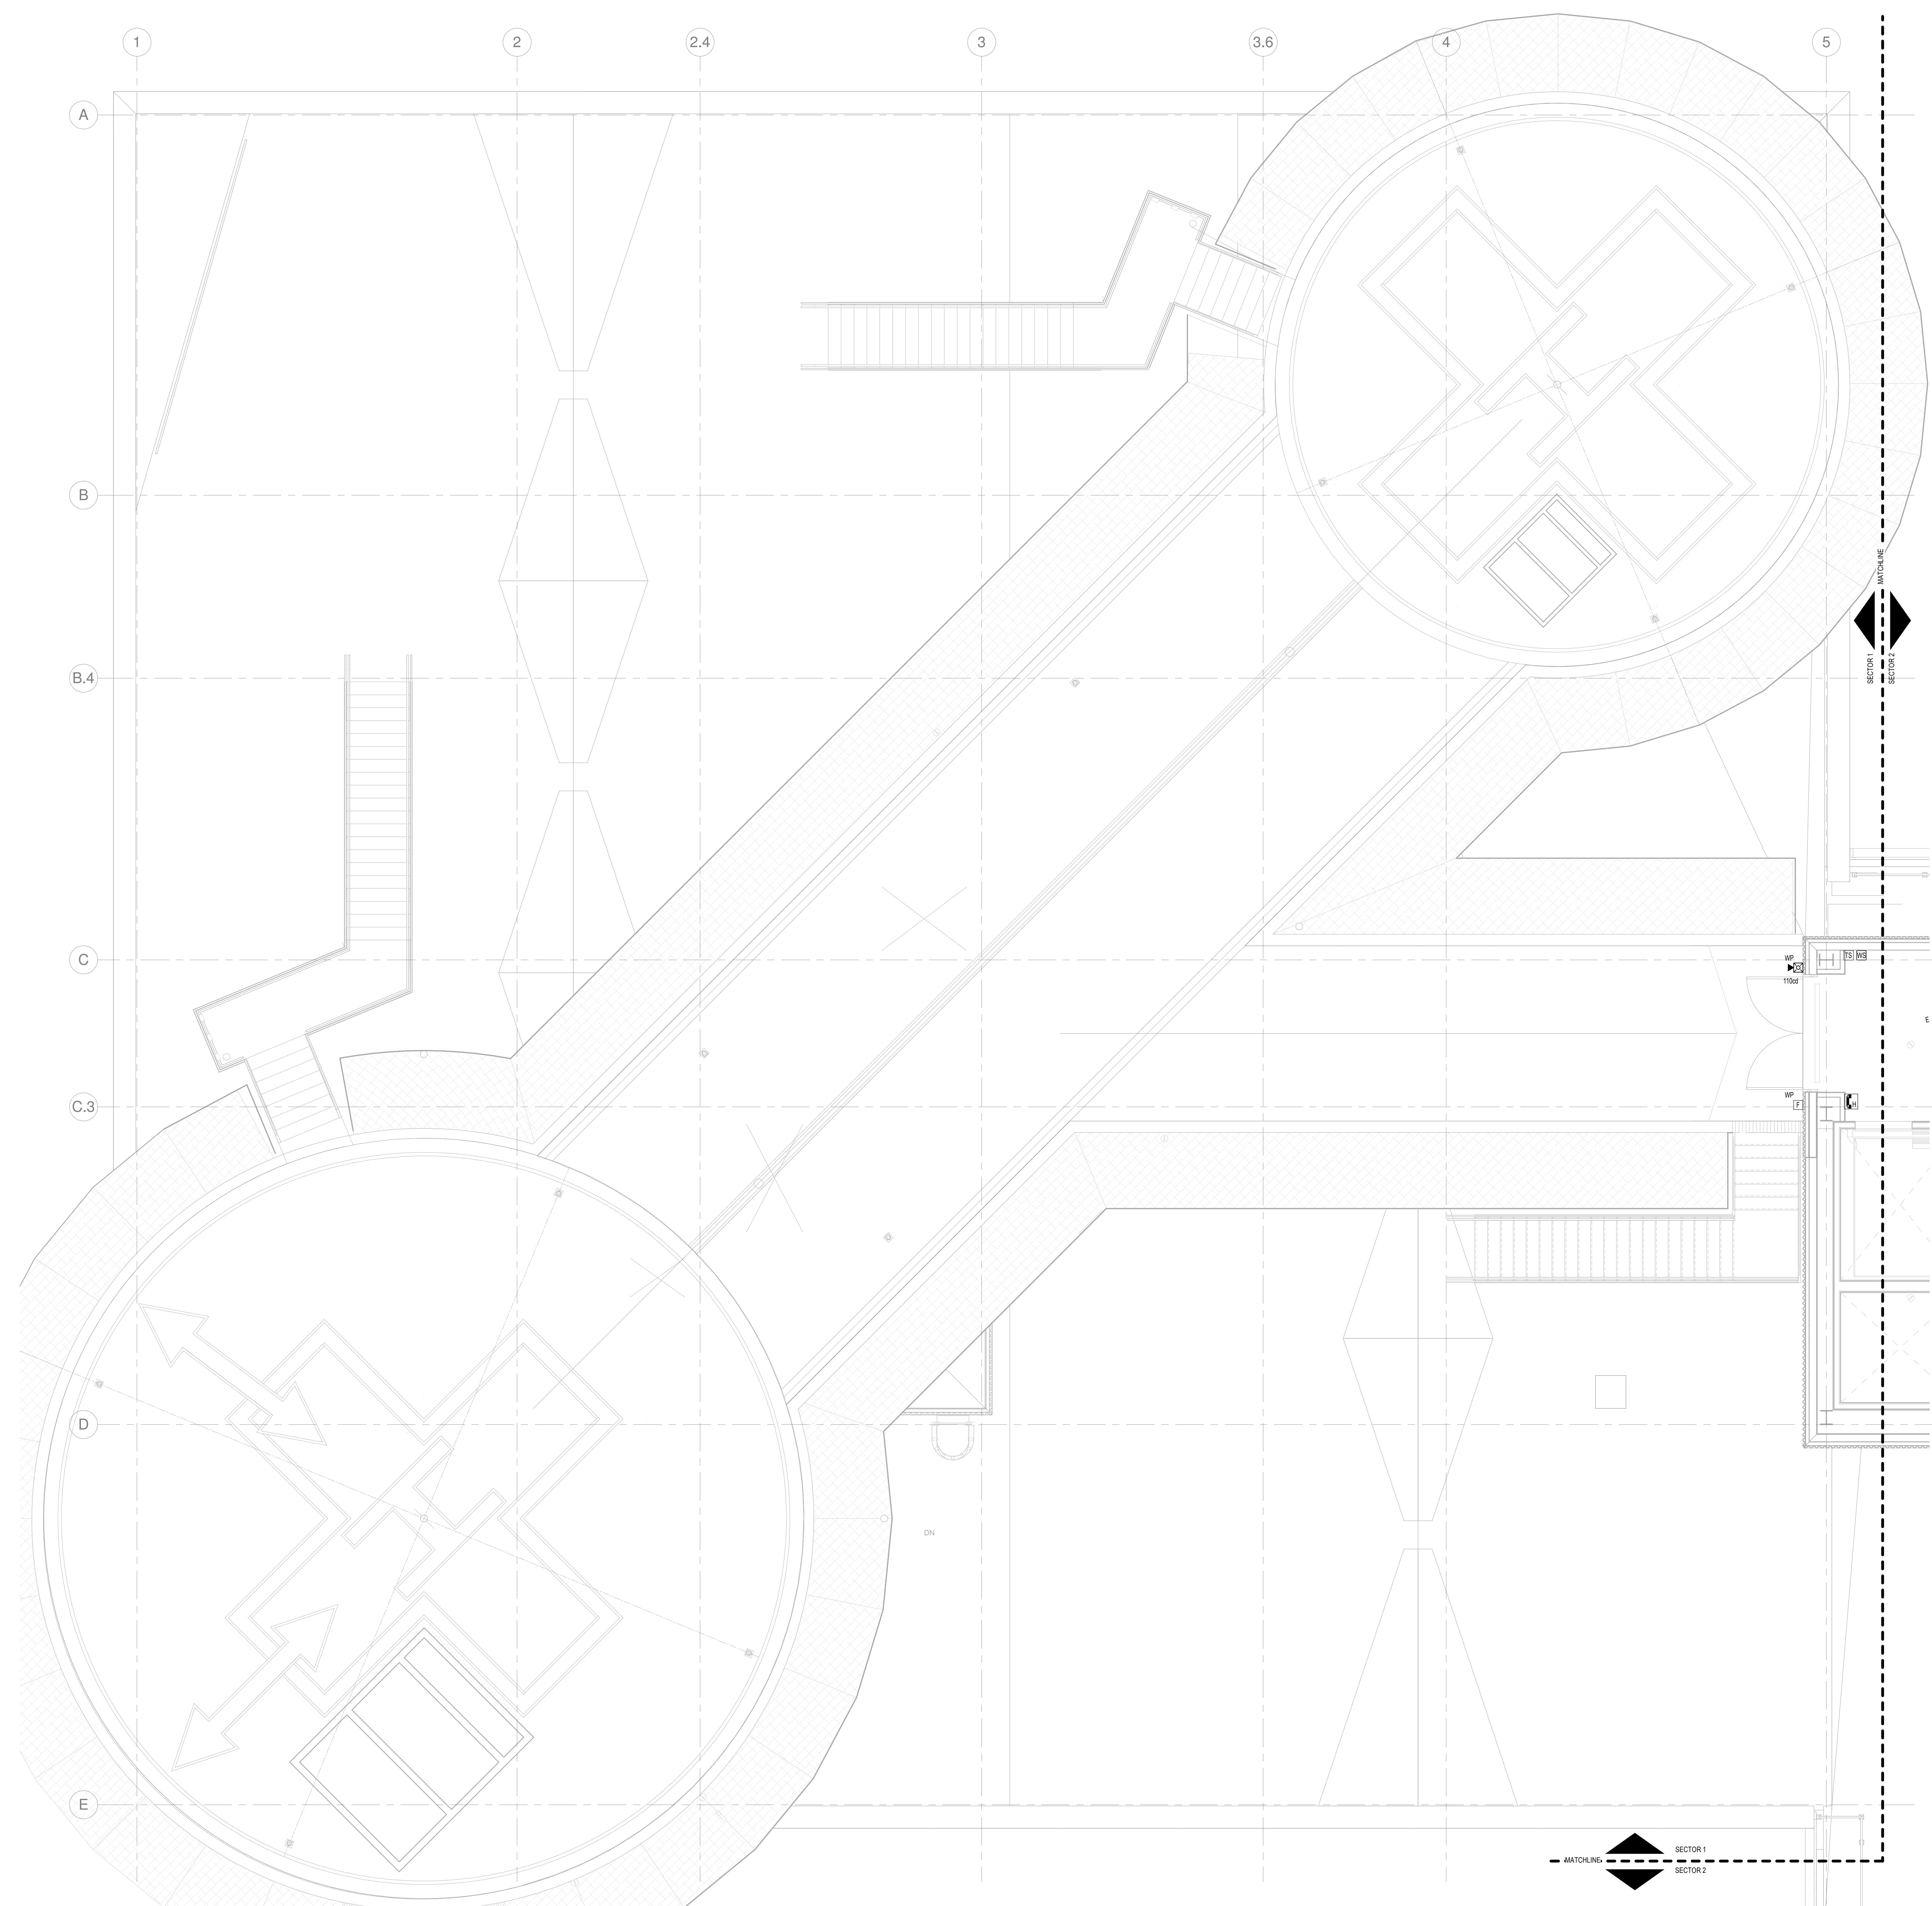

1 PENTHOUSE - SECTOR 1
SCALE: 1/4" = 1'-0"

3/23/2018 11:21:59 AM
C:\Revit Local Files_B150312\000\MDC East Tower 6&7 MEP17_Constr_documents.rvt