


1	ADDENDUM NO. 1	03/22/18
NO	ISSUE	DATE
Job Number	B150312-000	
Drawn	DCC	
Checked	PJR	
Approved	PJR	

TITLE
**PLUMBING LEVEL
7 FLOOR
DRAINAGE PLAN -
SECTOR 2**

SHEET NUMBER

P12-72

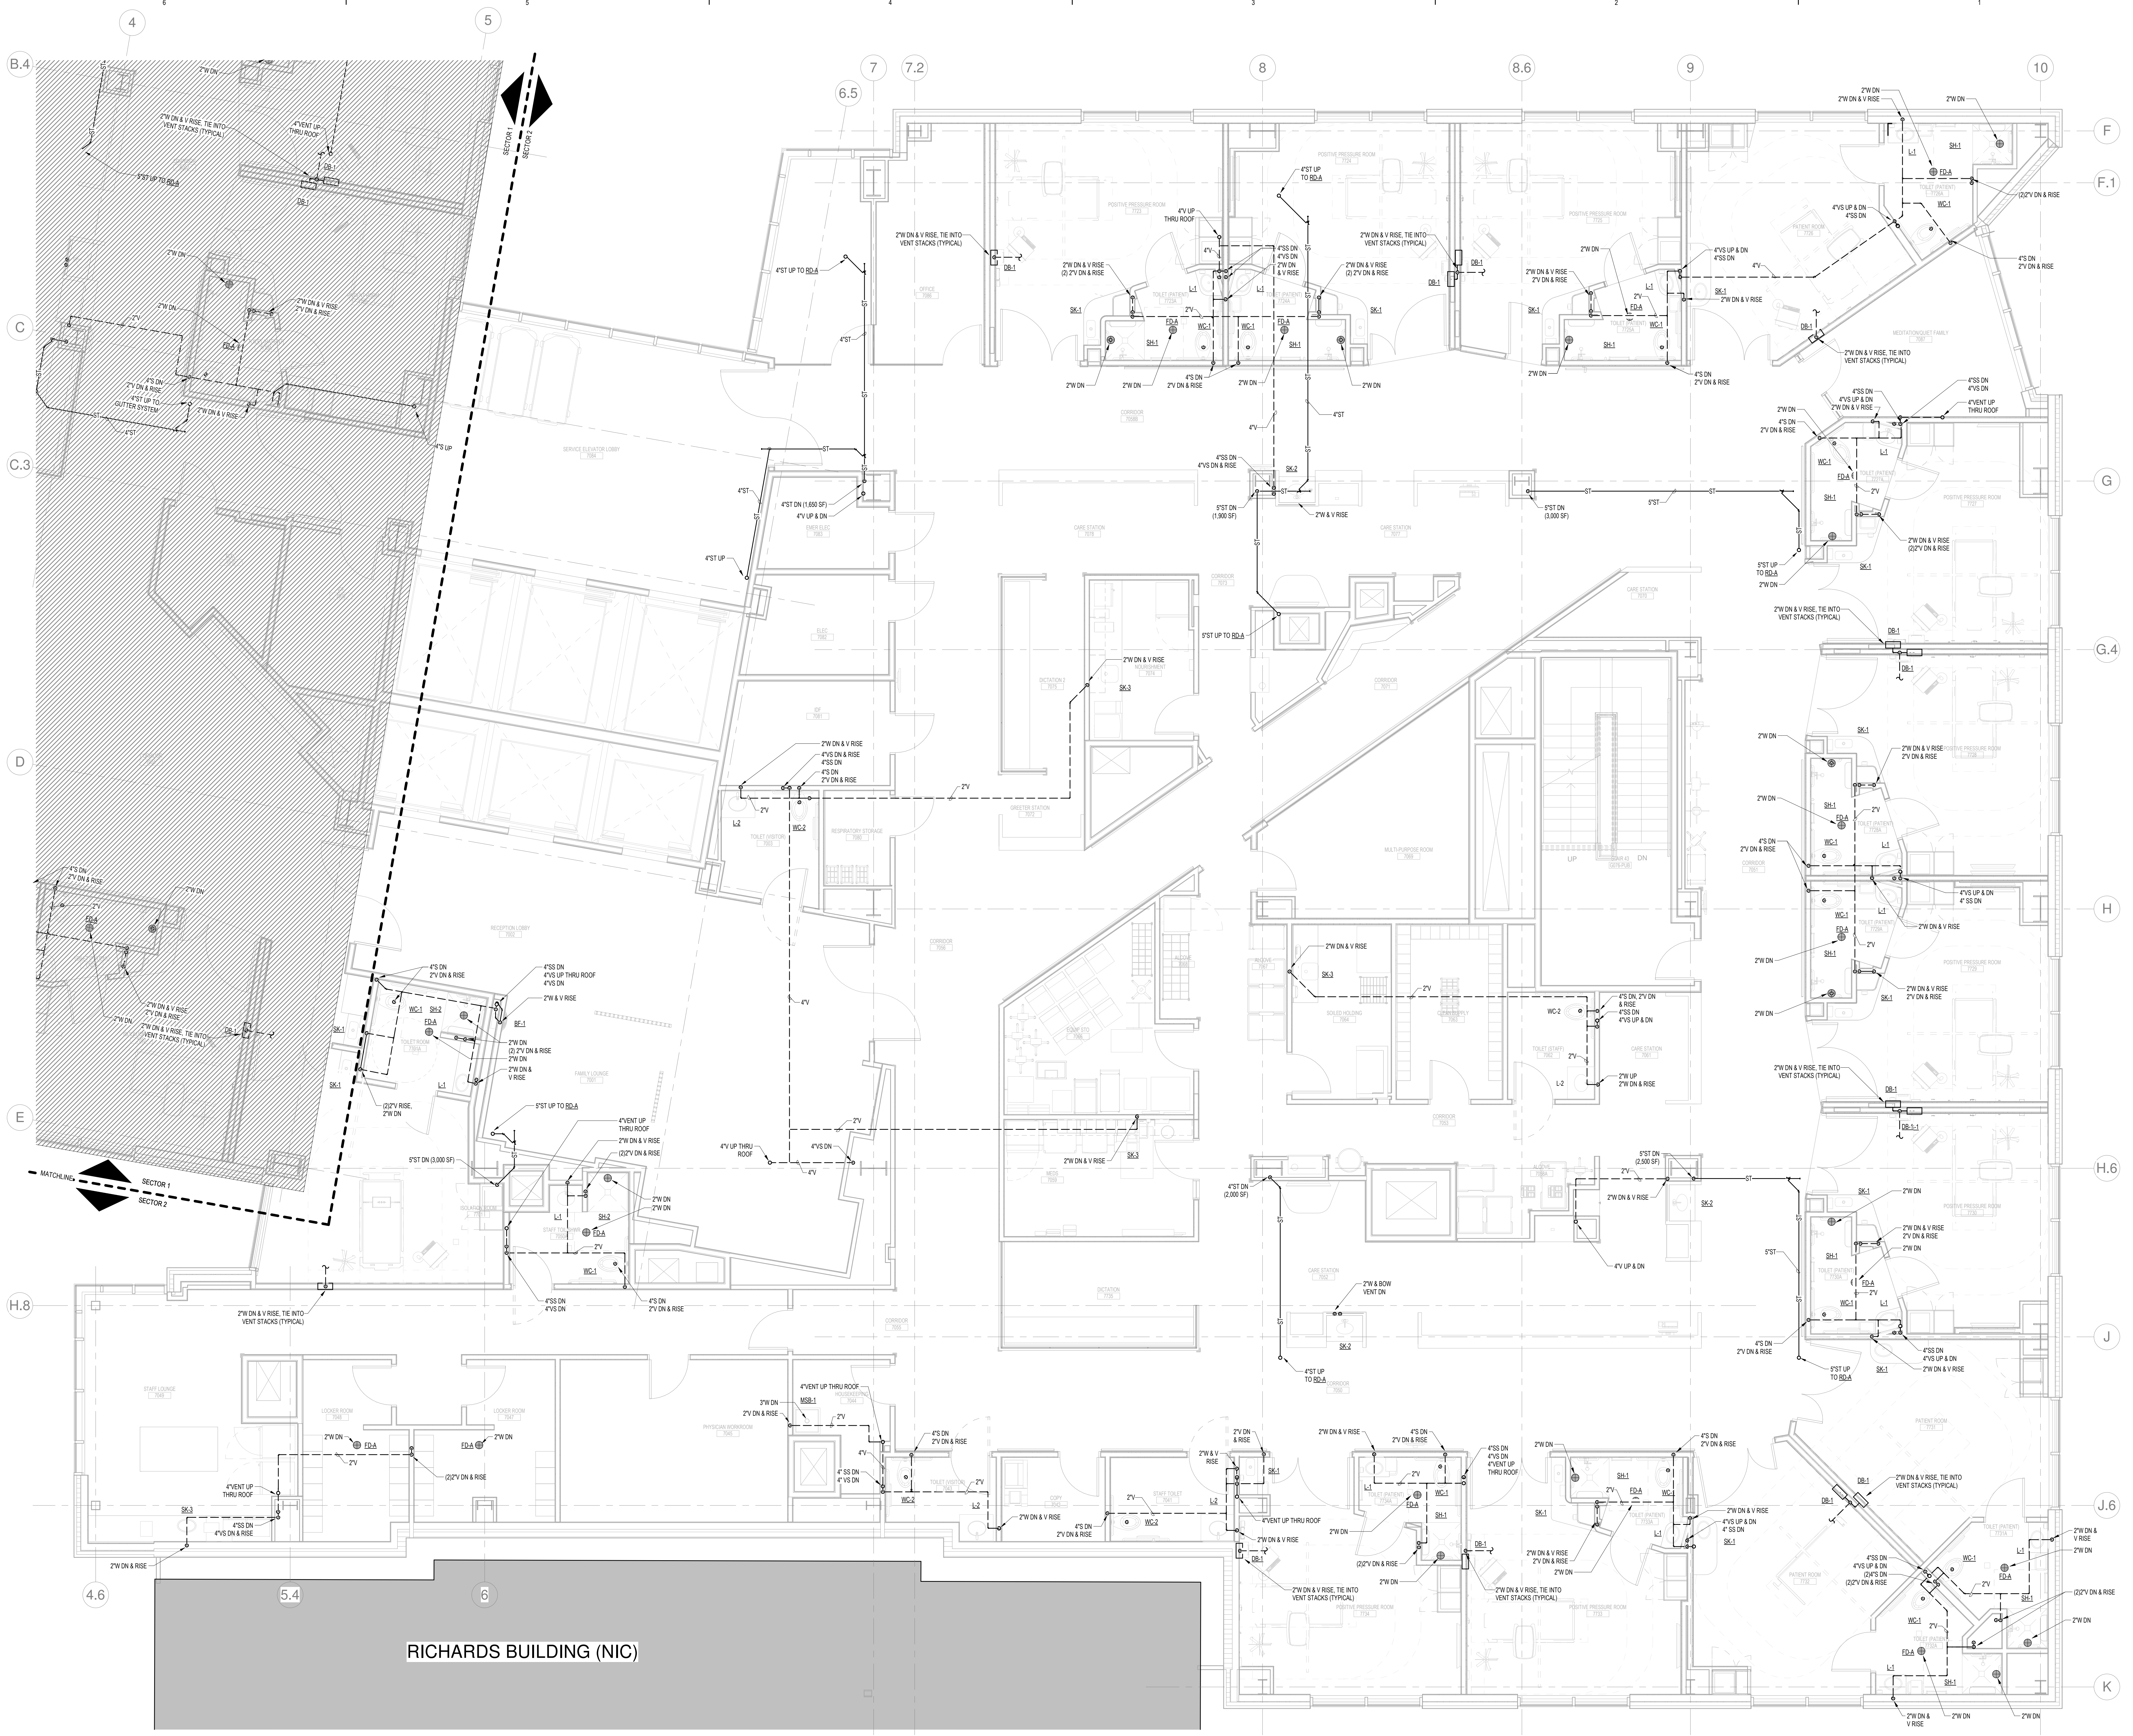

LEVEL 7 - SECTOR 2
SCALE: 1/4" = 1'-0"

RICHARDS BUILDING (NIC)

3/23/2018 11:44:48 AM C:\Revit Local Files_B150312\000\MDC East Tower 6&7 MEP17_Constr_documents.rvt