



- OVERALL KEY PLAN
- 1 - GILMAN GARAGE
 - 2 - CONGRESS STREET
 - 3 - VISITOR GARAGE
 - 4 - EAST TOWER
 - 5 - CENTRAL UTILITY PLANT
 - 6 - BEAN BUILDING
 - 7 - RICHARDS BUILDING
 - 8 - MAINE GENERAL BUILDING

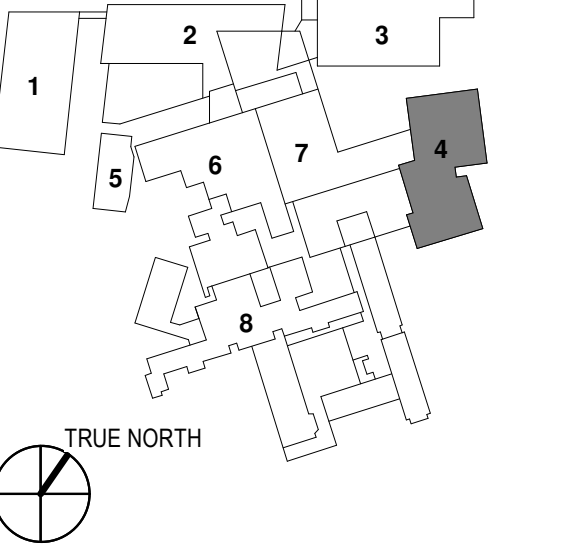

NO	ISSUE	DATE
1	ADDENDUM NO. 1	03/22/18

Job Number: B150312-000
Drawn: Author
Checked: Checker
Approved: Approver

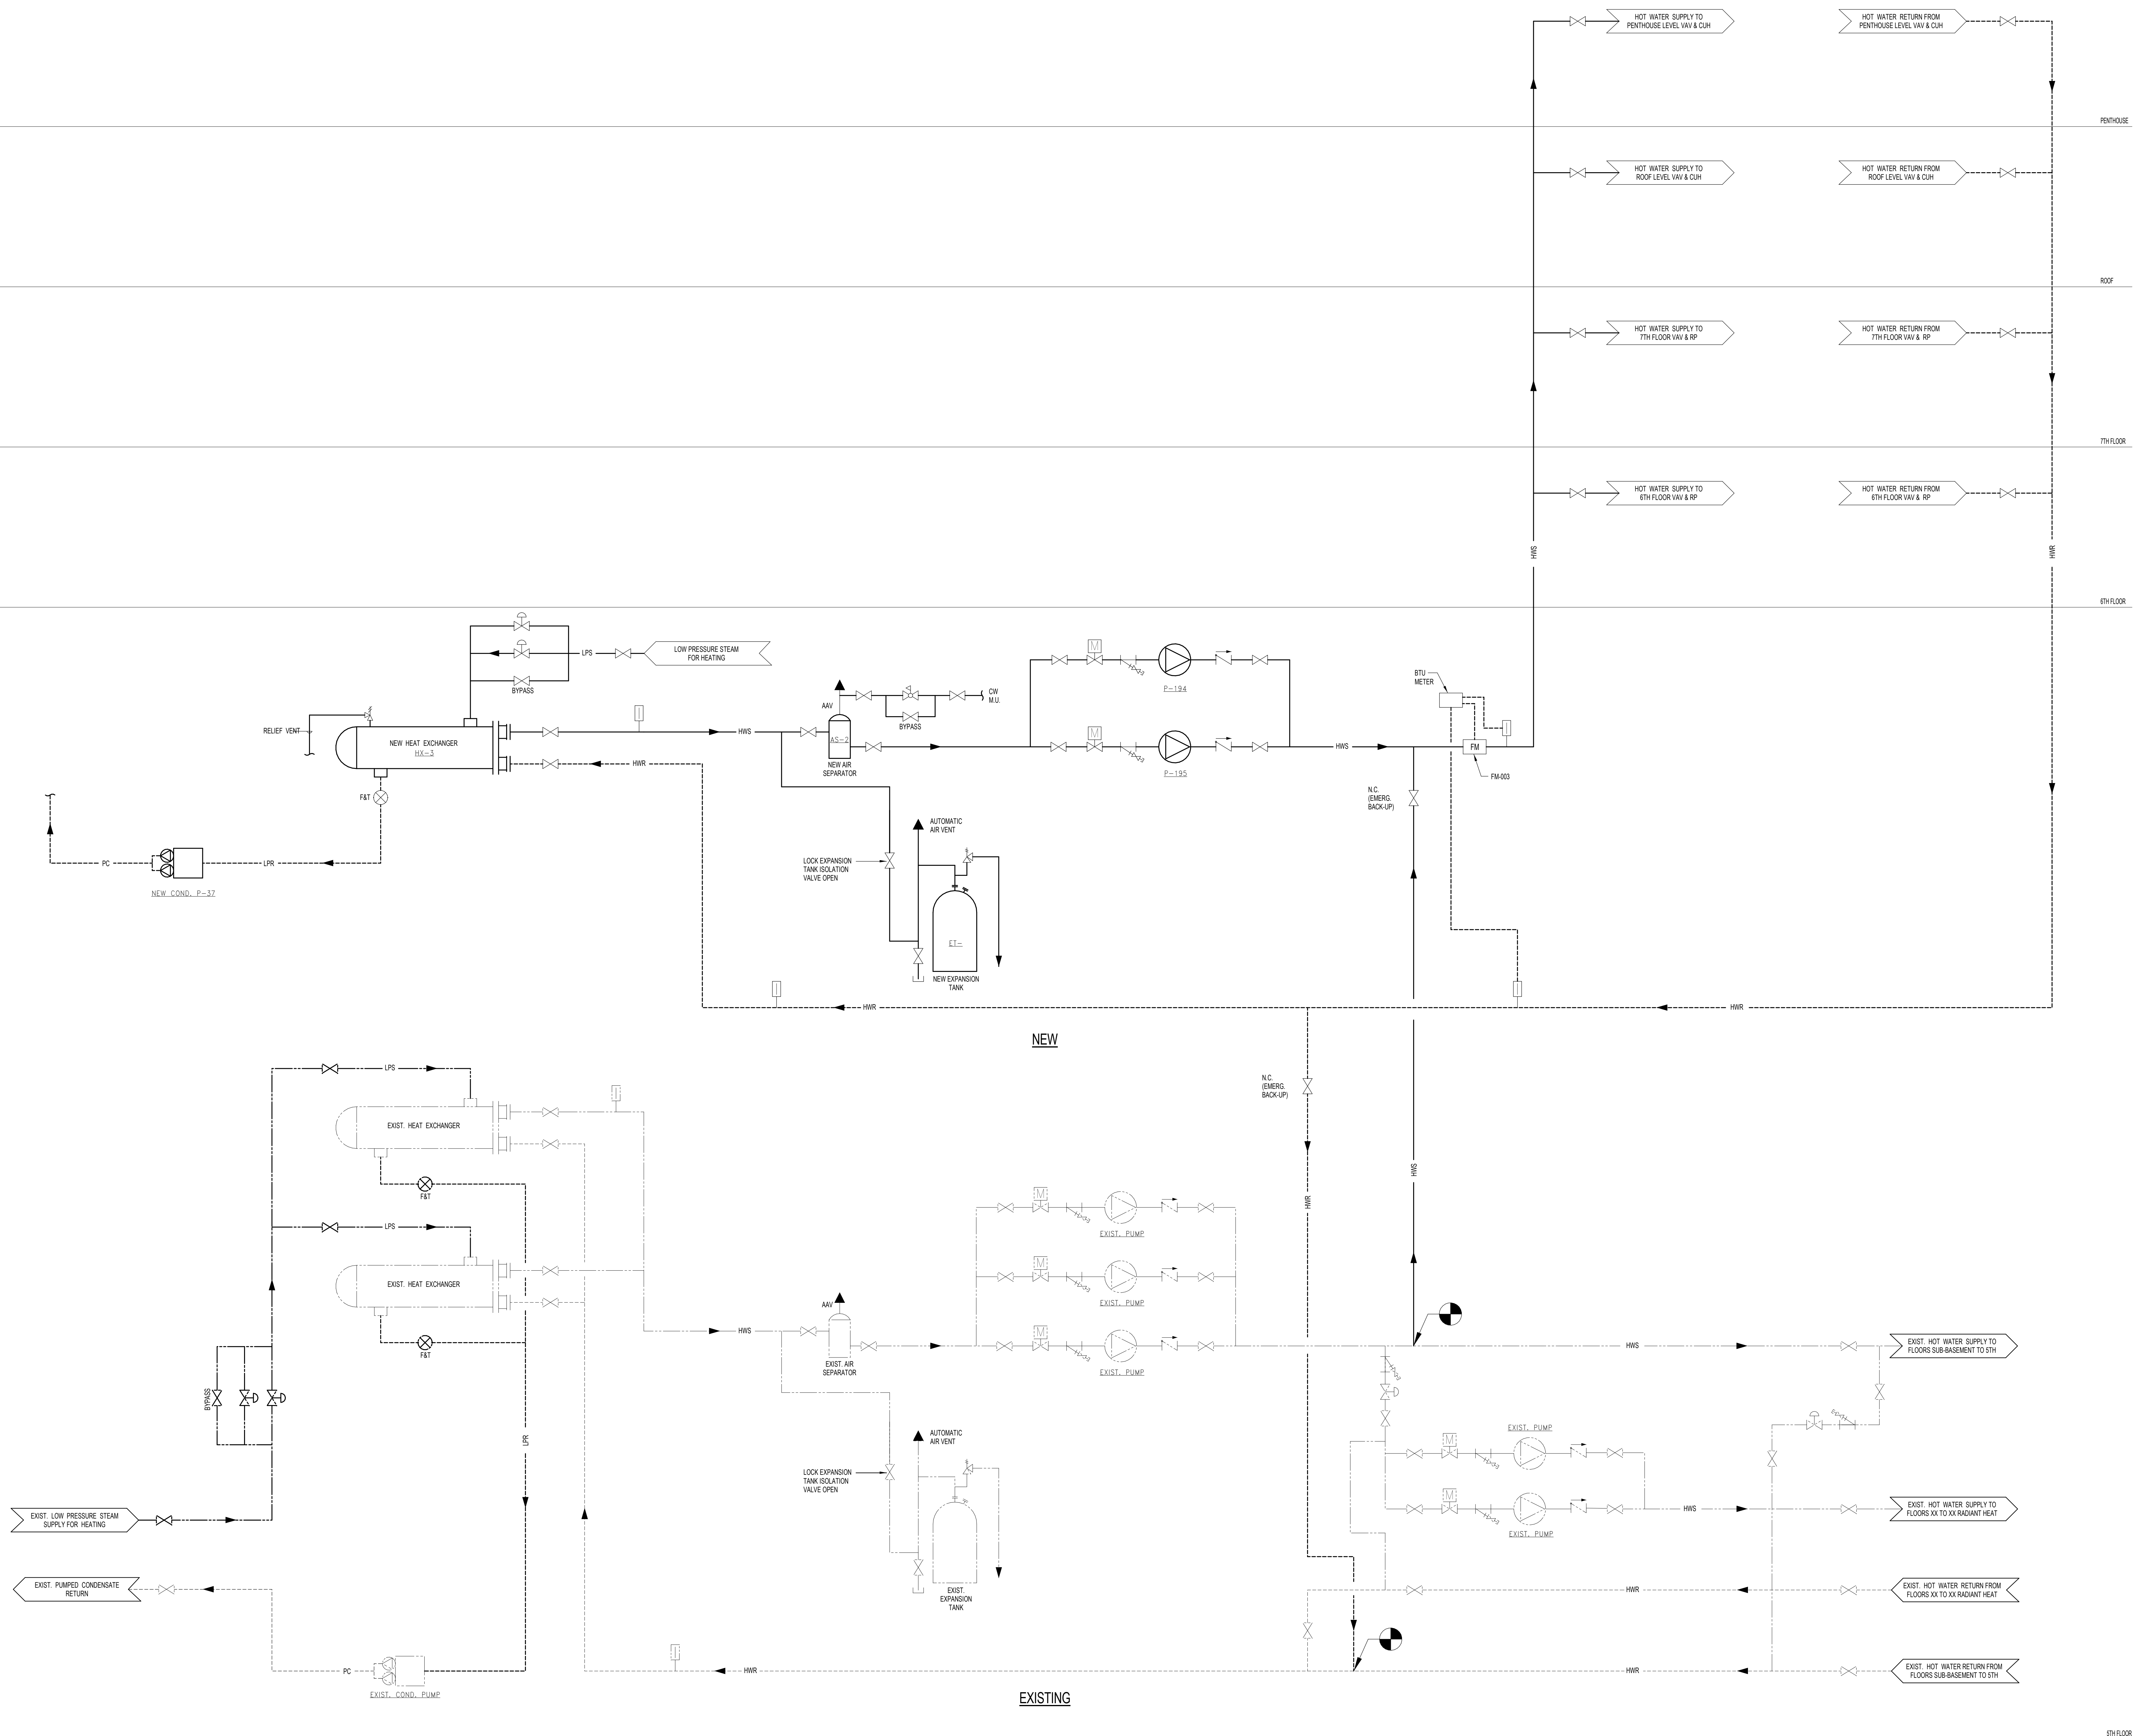

1 HOT WATER FLOW DIAGRAM
SCALE: NTS

3/28/2018 11:23:56 AM C:\Revit Local Files_B150312\000\MDC East Tower 6&7 MEP17_Constral_construction.rvt