


CONSULTANTS


- CIVIL/LANDSCAPE ARCHITECT**
 Sebago Technics
 75 John Roberts Road, Suite
 1A, South Portland, ME 04106
- STRUCTURAL/ENR/BUILDING ENVELOPE CONSULTANT**
 Stinson Gumpert & Hooper Inc.
 41 Sevon Street, Building 1, Suite 470
 Waltham, MA 02453
- MERFP/ENGINEER/CCC**
 AKF Group LLC
 99 Bedford Street, 2nd Floor, Boston MA 02111
- CONSTRUCTION MANAGER**
 Turner Construction
 2 Seaport Lane, Suite 200, Boston, MA 02210
- ELEVATOR CONSULTANT**
 VDA (Van Dusen & Associates)
 101 Summer Street, 4th Floor, Boston MA
 02110
- COST ESTIMATOR**
 D. G. Jones International
 3 Baitwin Green Common, Suite 202, Westbrook, MA 01801

PROJECT TITLE

East Tower 6 & 7
Addition
 22 Bramhall Street
 Portland, ME 04102

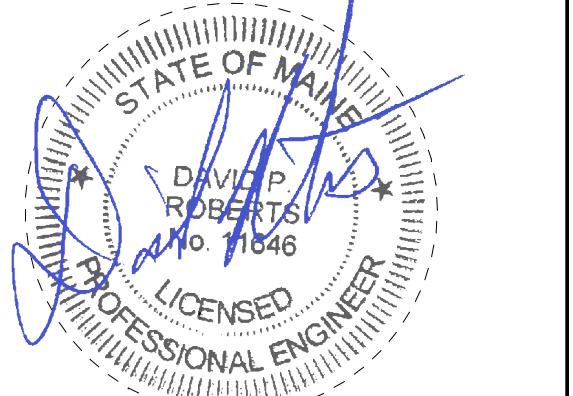

KEY PLANS

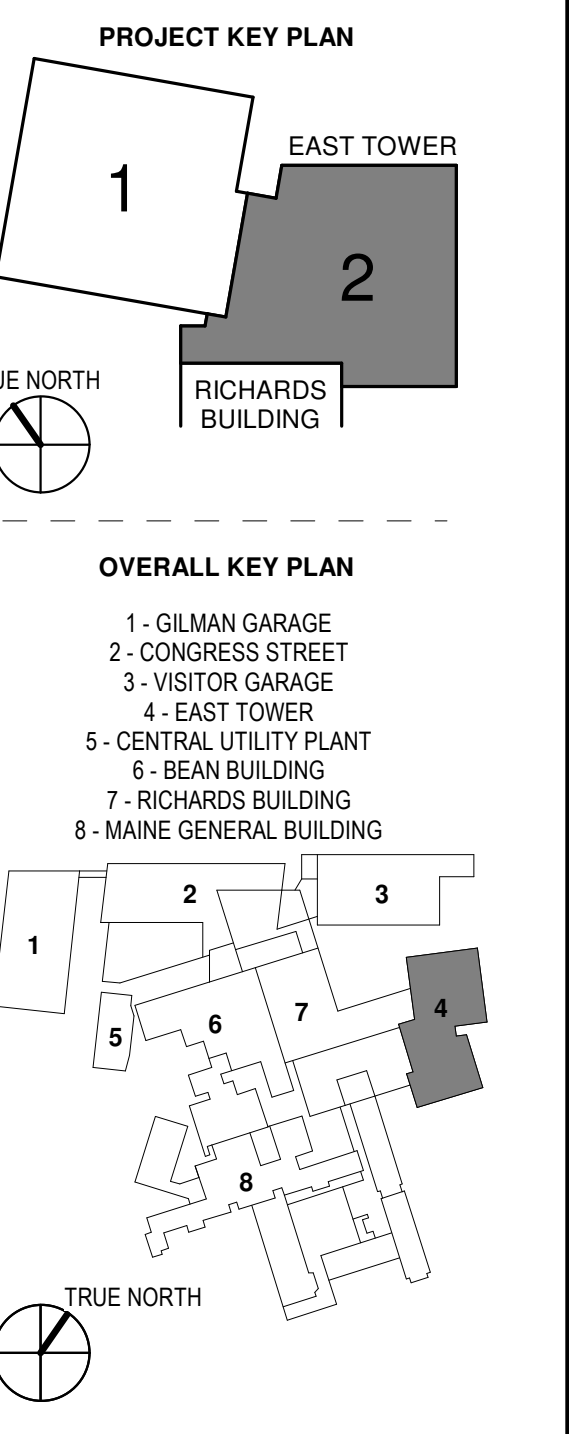


CONSTRUCTION DOCUMENTS
 JANUARY 28, 2018

NO	ISSUE	DATE
1	ADDENDUM NO. 1	03/22/18
Job Number: B150312-000		
Drawn	TU	
Checked	DFR	
Approved	DFR	

TITLE
MECHANICAL
FIFTH FLOOR
DUCTWORK PLAN -
SECTOR 2
 SHEET NUMBER

M11-52

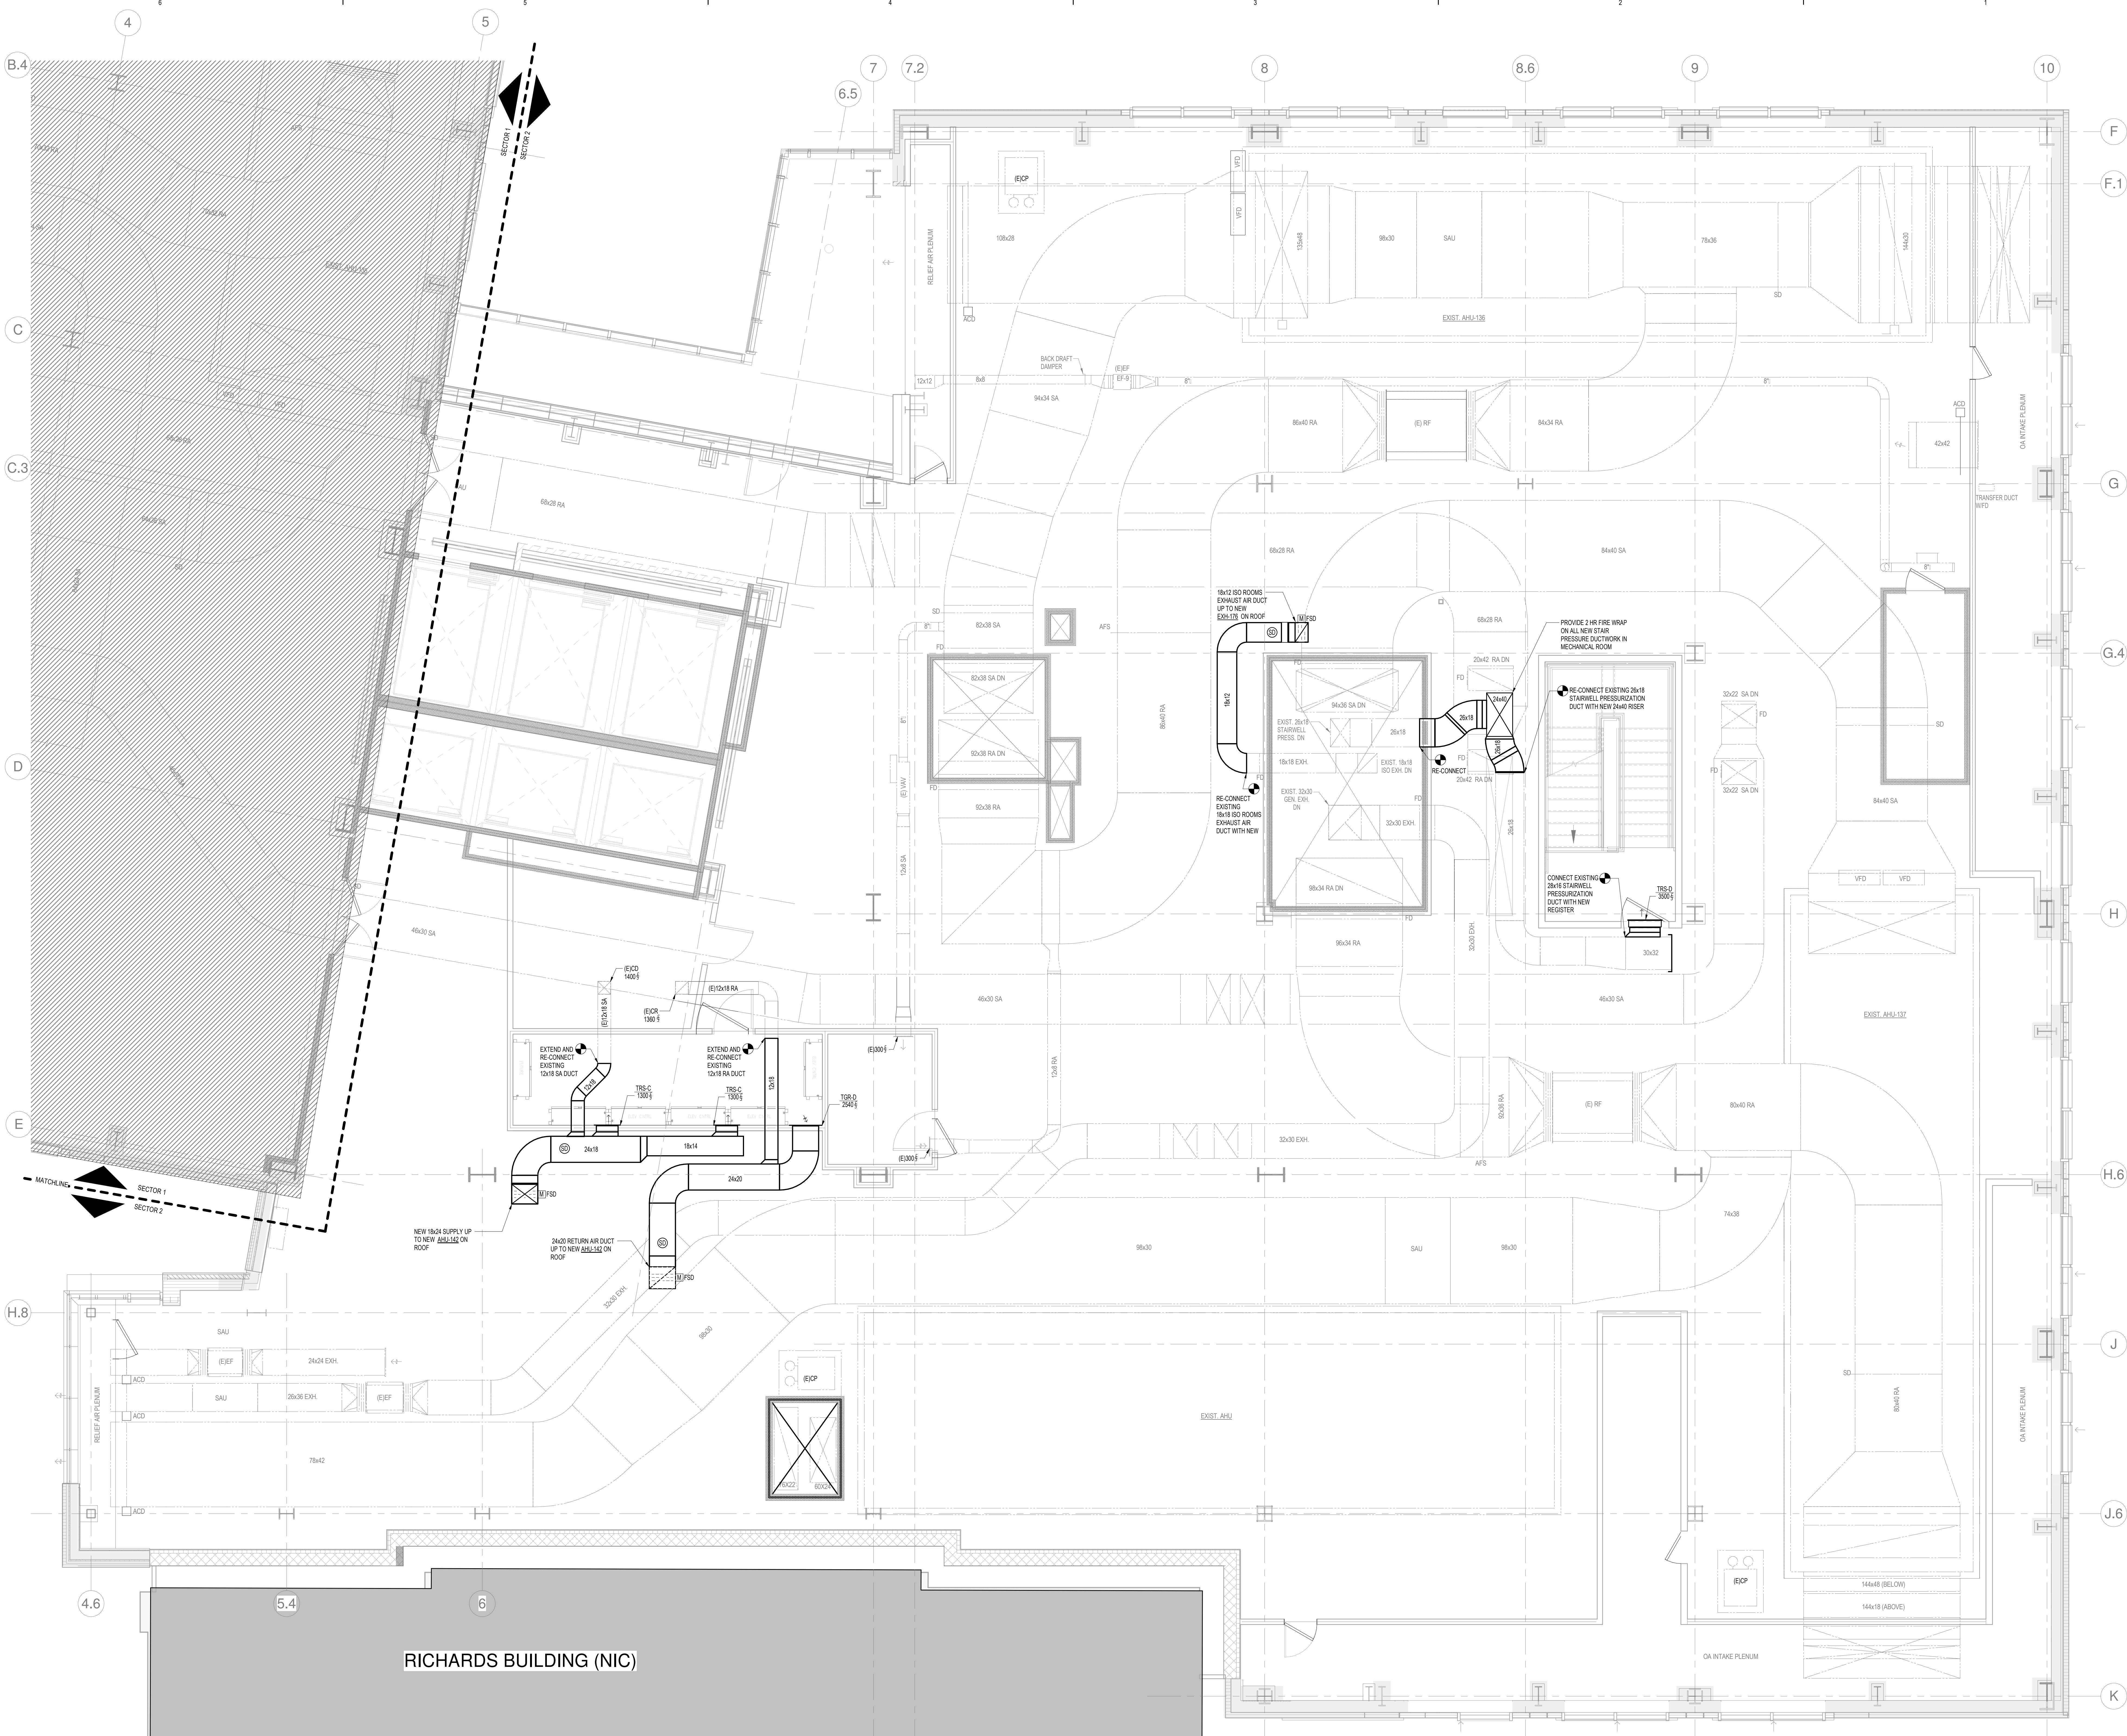

LEVEL 5 - SECTOR 2
 SCALE: 1/8" = 1'-0"