

CONSTRUCTION DOCUMENTS  
 JANUARY 28, 2018

ADDENDUM NO.	DATE
1	03/22/18

NO. ISSUE DATE

Job Number B150312-000  
 Drawn TLU  
 Checked DPR  
 Approved DPR


TITLE  
**MECHANICAL  
 SIXTH FLOOR  
 DUCTWORK PLAN -  
 SECTOR 1**

SHEET NUMBER  
**M11-61**

- DRAWING KEY NOTES
- PROVIDE GPM DIFFERENTIAL PRESSURE MONITOR ABOVE DOOR.
  - PROVIDE 'WALL IN WALL' VISUAL PRESSURE MONITOR ABOVE DOOR.

SUPPLY AIR TERMINAL BOXES

BOX #	1	2	3	4	5	6	7	8	9	10
GPM MAX	275	330	425	450	775	1025	785	425	425	595
GPM MIN	265	325	420	450	770	1020	780	420	420	590
SIZE	18" X 18"	18" X 18"	18" X 18"	18" X 18"	18" X 18"	18" X 18"	18" X 18"	18" X 18"	18" X 18"	18" X 18"

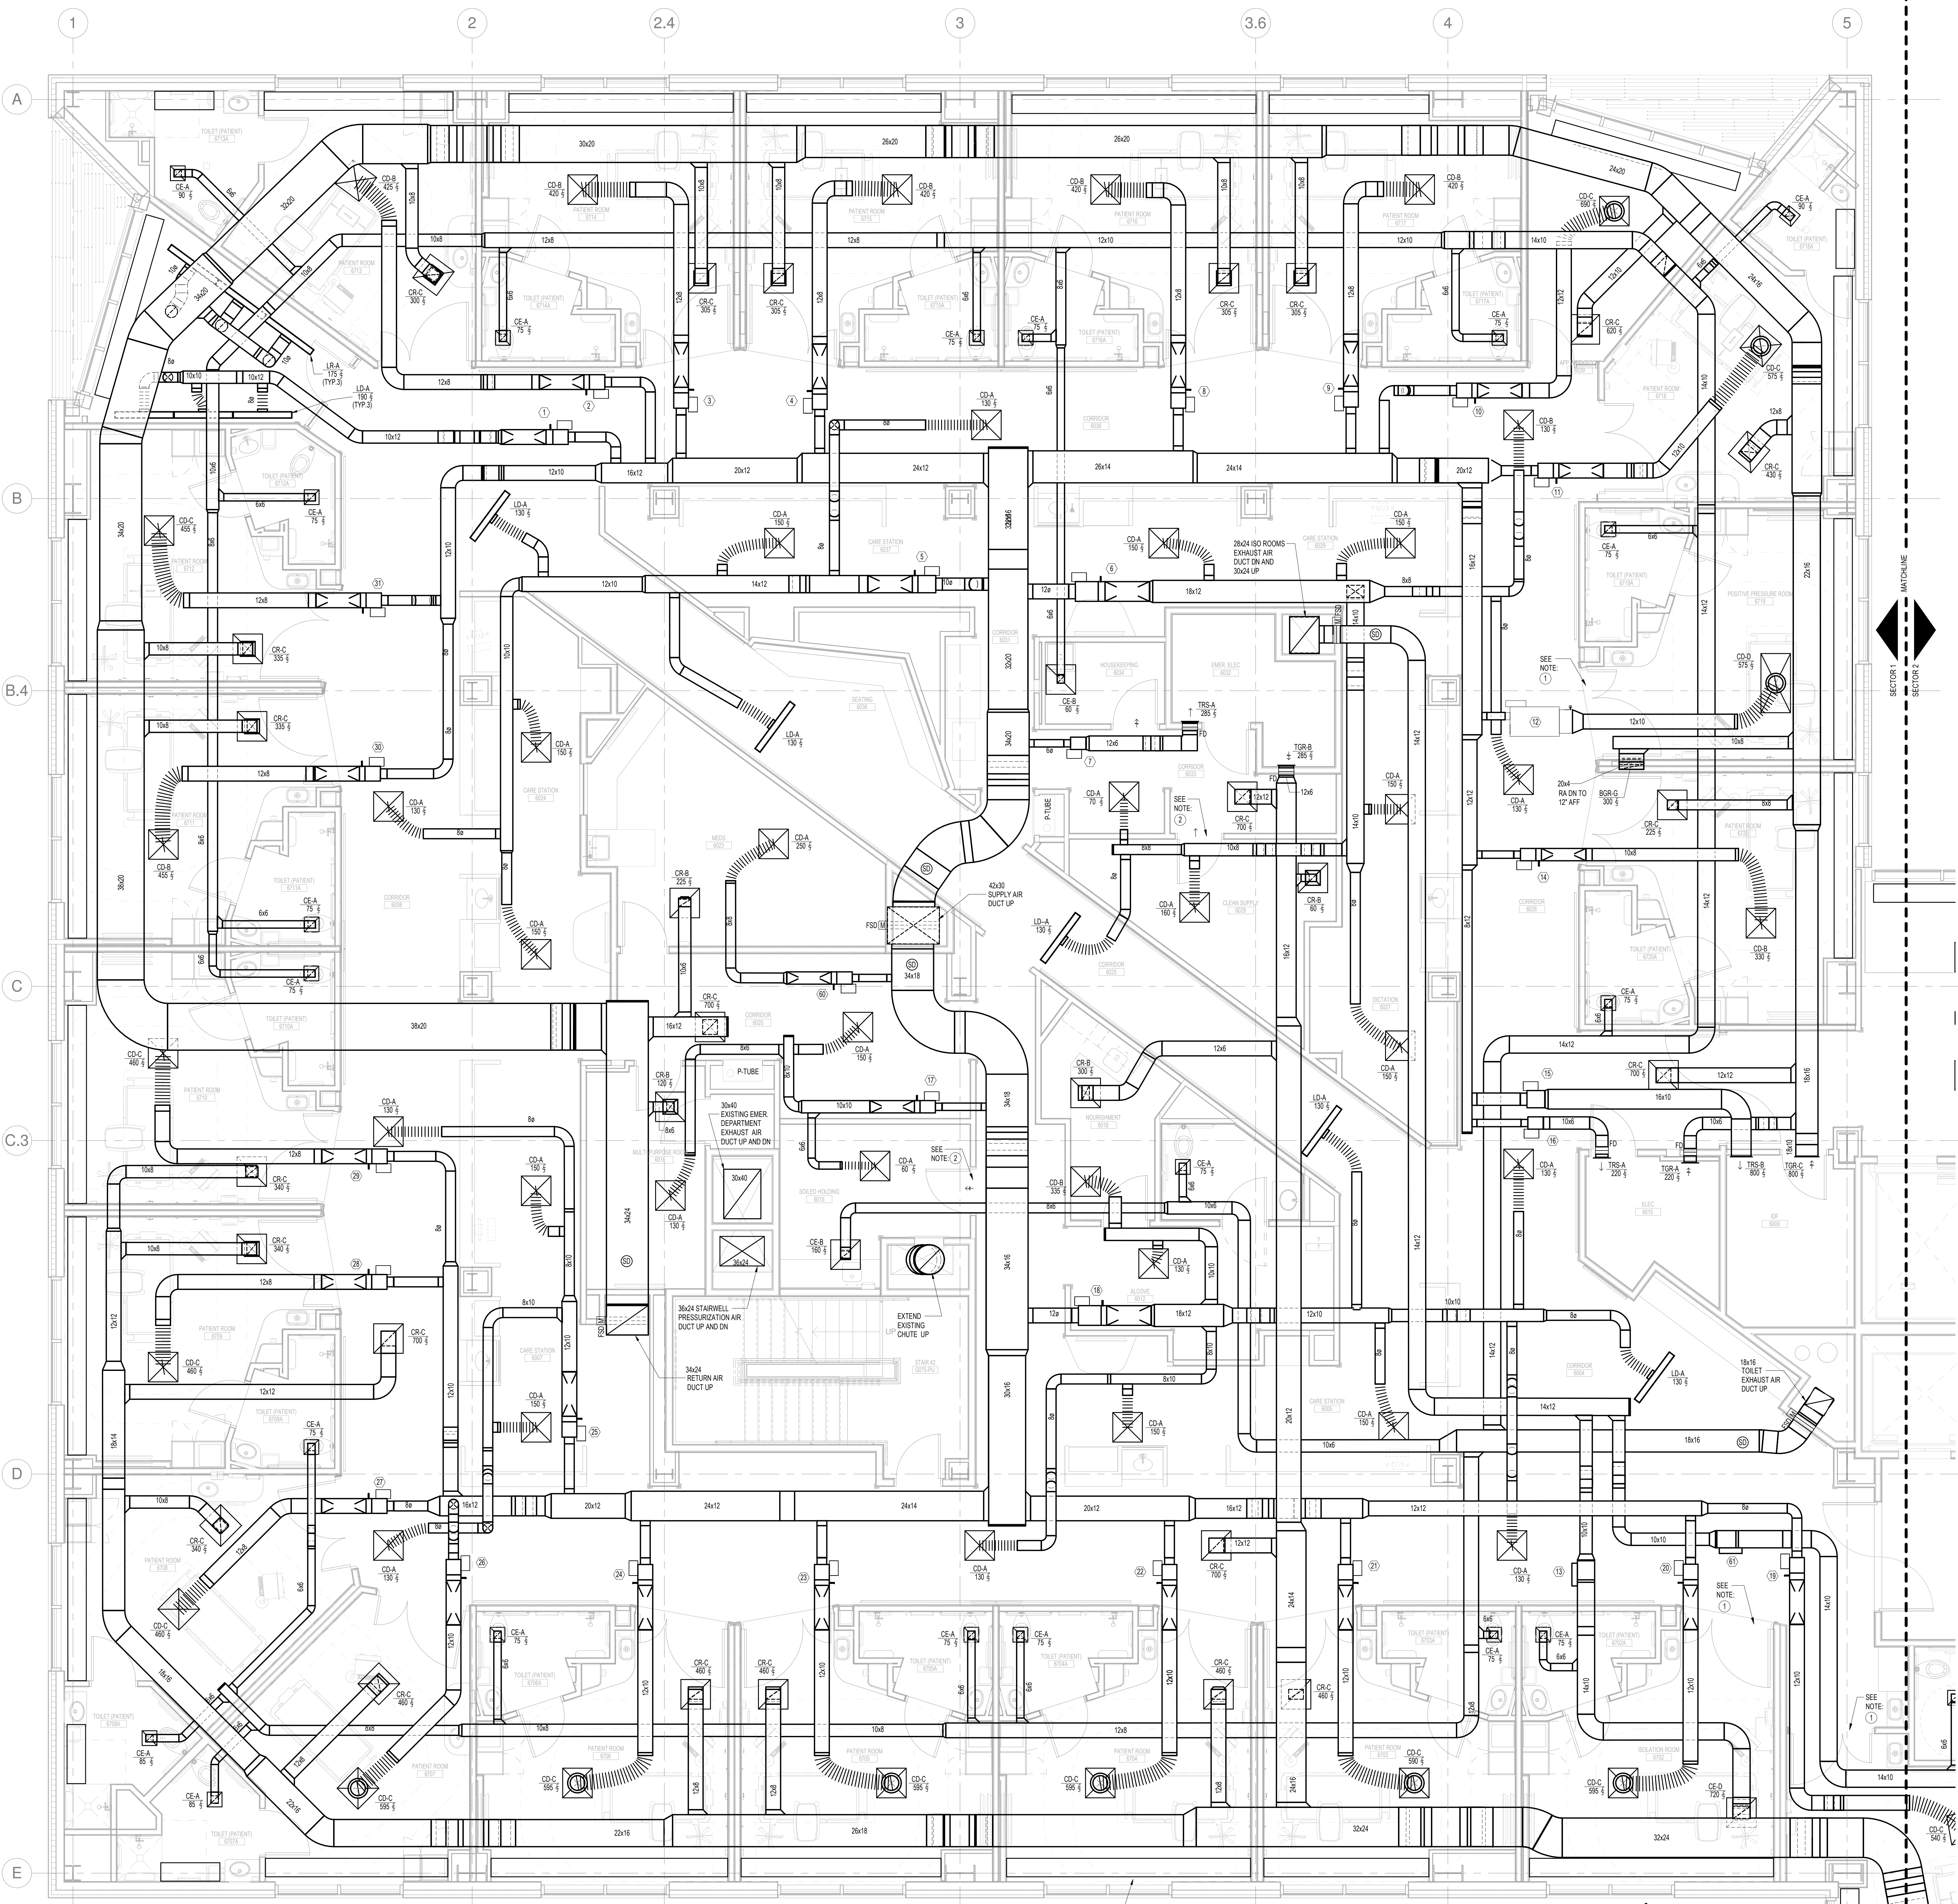

1 LEVEL 6 - SECTOR 1  
 SCALE: 1/4" = 1'-0"

