



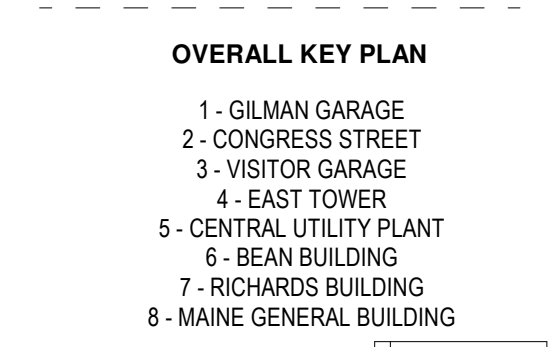

KEY PLANS

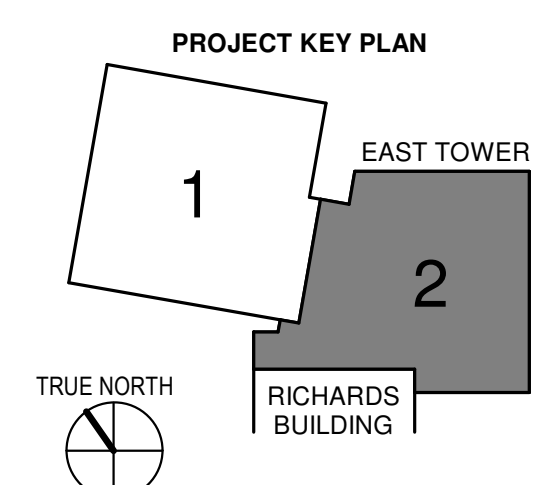


CONSTRUCTION DOCUMENTS
 JANUARY 28, 2018

ADDENDUM NO.	DATE
1	03/22/18
NO	ISSUE
Job Number	B150312-000
Drawn	TU
Checked	DFR
Approved	DFR

TITLE
**MECHANICAL
 SIXTH FLOOR
 DUCTWORK PLAN -
 SECTOR 2**

SHEET NUMBER

M11-62

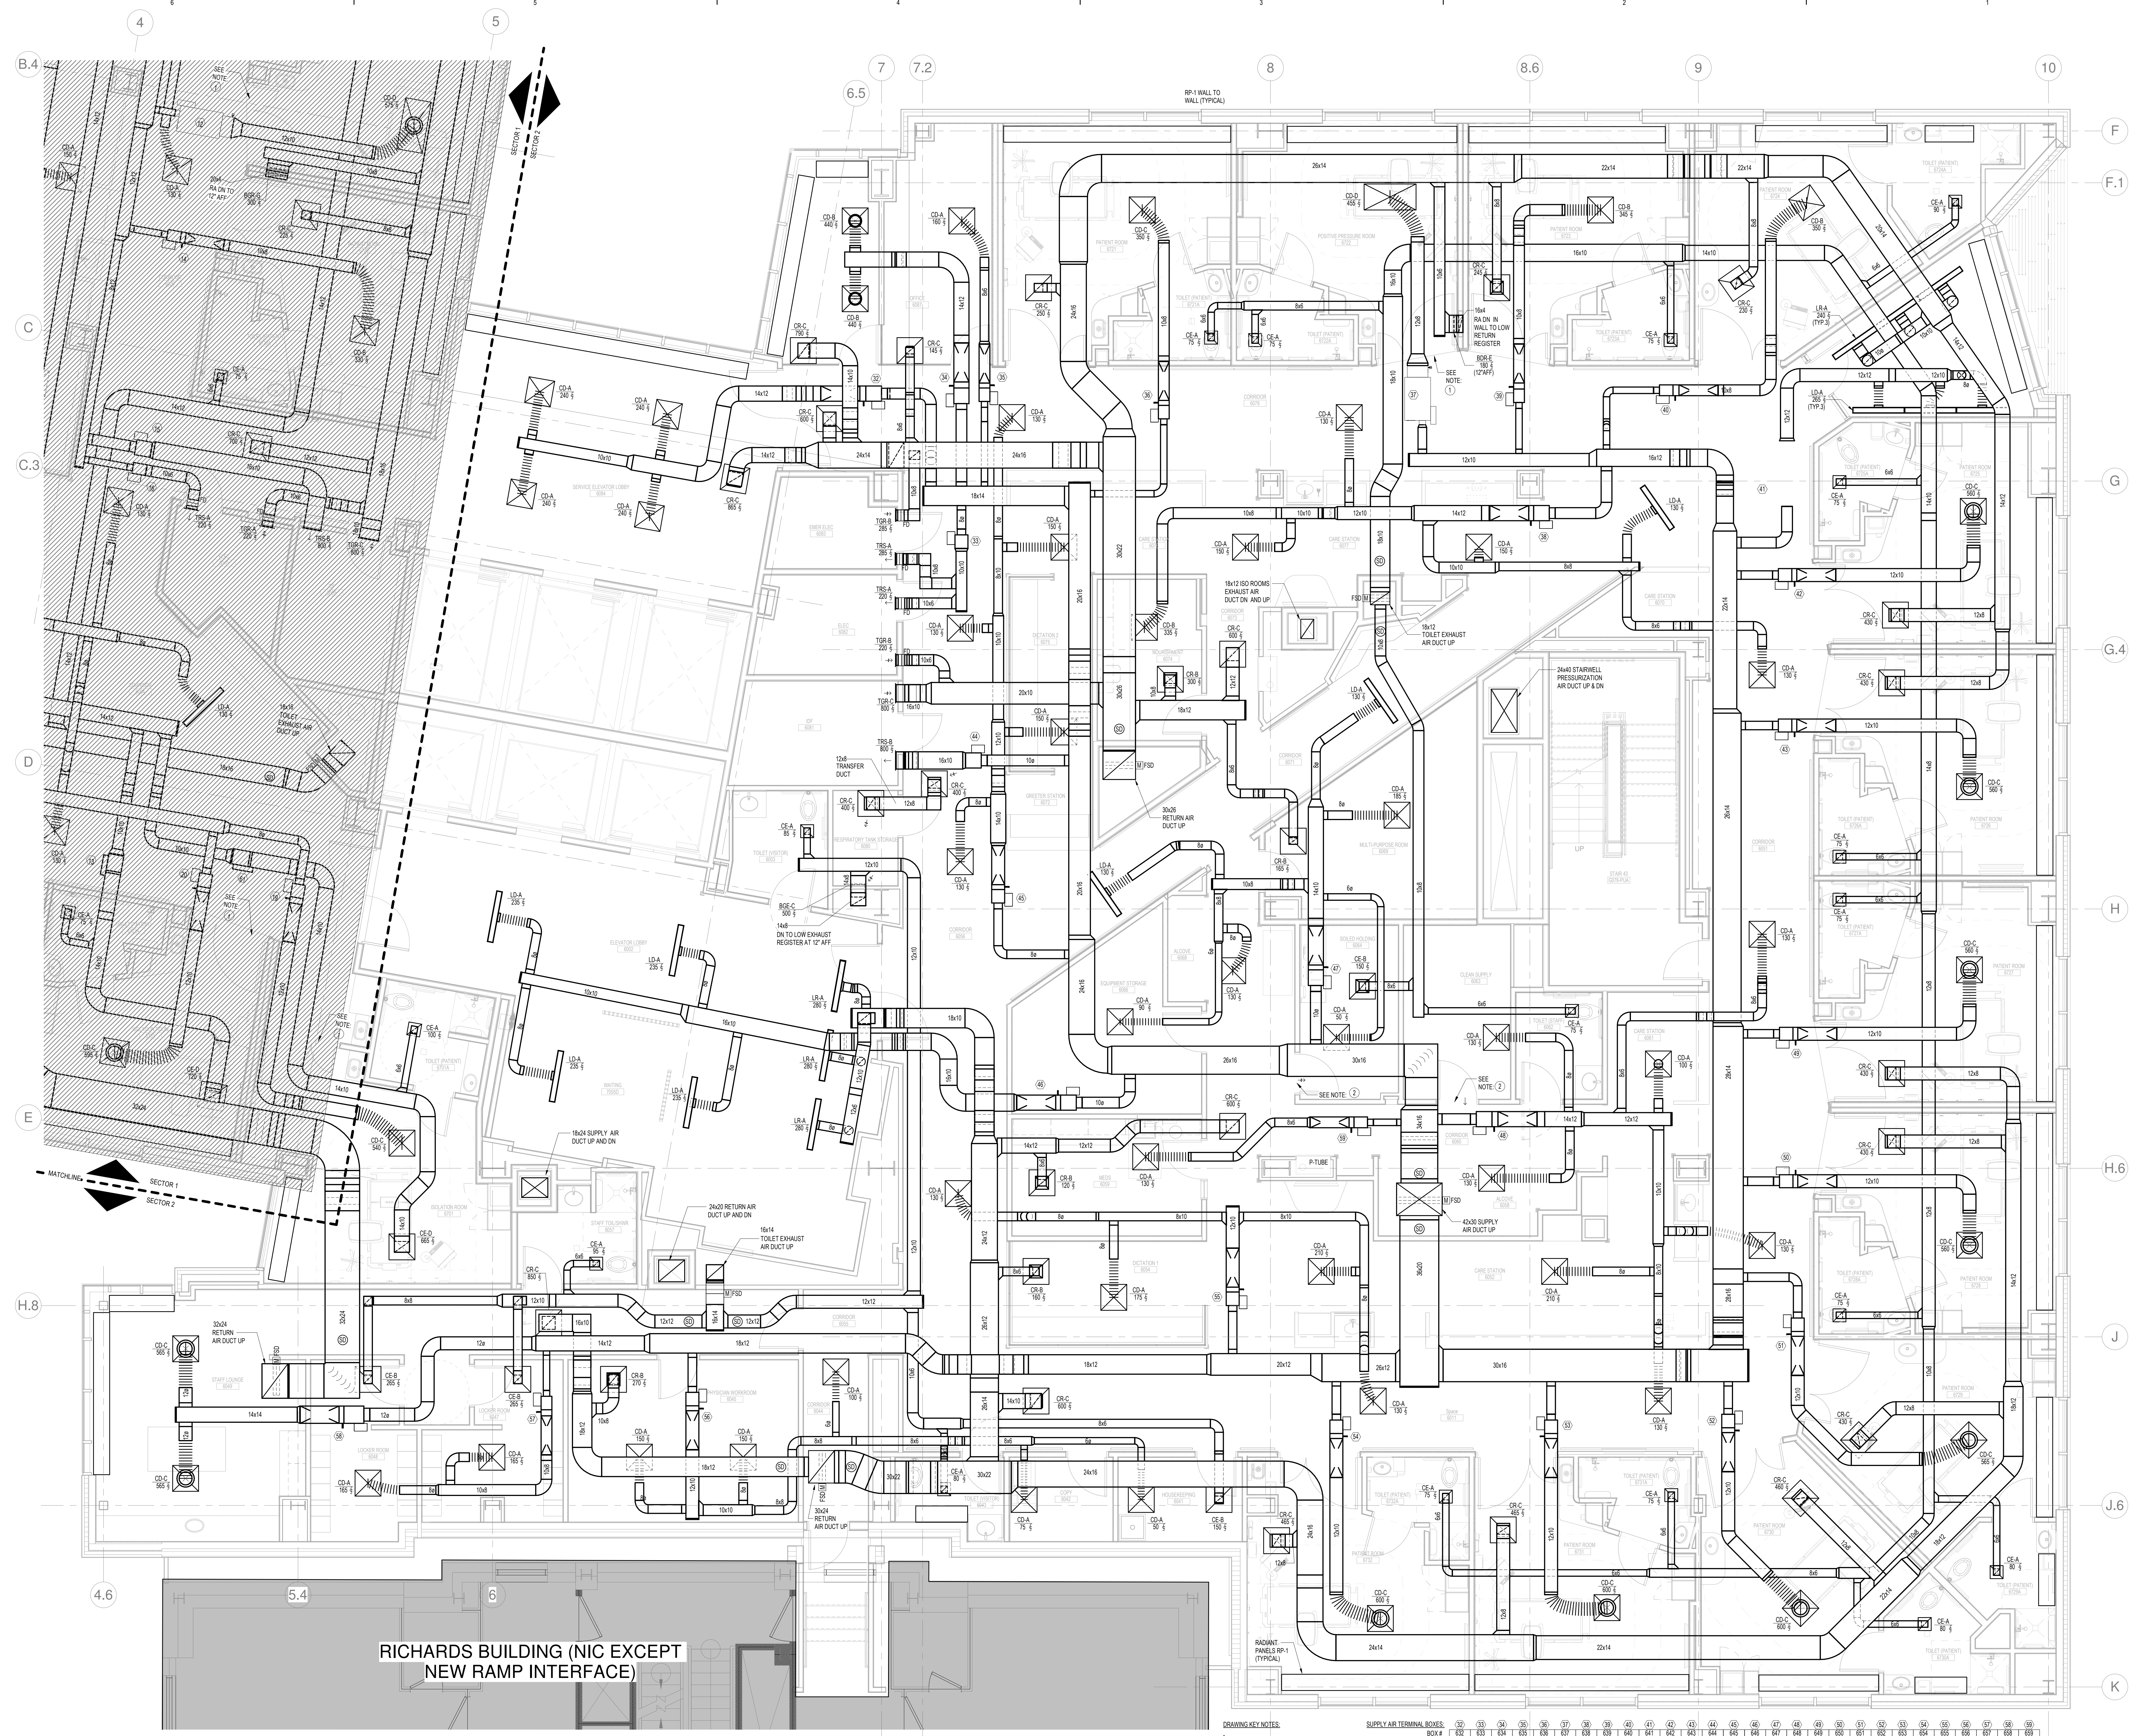

**RICHARDS BUILDING (NIC EXCEPT
 NEW RAMP INTERFACE)**

1 LEVEL 6 - SECTOR 2
 SCALE: 1/4" = 1'-0"

DRAWING KEY NOTES:

- PROVIDE (D/M) DIFFERENTIAL PRESSURE MONITOR ABOVE DOOR.
- PROVIDE 'BALL IN WALL' VISUAL PRESSURE MONITOR ABOVE DOOR.

SUPPLY AIR TERMINAL BOXES	32	33	34	35	36	37	38	39	40	41	42	43	44	45	46	47	48	49	50	51	52	53	54	55	56	57	58
BOX #	630	633	634	635	636	637	638	639	640	641	642	643	644	645	646	647	648	649	650	651	652	653	654	655	656	657	658
CFM MAX	260	330	280	180	280	480	280	480	280	480	280	480	280	480	280	480	280	480	280	480	280	480	280	480	280	480	
CFM MIN	480	590	480	300	480	840	480	840	480	840	480	840	480	840	480	840	480	840	480	840	480	840	480	840	480	840	
CFM W/	1.00	1.04	1.00	0.64	1.00	1.92	1.00	1.92	1.00	1.92	1.00	1.92	1.00	1.92	1.00	1.92	1.00	1.92	1.00	1.92	1.00	1.92	1.00	1.92	1.00		
SIZE	12x14	12x14	12x14	12x14	12x14	12x14	12x14	12x14	12x14	12x14	12x14	12x14	12x14	12x14	12x14	12x14	12x14	12x14	12x14	12x14	12x14	12x14	12x14	12x14	12x14	12x14	
TYPE	CAV1	CAV2	CAV3	CAV4	CAV5	CAV6	CAV7	CAV8	CAV9	CAV10	CAV11	CAV12	CAV13	CAV14	CAV15	CAV16	CAV17	CAV18	CAV19	CAV20	CAV21	CAV22	CAV23	CAV24	CAV25	CAV26	