

CONSULTANTS

CIVIL/LANDSCAPE ARCHITECT
Sebago Technics
75 John Roberts Road, Suite
1A, South Portland, ME 04106

STRUCTURAL/MECHANICAL/ENVIRONMENTAL CONSULTANT
Simpson Gumpertz & Heger Inc.
41 Sevon Street, Building 1, Suite 570
Waltham, MA 02453

MEPP ENGINEER/OWNER
AKF Group LLC
99 Bedford Street, 2nd Floor, Boston MA 02111


CONSTRUCTION MANAGER
Turner Construction
2 Seaport Lane, Suite 200, Boston, MA 02210

ELEVATOR CONSULTANT
VDA (Van Deusen & Associates)
101 Summer Street, 4th Floor, Boston MA
02110



COST ESTIMATOR
D. G. Jones International
3 Baldwin Green Common, Suite 202, Woburn, MA 01801

PROJECT TITLE

**East Tower 6 & 7
Addition**
22 Bramhall Street
Portland, ME 04102

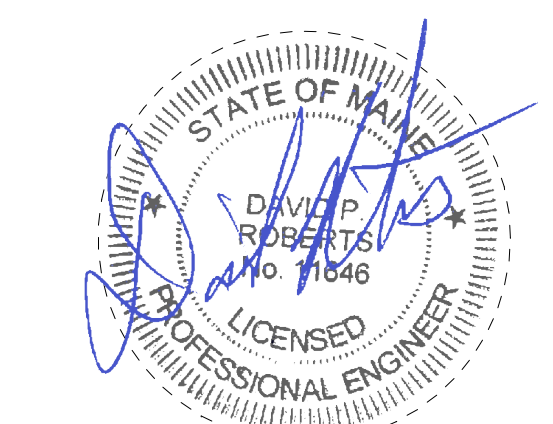

KEY PLANS

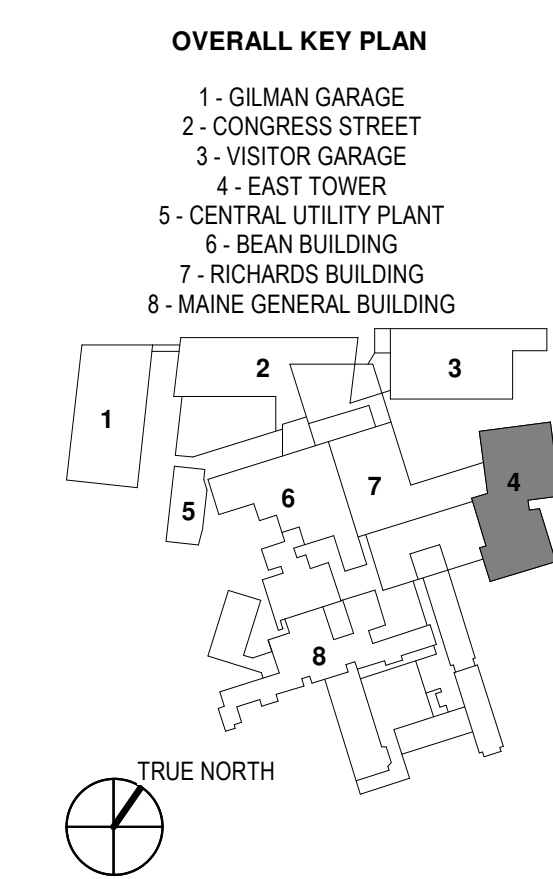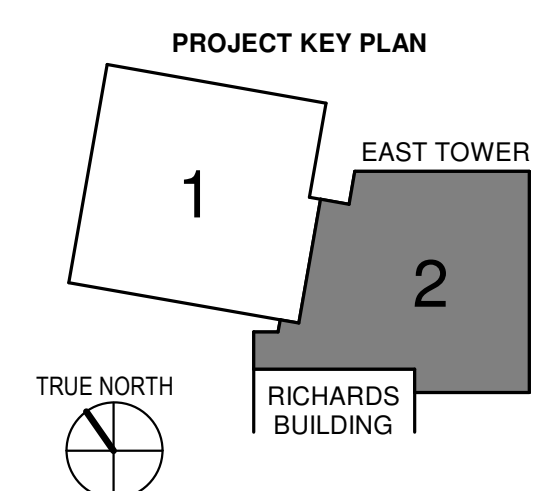

CONSTRUCTION DOCUMENTS
JANUARY 26, 2018

| NO | ISSUE | DATE |
|----|----------------|----------|
| 1 | ADDENDUM NO. 1 | 03/22/18 |

Job Number: B150312-000
Drawn: TU
Checked: DPR
Approved: DPR

TITLE
**MECHANICAL
PENTHOUSE
DUCTWORK PLAN -
SECTOR 2**

SHEET NUMBER

M11-92



1 PENTHOUSE - SECTOR 2
SCALE: 1/8" = 1'-0"

3/29/2018 11:30:09 AM
C:\Revit Local Files_B150312-000\MDC East Tower 6&7 MEP17_Constr_documents.rvt