
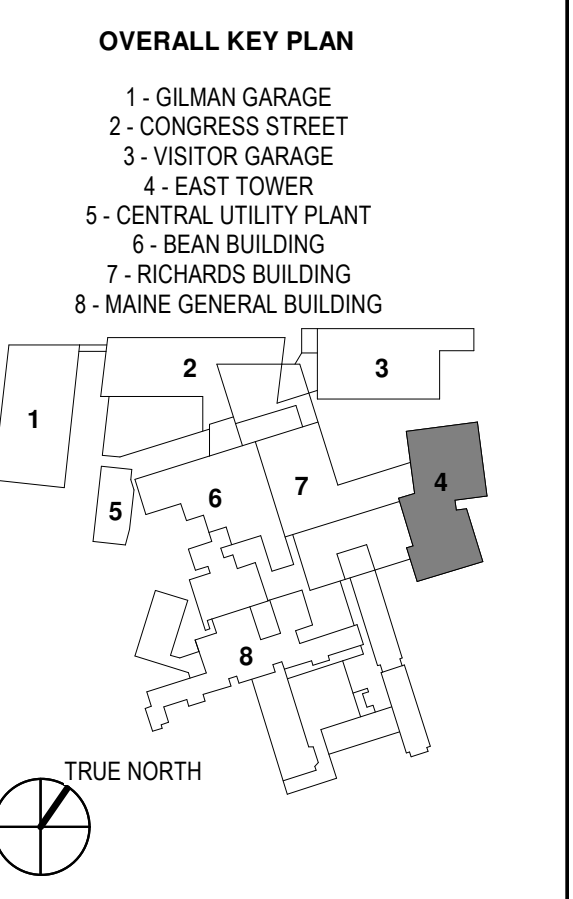


KEY PLANS

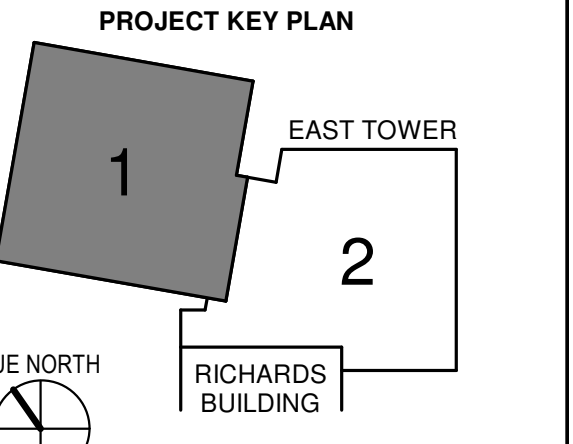


CONSTRUCTION DOCUMENTS  
JANUARY 28, 2018

ADDENDUM NO.	DATE
1	03/22/18

NO.	ISSUE	DATE
Job Number	B150312-000	
Drawn	TU	
Checked	DFR	
Approved	DFR	

TITLE  
**MECHANICAL  
FIFTH FLOOR  
PIPING PLAN -  
SECTOR 1**

SHEET NUMBER  
**M13-51**

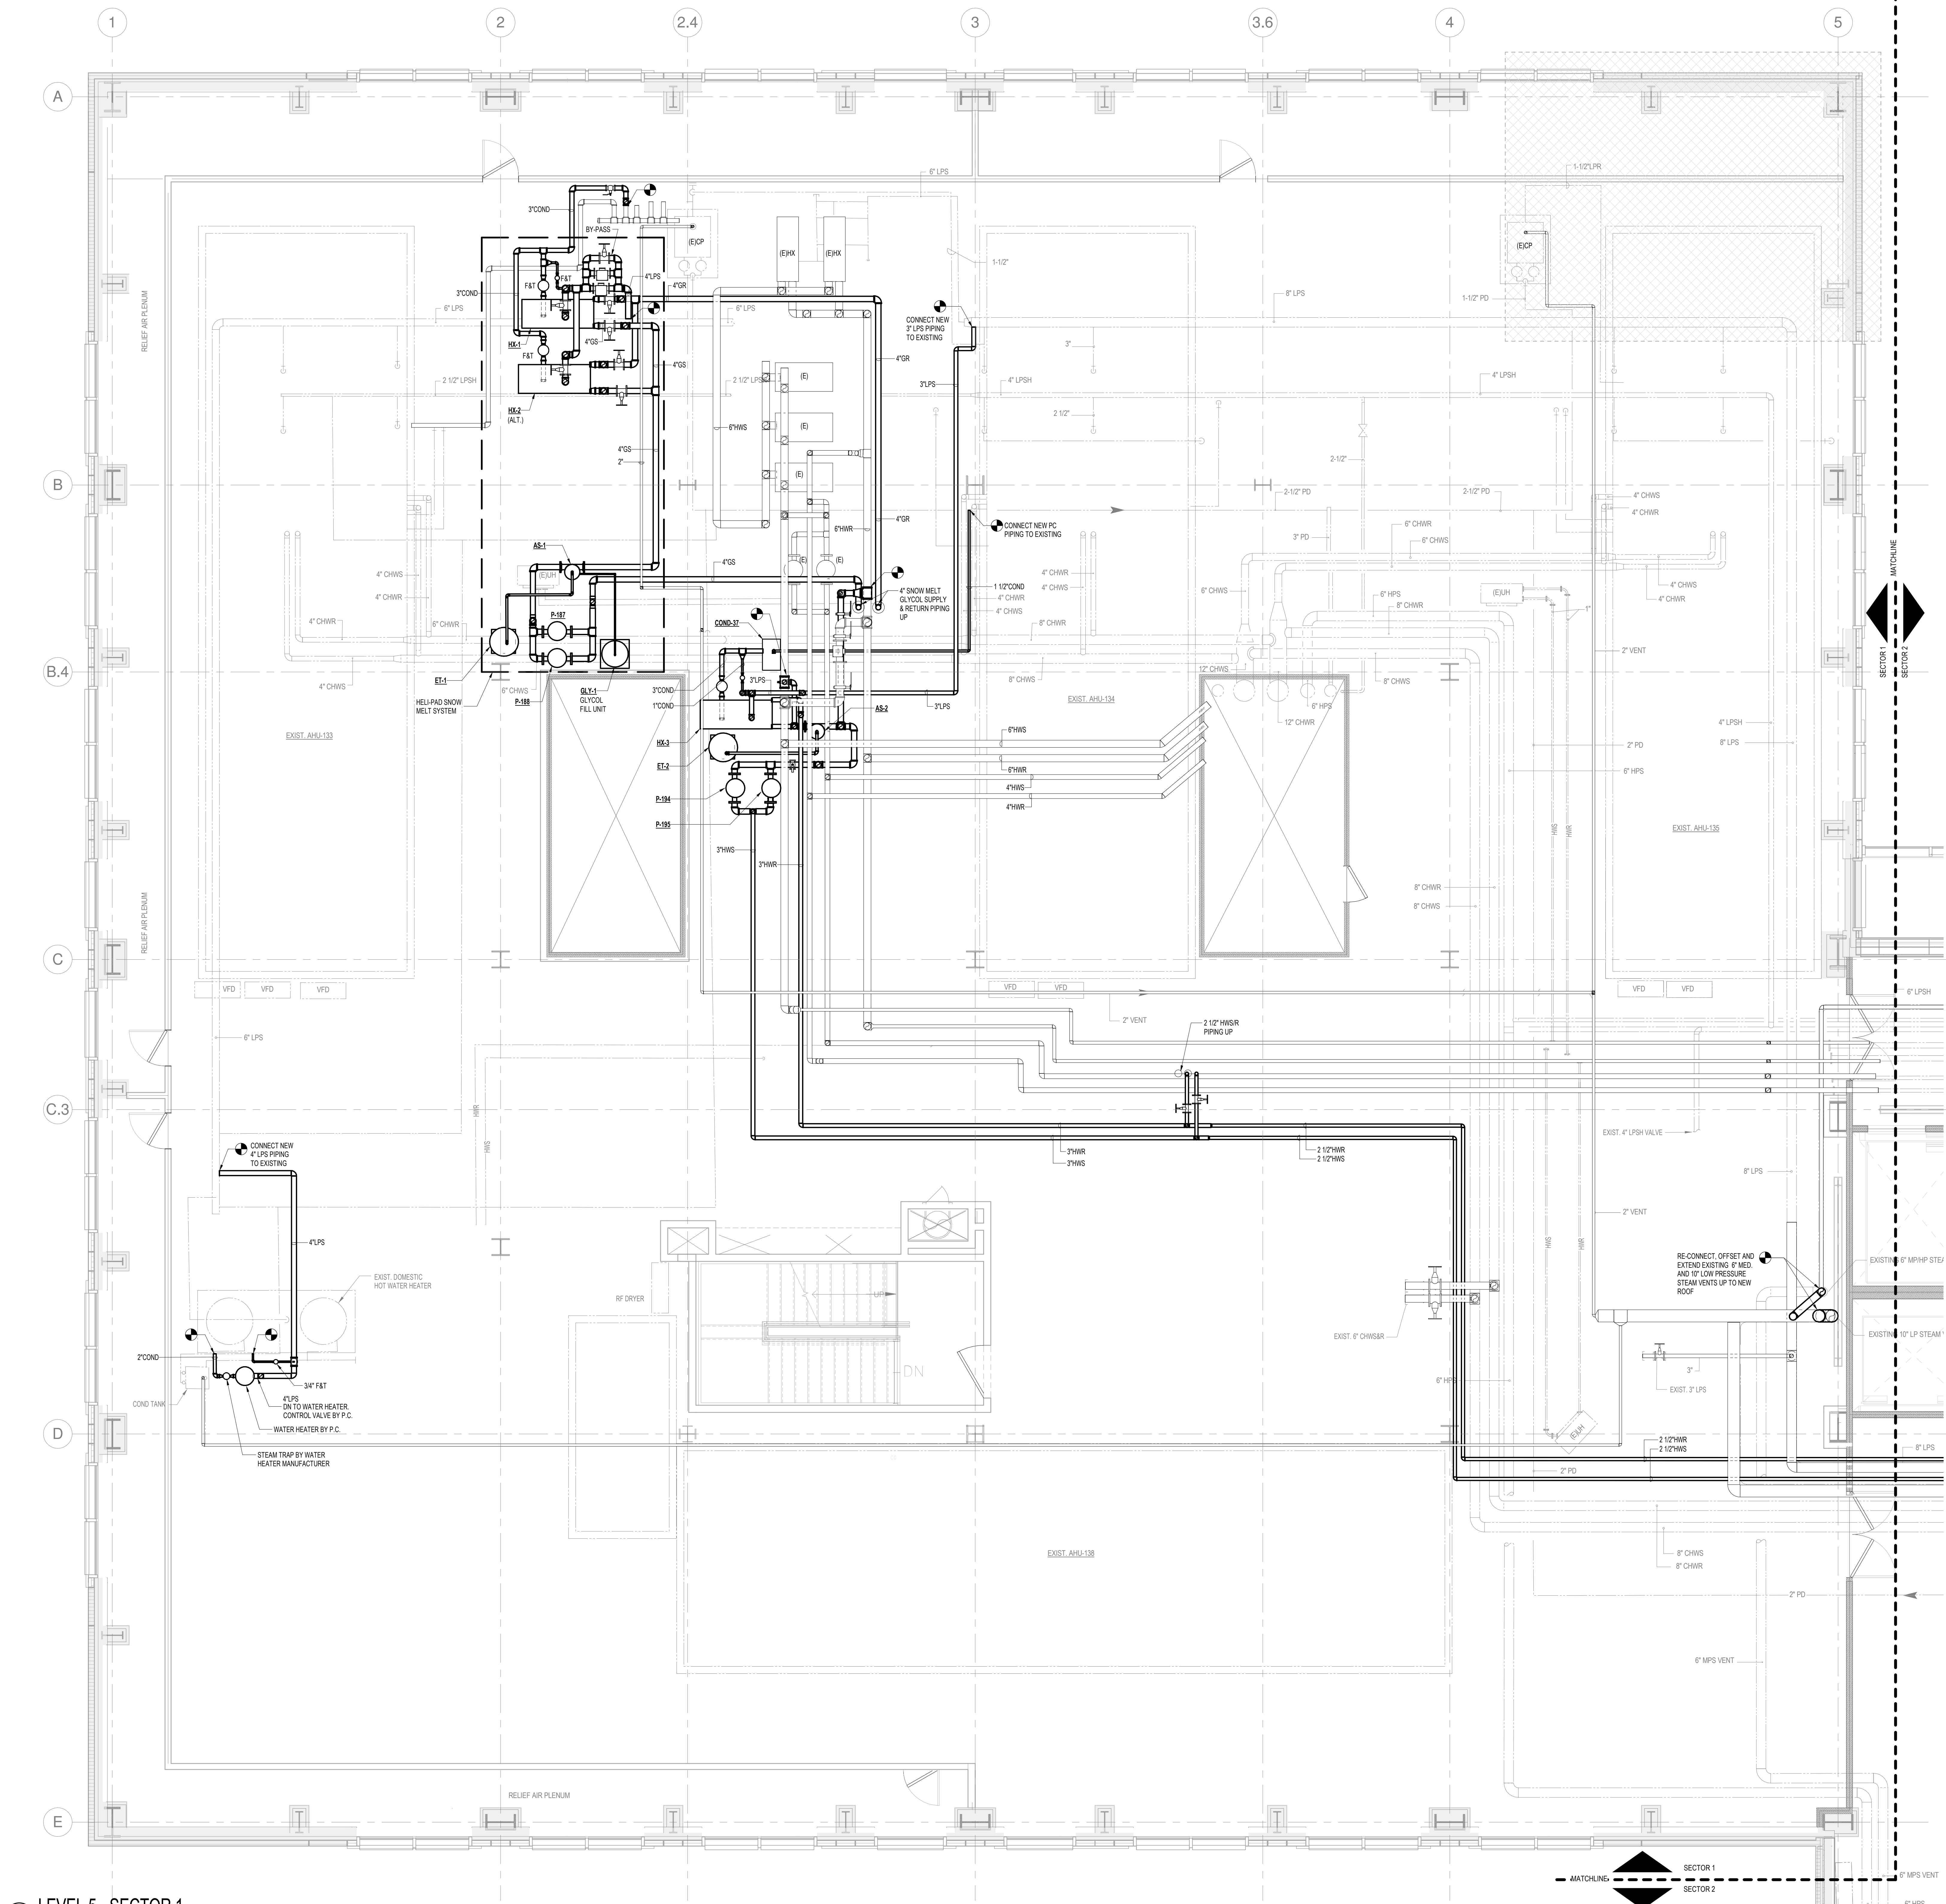

1 LEVEL 5 - SECTOR 1  
SCALE: 1/8" = 1'-0"

3/29/2018 11:30:50 AM  
C:\Revit Local Files\_B150312\000\MDC East Tower 6&7 MEP17\_Constr\_documents.rvt