
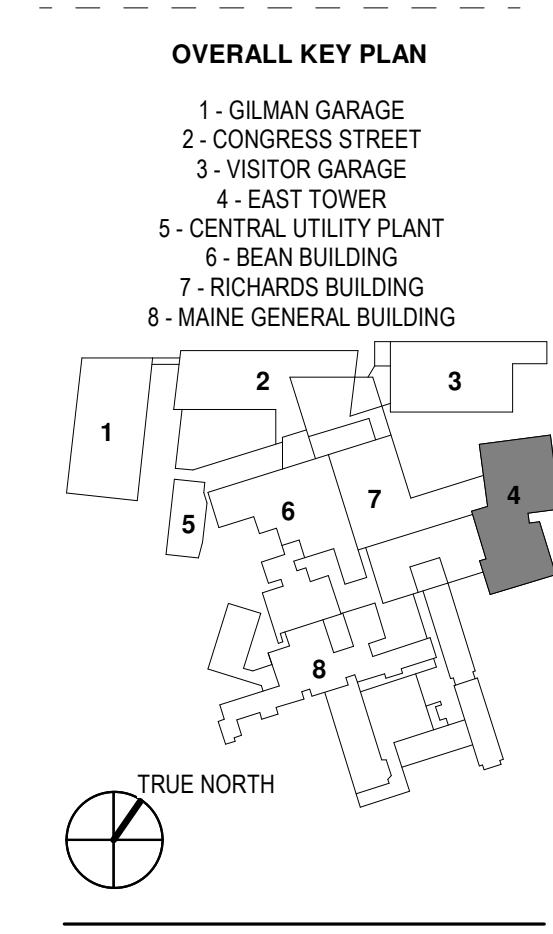


KEY PLANS

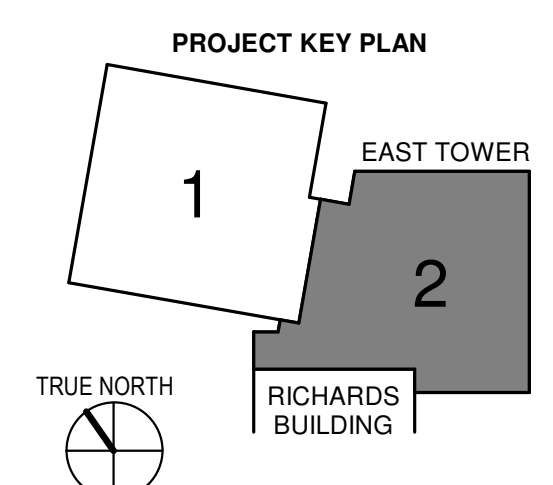


CONSTRUCTION DOCUMENTS
 JANUARY 28, 2018

ADDENDUM NO.	DATE
1	03/22/18
NO	ISSUE
Job Number	B150312-000
Drawn	TU
Checked	DFR
Approved	DFR

TITLE
**MECHANICAL
 SEVENTH FLOOR
 PIPING PLAN -
 SECTOR 2**

SHEET NUMBER
M13-72

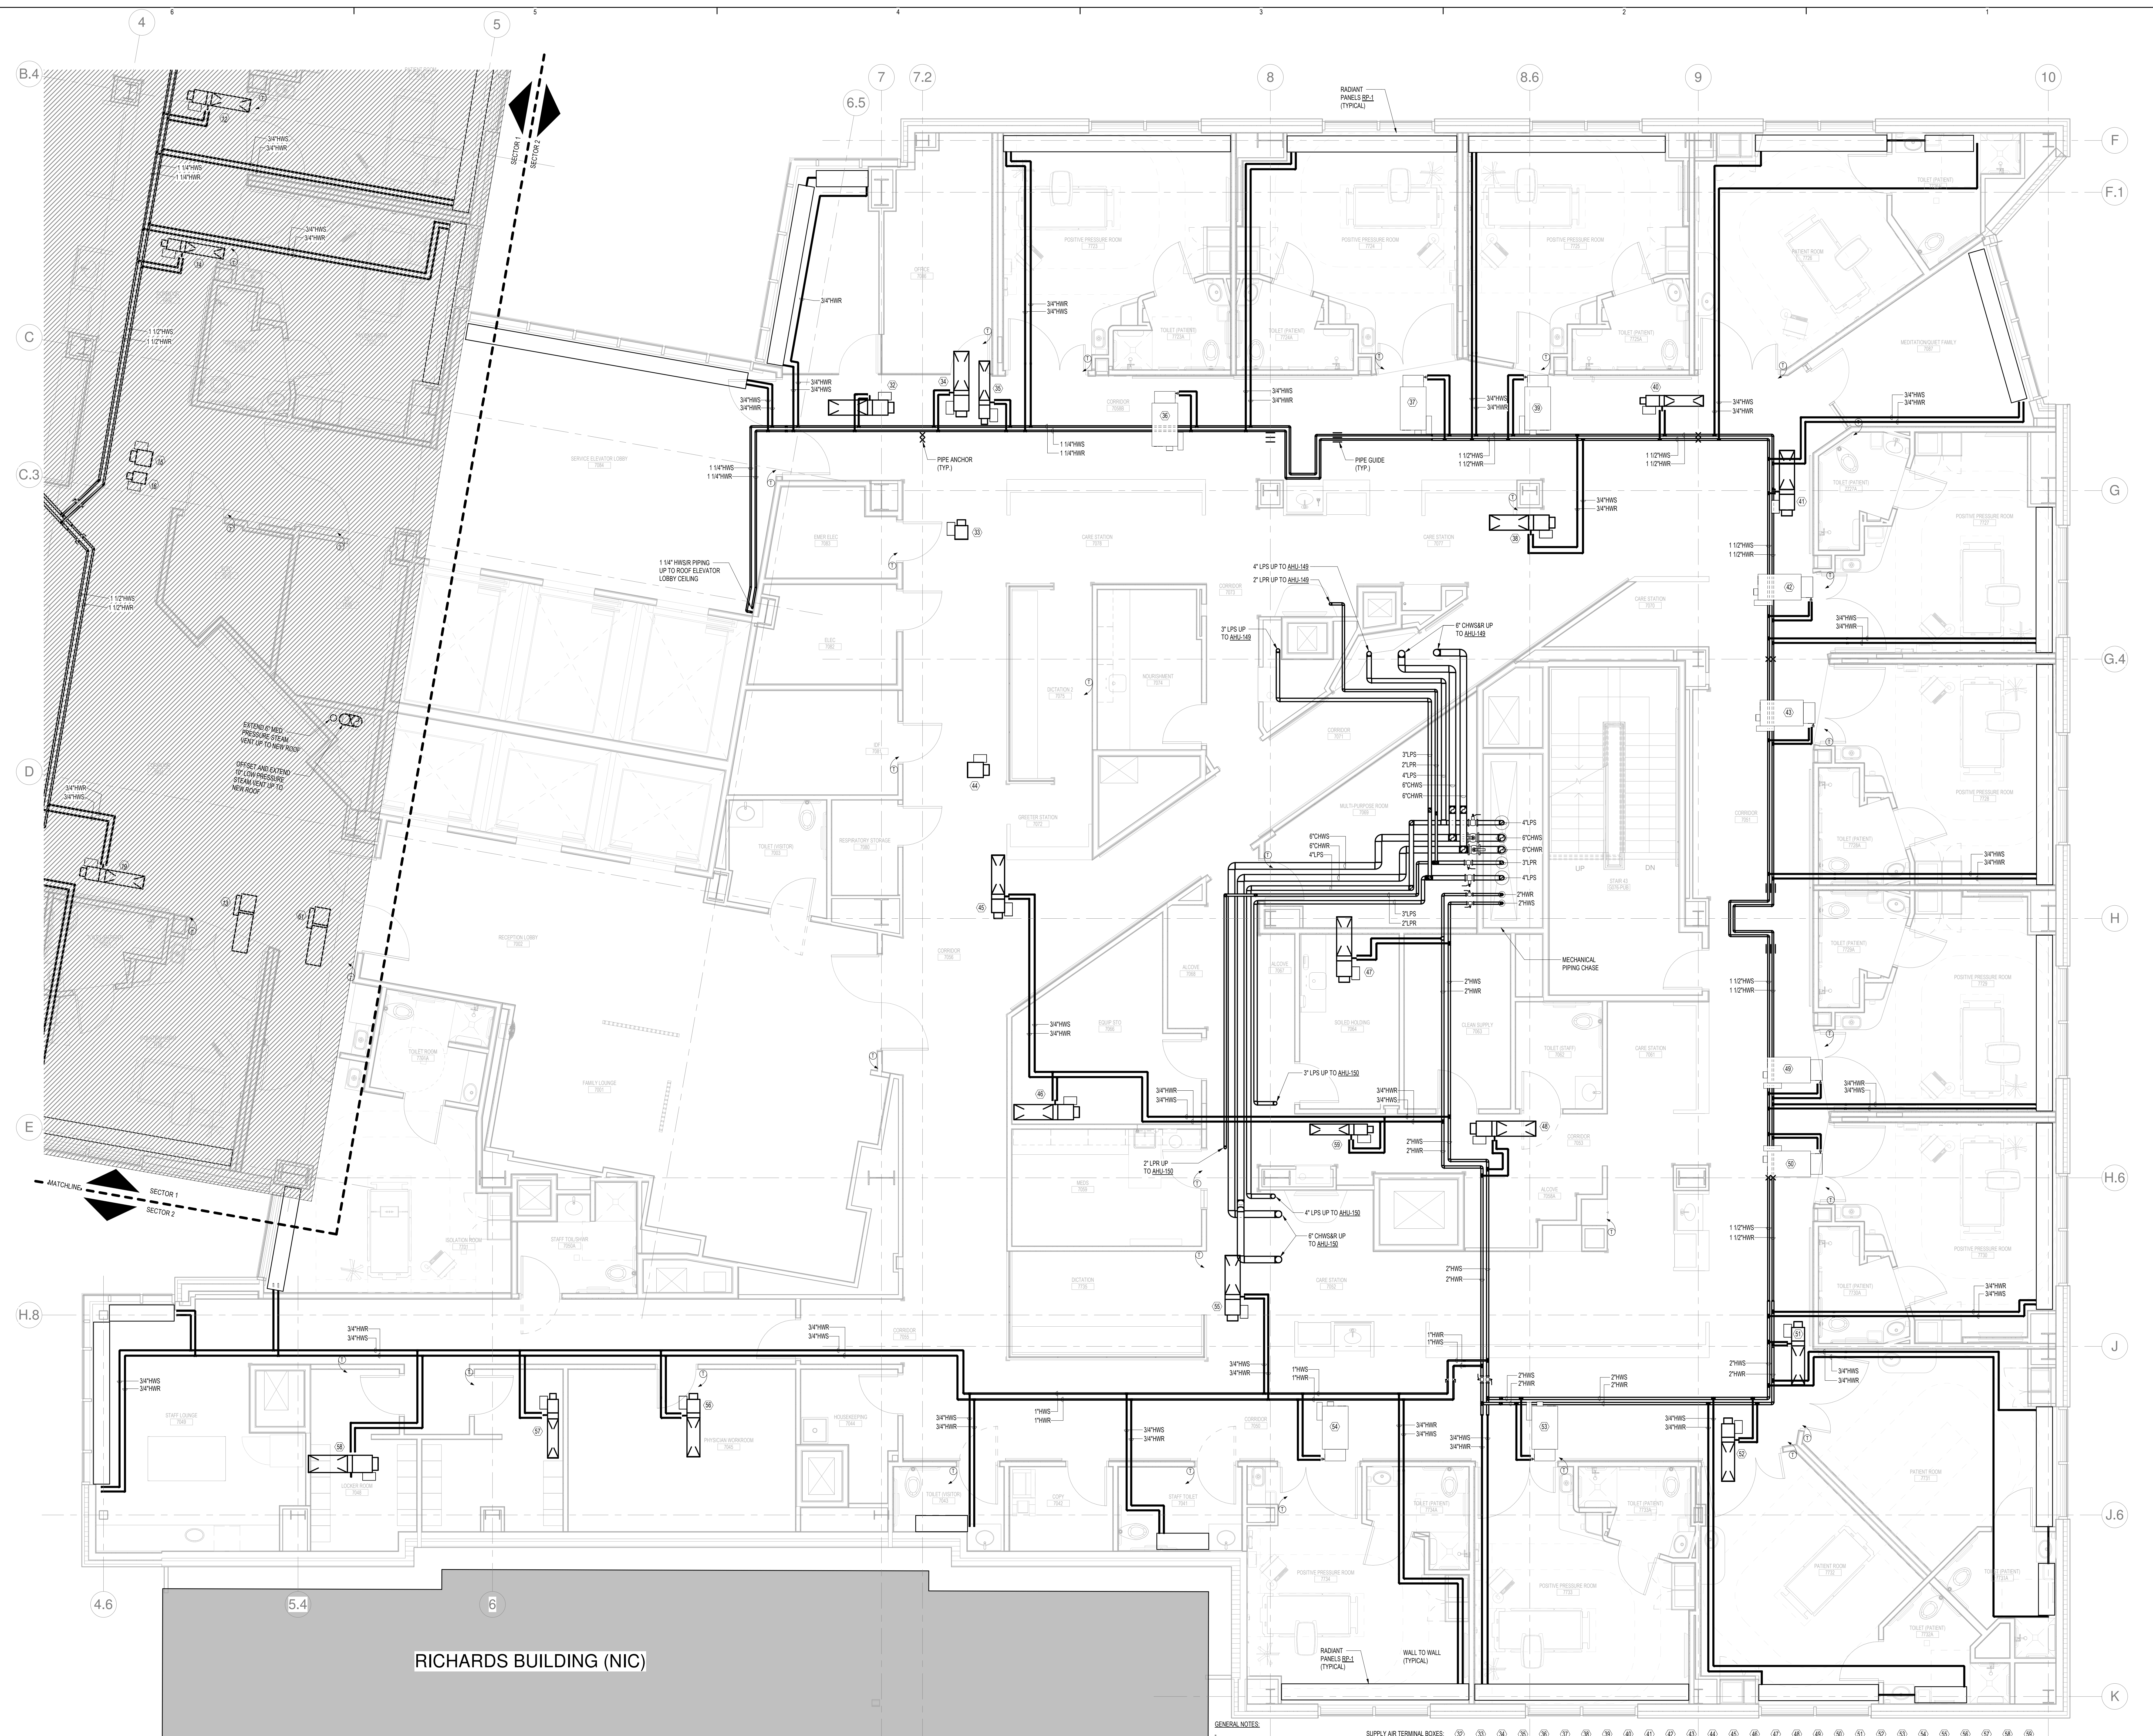

1 LEVEL 7 - SECTOR 2
 SCALE: 1/8" = 1'-0"

GENERAL NOTES:

- MOUNT RADIANT PANEL CONTROL VALVES OUTSIDE OF PATIENT ROOMS.
- PROVIDE A DUCTILE ALTERNATE TO ELIMINATE THE RADIANT PANELS, ASSOCIATED RUNOUTS AND CONTROLS.

BOX #	32	33	34	35	36	37	38	39	40	41	42	43	44	45	46	47	48	49	50	51	52	53	54	55	56	57	58	59
QTY	720	735	750	765	780	795	810	825	840	855	870	885	900	915	930	945	960	975	990	1005	1020	1035	1050	1065	1080	1095	1110	1125
QTY	480	495	510	525	540	555	570	585	600	615	630	645	660	675	690	705	720	735	750	765	780	795	810	825	840	855	870	885
QTY	1080	1125	1170	1215	1260	1305	1350	1395	1440	1485	1530	1575	1620	1665	1710	1755	1800	1845	1890	1935	1980	2025	2070	2115	2160	2205	2250	2295
QTY	1080	1125	1170	1215	1260	1305	1350	1395	1440	1485	1530	1575	1620	1665	1710	1755	1800	1845	1890	1935	1980	2025	2070	2115	2160	2205	2250	2295