
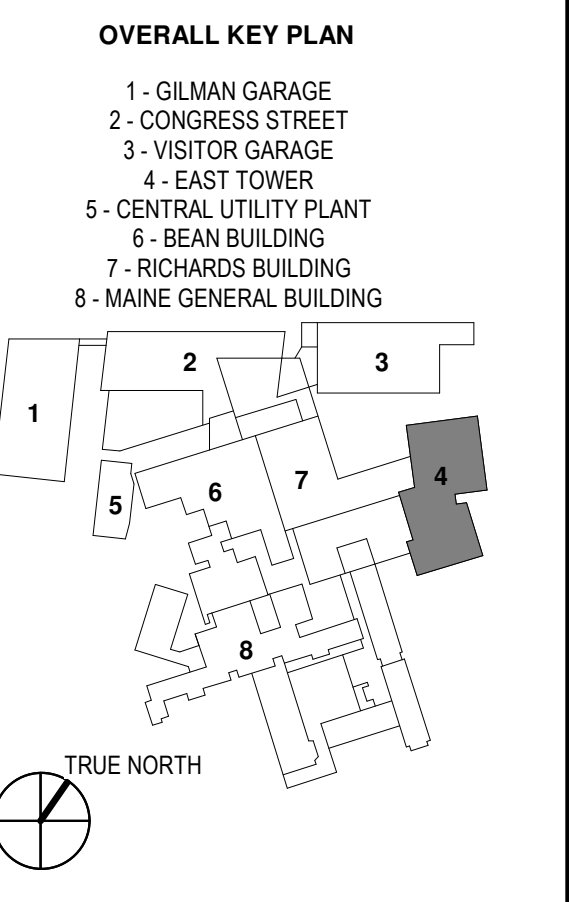


KEY PLANS

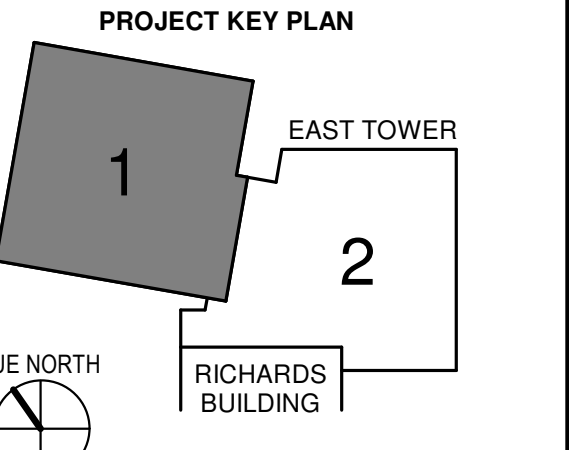


CONSTRUCTION DOCUMENTS
JANUARY 26, 2018

NO	ISSUE	DATE
Job Number	B150312-000	
Drawn	MAG	
Checked	MFR	
Approved	MFR	

TITLE
ELECTRICAL ROOF
DEMOLITION PLAN
- SECTOR 1

SHEET NUMBER
E04-61

- DRAWING NOTES - ROOF PLAN:**
- REFER TO DRAWINGS E00-01 FOR ELECTRICAL SYMBOLS, DEMOLITION NOTES AND ABBREVIATIONS.
 - REFER TO DRAWINGS E00-11 AND E00-12 FOR ELECTRICAL AND MECHANICAL EQUIPMENT SCHEDULES.
 - COORDINATE EXACT LOCATION OF ALL MECHANICAL EQUIPMENT WITH MECHANICAL DRAWINGS.
 - ALL FEEDS OR BRANCH CIRCUITS RELATED TO EQUIPMENT SHOWN TO BE REMOVED SHALL BE REMOVED BACK TO SOURCE PANELBOARD.

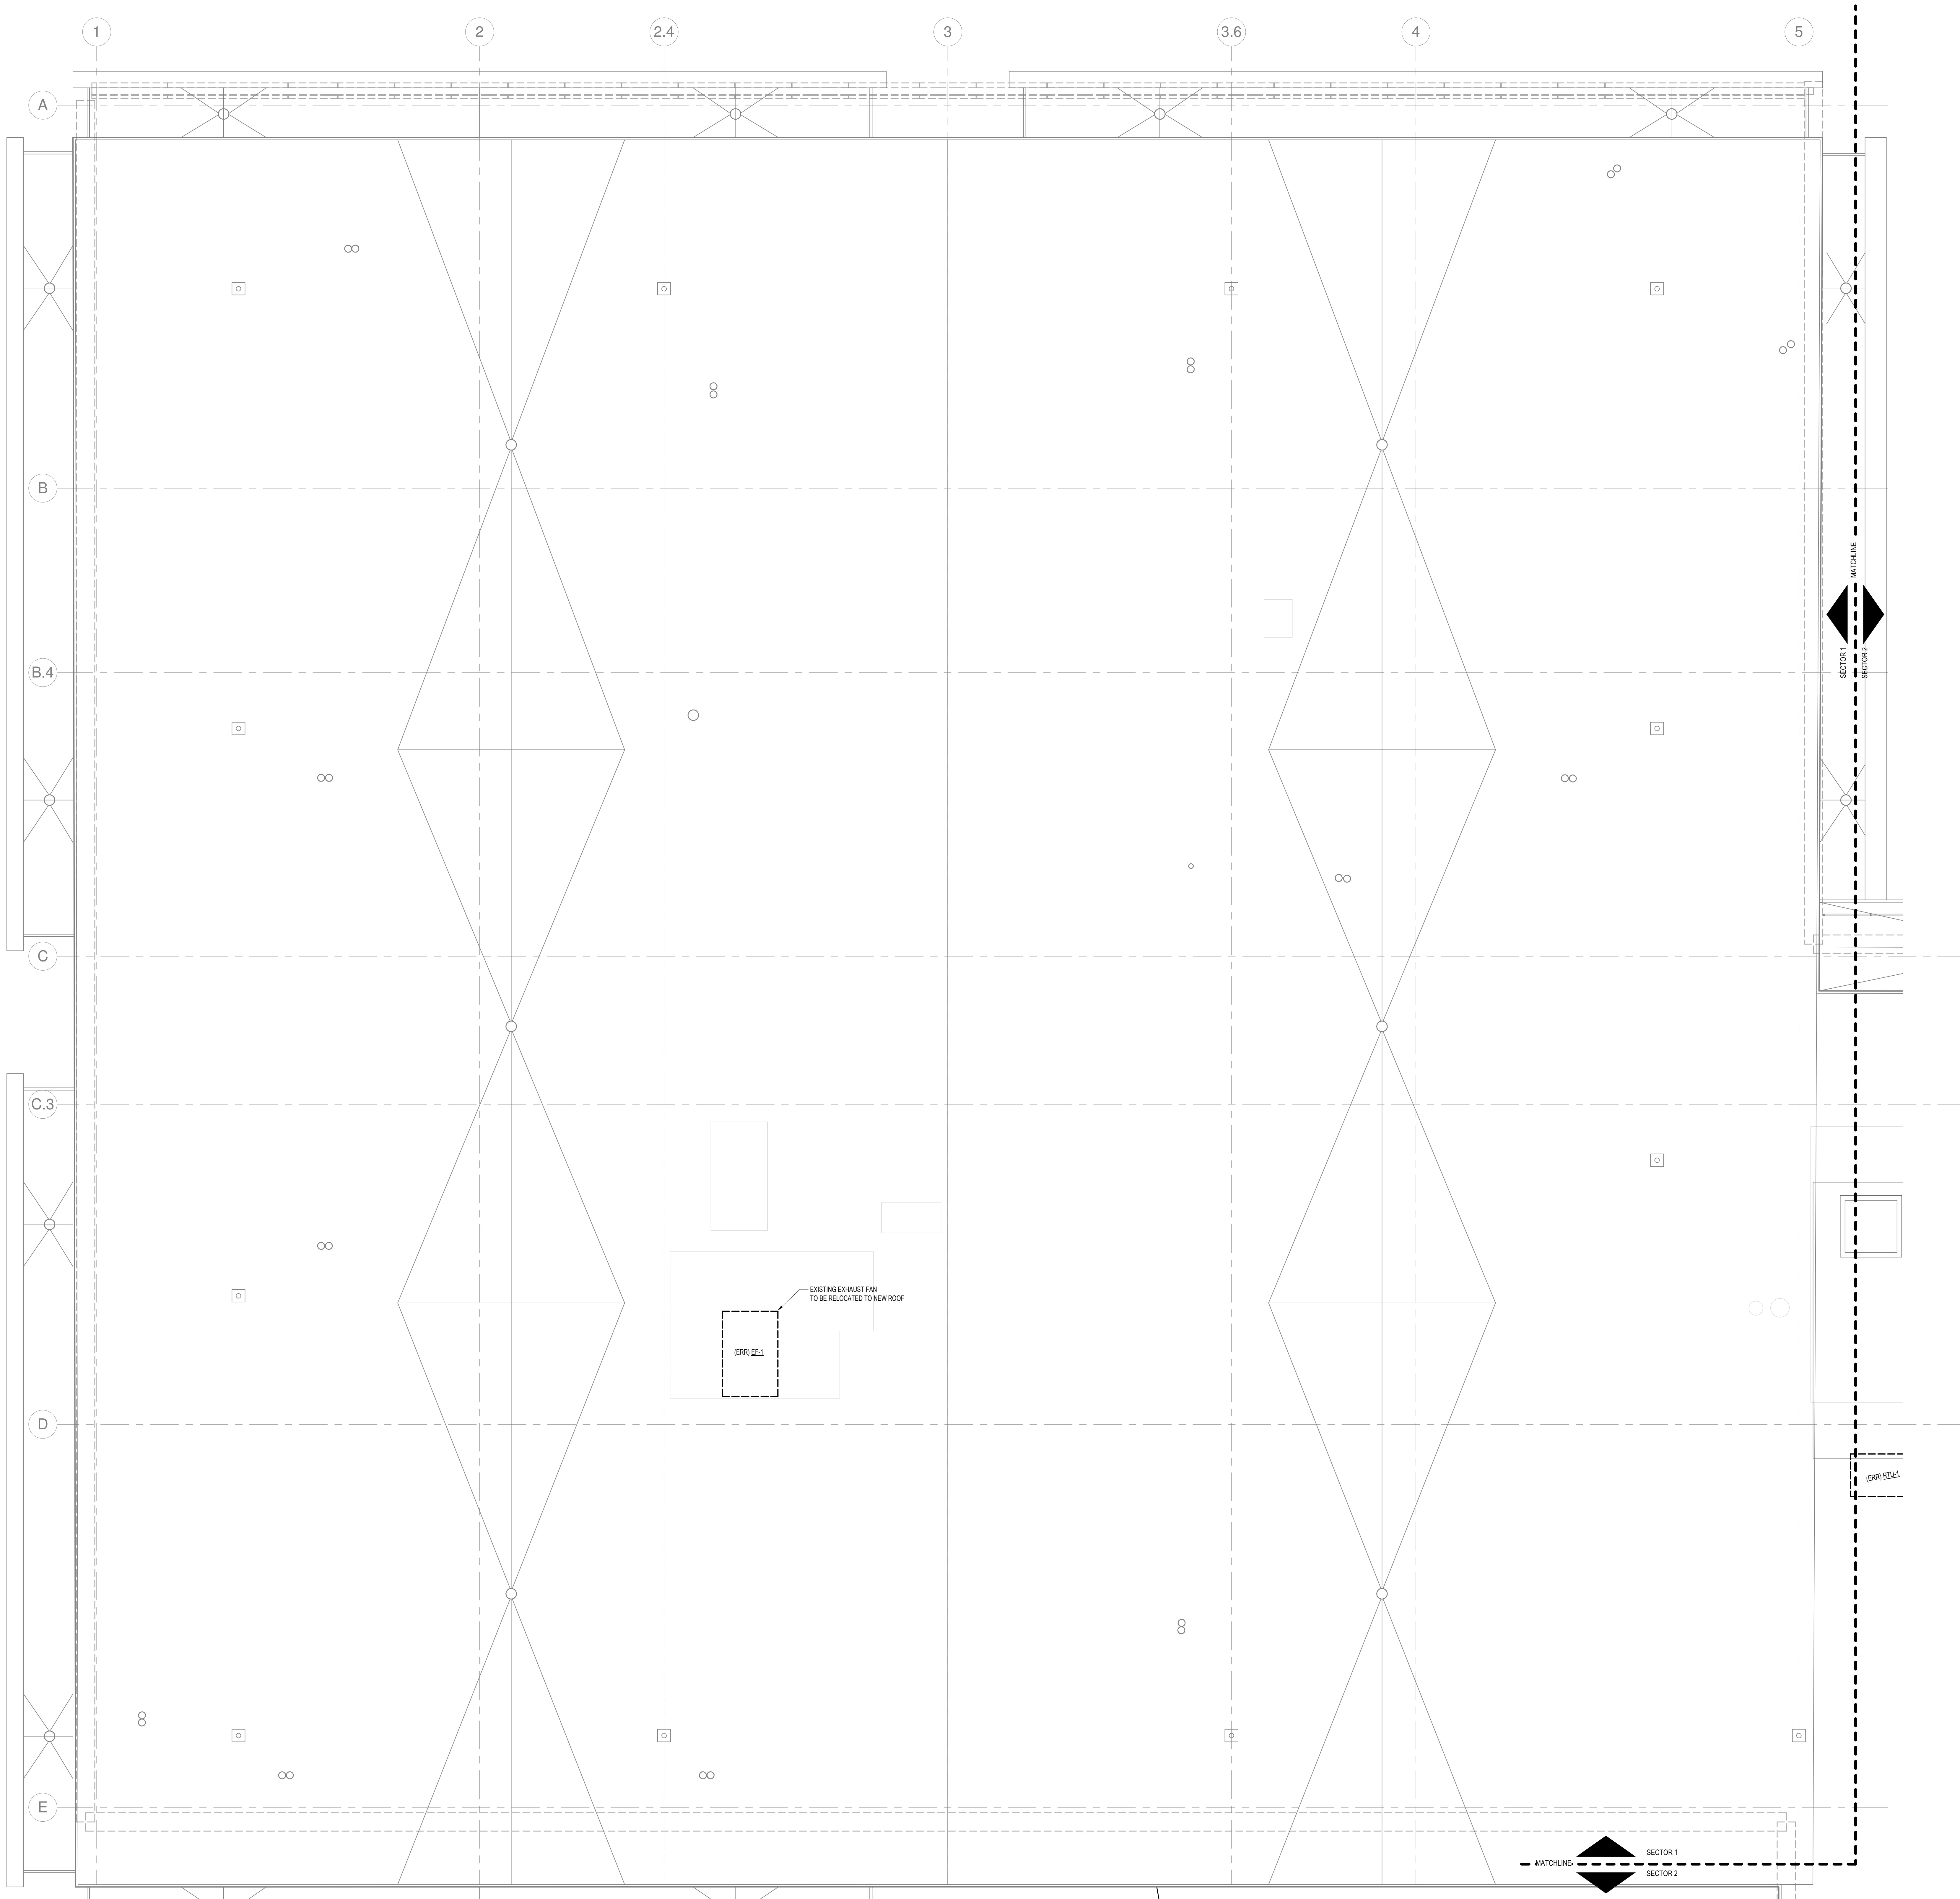

1 LEVEL 6 - SECTOR 1
SCALE: 1/4" = 1'-0"

3/23/2018 11:05:55 AM
C:\Revit Local Files_B150312\000\MDC East Tower 6&7 MEP17_Constr.docx