


NO	ISSUE	DATE
Job Number	B150312-000	
Drawn	MMS	
Checked	MFR	
Approved	MFR	

- DRAWING NOTES - ROOF PLAN:**
- REFER TO DRAWING E00-01 FOR ELECTRICAL SYMBOLS, NOTES AND ABBREVIATIONS.
  - REFER TO DRAWINGS E00-11 AND E00-12 FOR ELECTRICAL AND MECHANICAL EQUIPMENT SCHEDULES.
  - REFER TO ARCHITECTURAL FLOOR PLANS AND ELEVATIONS FOR EXACT LOCATIONS, MOUNTING HEIGHTS AND QUANTITIES OF RECEPTACLES AND POWER DEVICES PRIOR TO INSTALLATION ON THE FLOOR PLANS.
  - ALL 120V AND 208V POWER DEVICES SHALL BE CIRCUITED TO 150/208V PANELBOARDS AS INDICATED ON THE FLOOR PLANS.
  - COORDINATE EXACT LOCATION OF ALL MECHANICAL AND PLUMBING EQUIPMENT WITH MECHANICAL AND PLUMBING DRAWINGS.
  - ALL BRANCH CIRCUITS IN EXCESS OF 100' ARE TO UTILIZE #10AWG CONDUCTORS.
  - PROVIDE A UL 98A MASTER LABEL LIGHTNING PROTECTION SYSTEM. REFER TO SPECIFICATIONS FOR ADDITIONAL REQUIREMENTS.
  - NUMERAL ADJACENT TO THE DEVICES DENOTES CIRCUIT NUMBER. MINIMUM BRANCH CIRCUIT WIRING TO BE 2#12, 1#12 GROUND INSTALLED CONCEALED. REFER TO ELECTRICAL SPECIFICATIONS FOR WIRING METHODS.

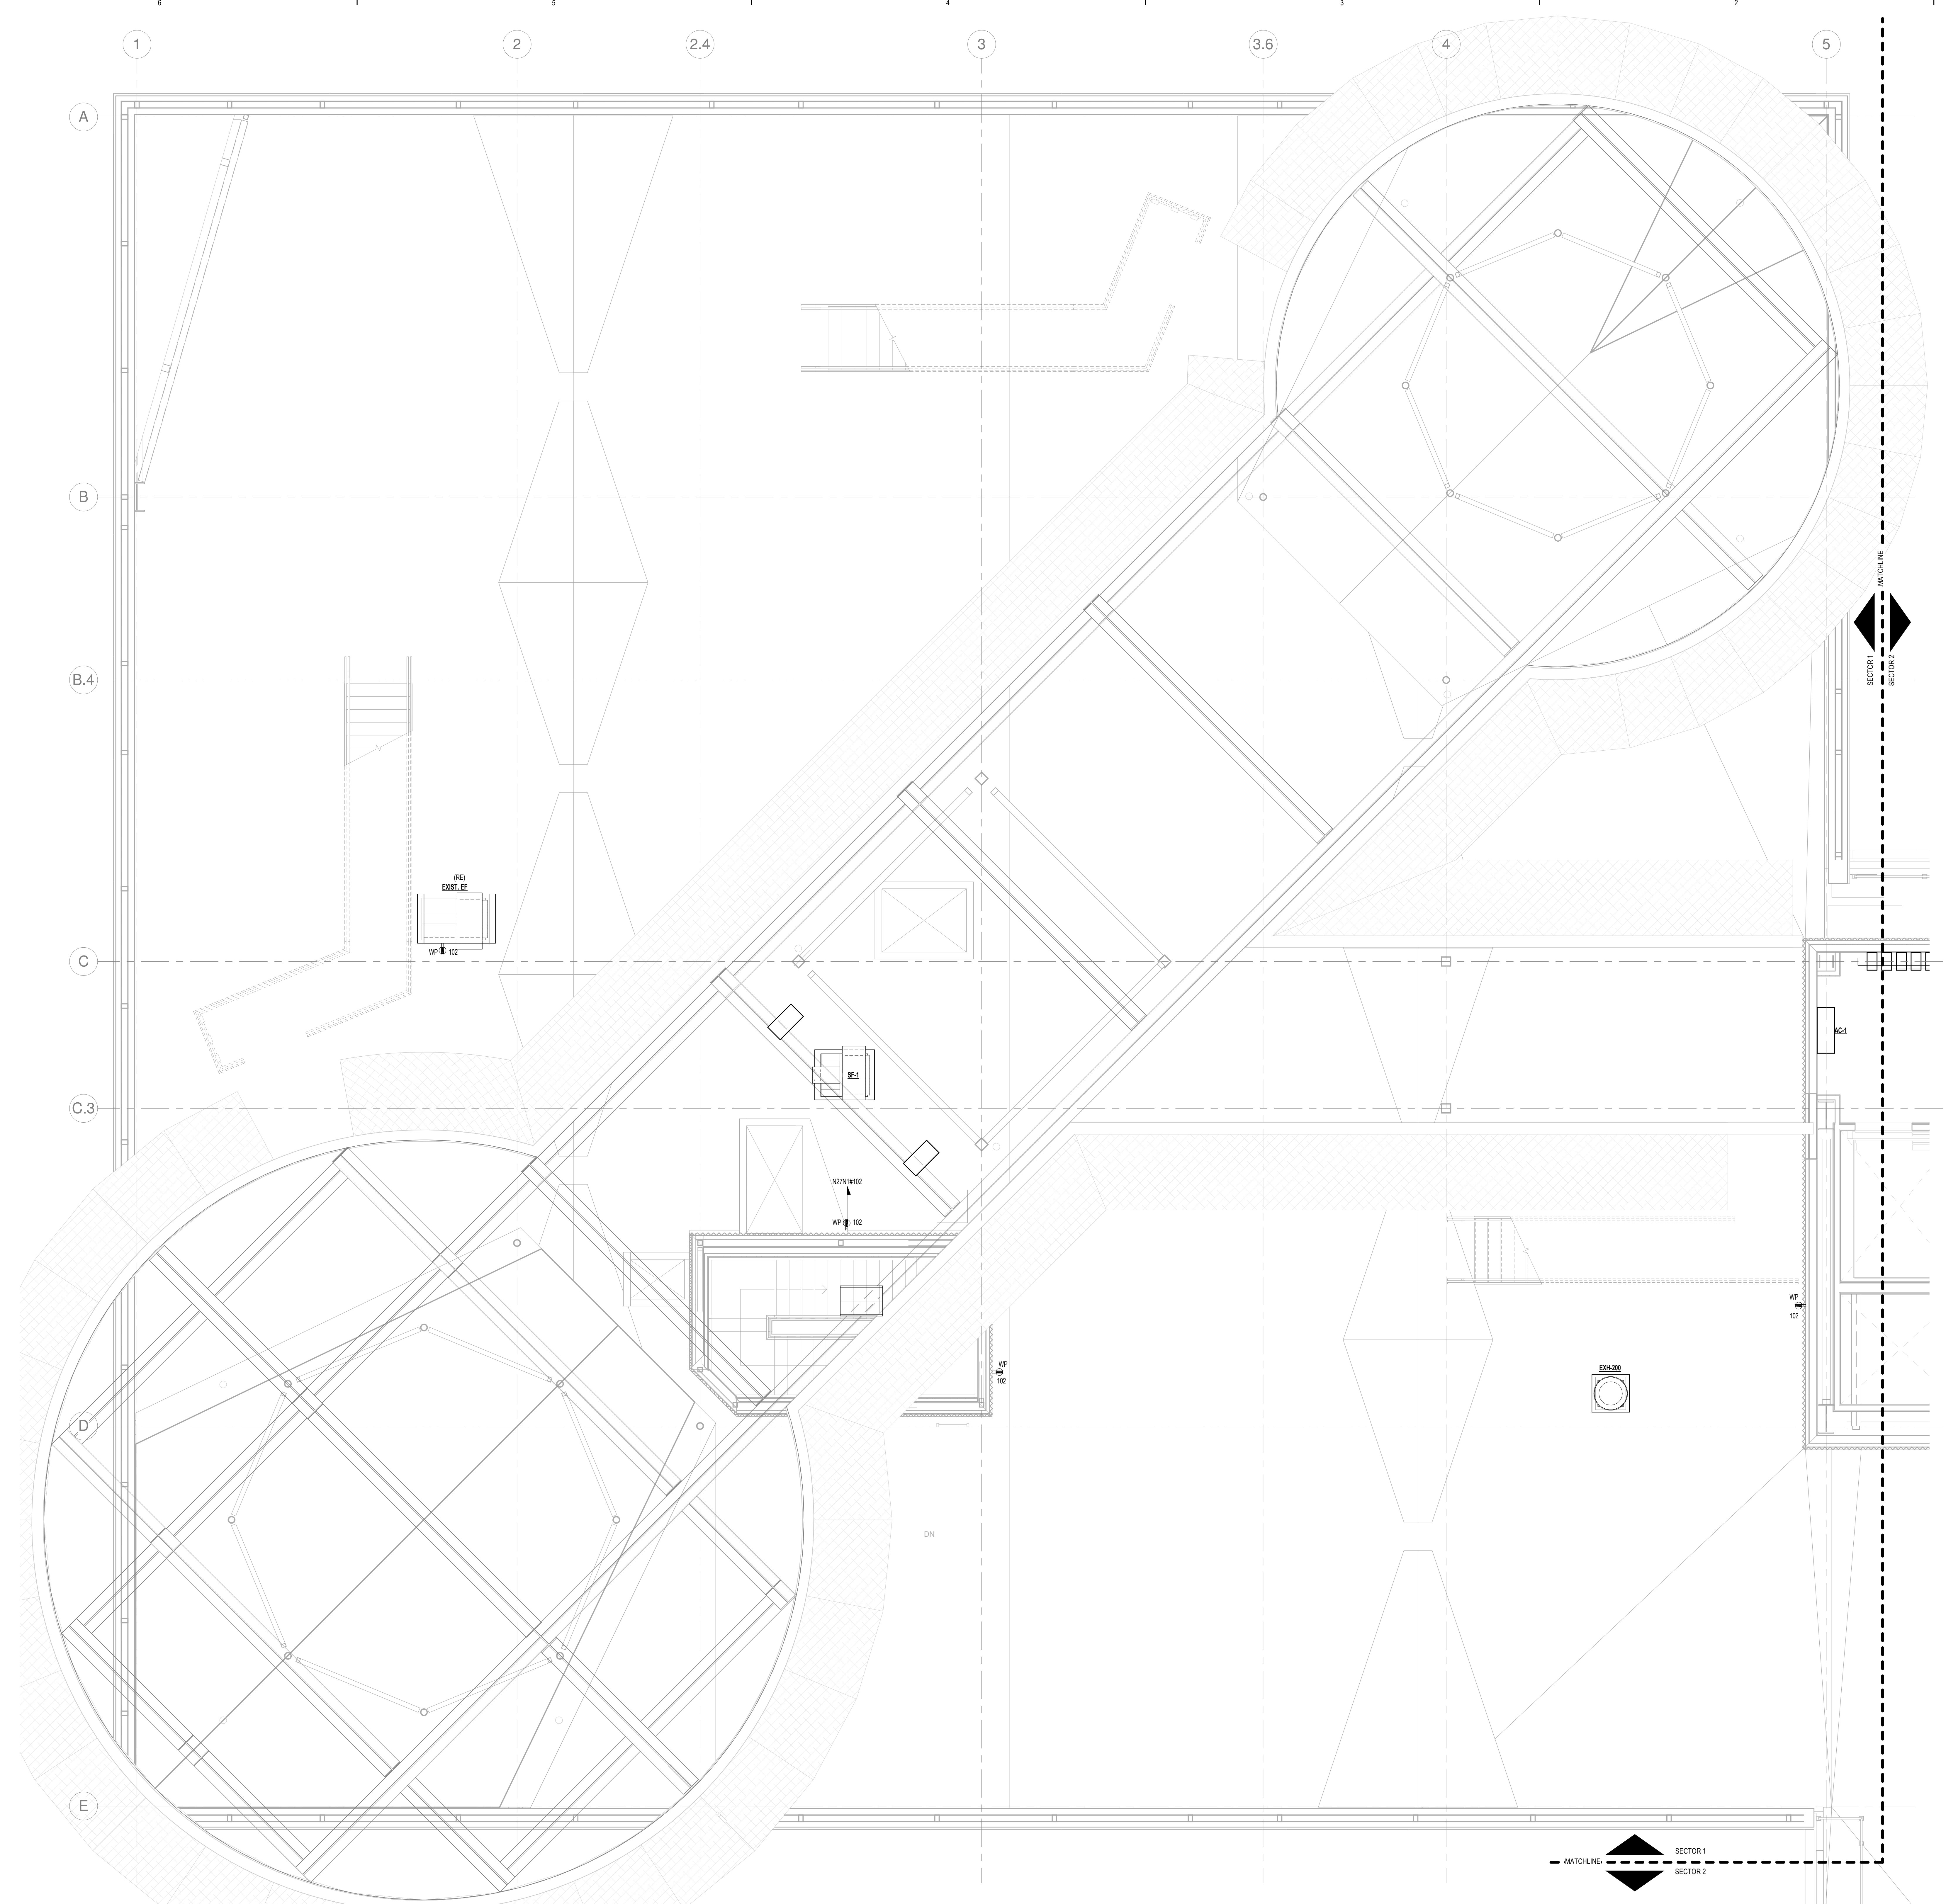

**1 ROOF - SECTOR 1**  
SCALE: 1/4" = 1'-0"

3/23/2018 11:19:25 AM  
C:\Revit Local Files\_B150312\000\MMC East Tower 6&7 MEP17\_Constral\_construction.rvt