


ADDENDUM NO.	1	03/22/18
NO.	ISSUE	DATE
Job Number	B15012-000	
Drawn	MAS	MAS
Checked	MFR	MFR
Approved	MFR	MFR

DRAWING NOTES - SIXTH FLOOR:

- REFER TO DRAWING E00-01 FOR ELECTRICAL SYMBOLS, NOTES AND ABBREVIATIONS.
- REFER TO DRAWINGS E00-11 AND E00-13 FOR LIGHTING FIXTURE SCHEDULE.
- ALL 277V NORMAL LIGHTING SHALL BE CIRCUITED TO THE 07480V PANELBOARDS AS INDICATED ON THE FLOOR PLANS.
- ALL LIGHT FIXTURES DESIGNATED AS EM AND EXIT SIGNS SHALL BE CONNECTED TO THE EMERGENCY LIGHTING CIRCUIT VIA THE LIFE SAFETY PANELBOARDS AS INDICATED ON THE FLOOR PLANS.
- ALL LIGHT FIXTURES DESIGNATED AS CR SHALL BE CONNECTED TO THE CRITICAL BRANCH LIGHTING CIRCUIT VIA THE CRITICAL PANELBOARDS AS INDICATED ON THE FLOOR PLANS.
- ALL OCCUPANCY SENSORS WITHIN THE FOLLOWING ROOM TYPES SHALL BE SPECIFIED WITH MANUAL ON/AUTOMATIC OFF MODE ENABLED PER ICC 2015. IN AREAS WHERE CEILING OCCUPANCY SENSORS ARE SPECIFIED WITH THIS MODE ENABLED MOMENTARY CONTACT SWITCHES SHALL BE UTILIZED FOR MANUAL CONTROLS IN LIEU OF TOGGLE SWITCHES.
 - CLASSROOMS/LECTURE/TRAINING ROOMS
 - CONFERENCE/MEETING/TUTORIAL ROOMS
 - COPY/PRINT ROOMS
 - EMPLOYEE LUNCH AND BREAK ROOMS
 - PRIVATE OFFICES
 - STORAGE ROOMS
 - ANTENNA/CLOSETS
 - LOCKER ROOMS
 - SPACES 300 SQUARE FEET OR LESS THAT ARE ENCLOSED BY FLOOR-TO-CEILING HEIGHT PARTITIONS.
- NUMERAL ADJACENT TO THE LIGHTING FIXTURE DENOTES CIRCUIT NUMBER. SUBSCRIPT LETTER WHERE SHOWN DENOTES SWITCH CONTROL. MINIMUM BRANCH CIRCUIT WIRING TO BE 30FT WITH THE ISOLATED GROUND INSTALLED CONCEALED. REFER TO ELECTRICAL SPECIFICATIONS FOR WIRING METHODS.
- ALL DIMMER SWITCHES TO BE LABELED STATING WHICH AREAS AND LIGHTS EACH DIMMER CONTROLS.

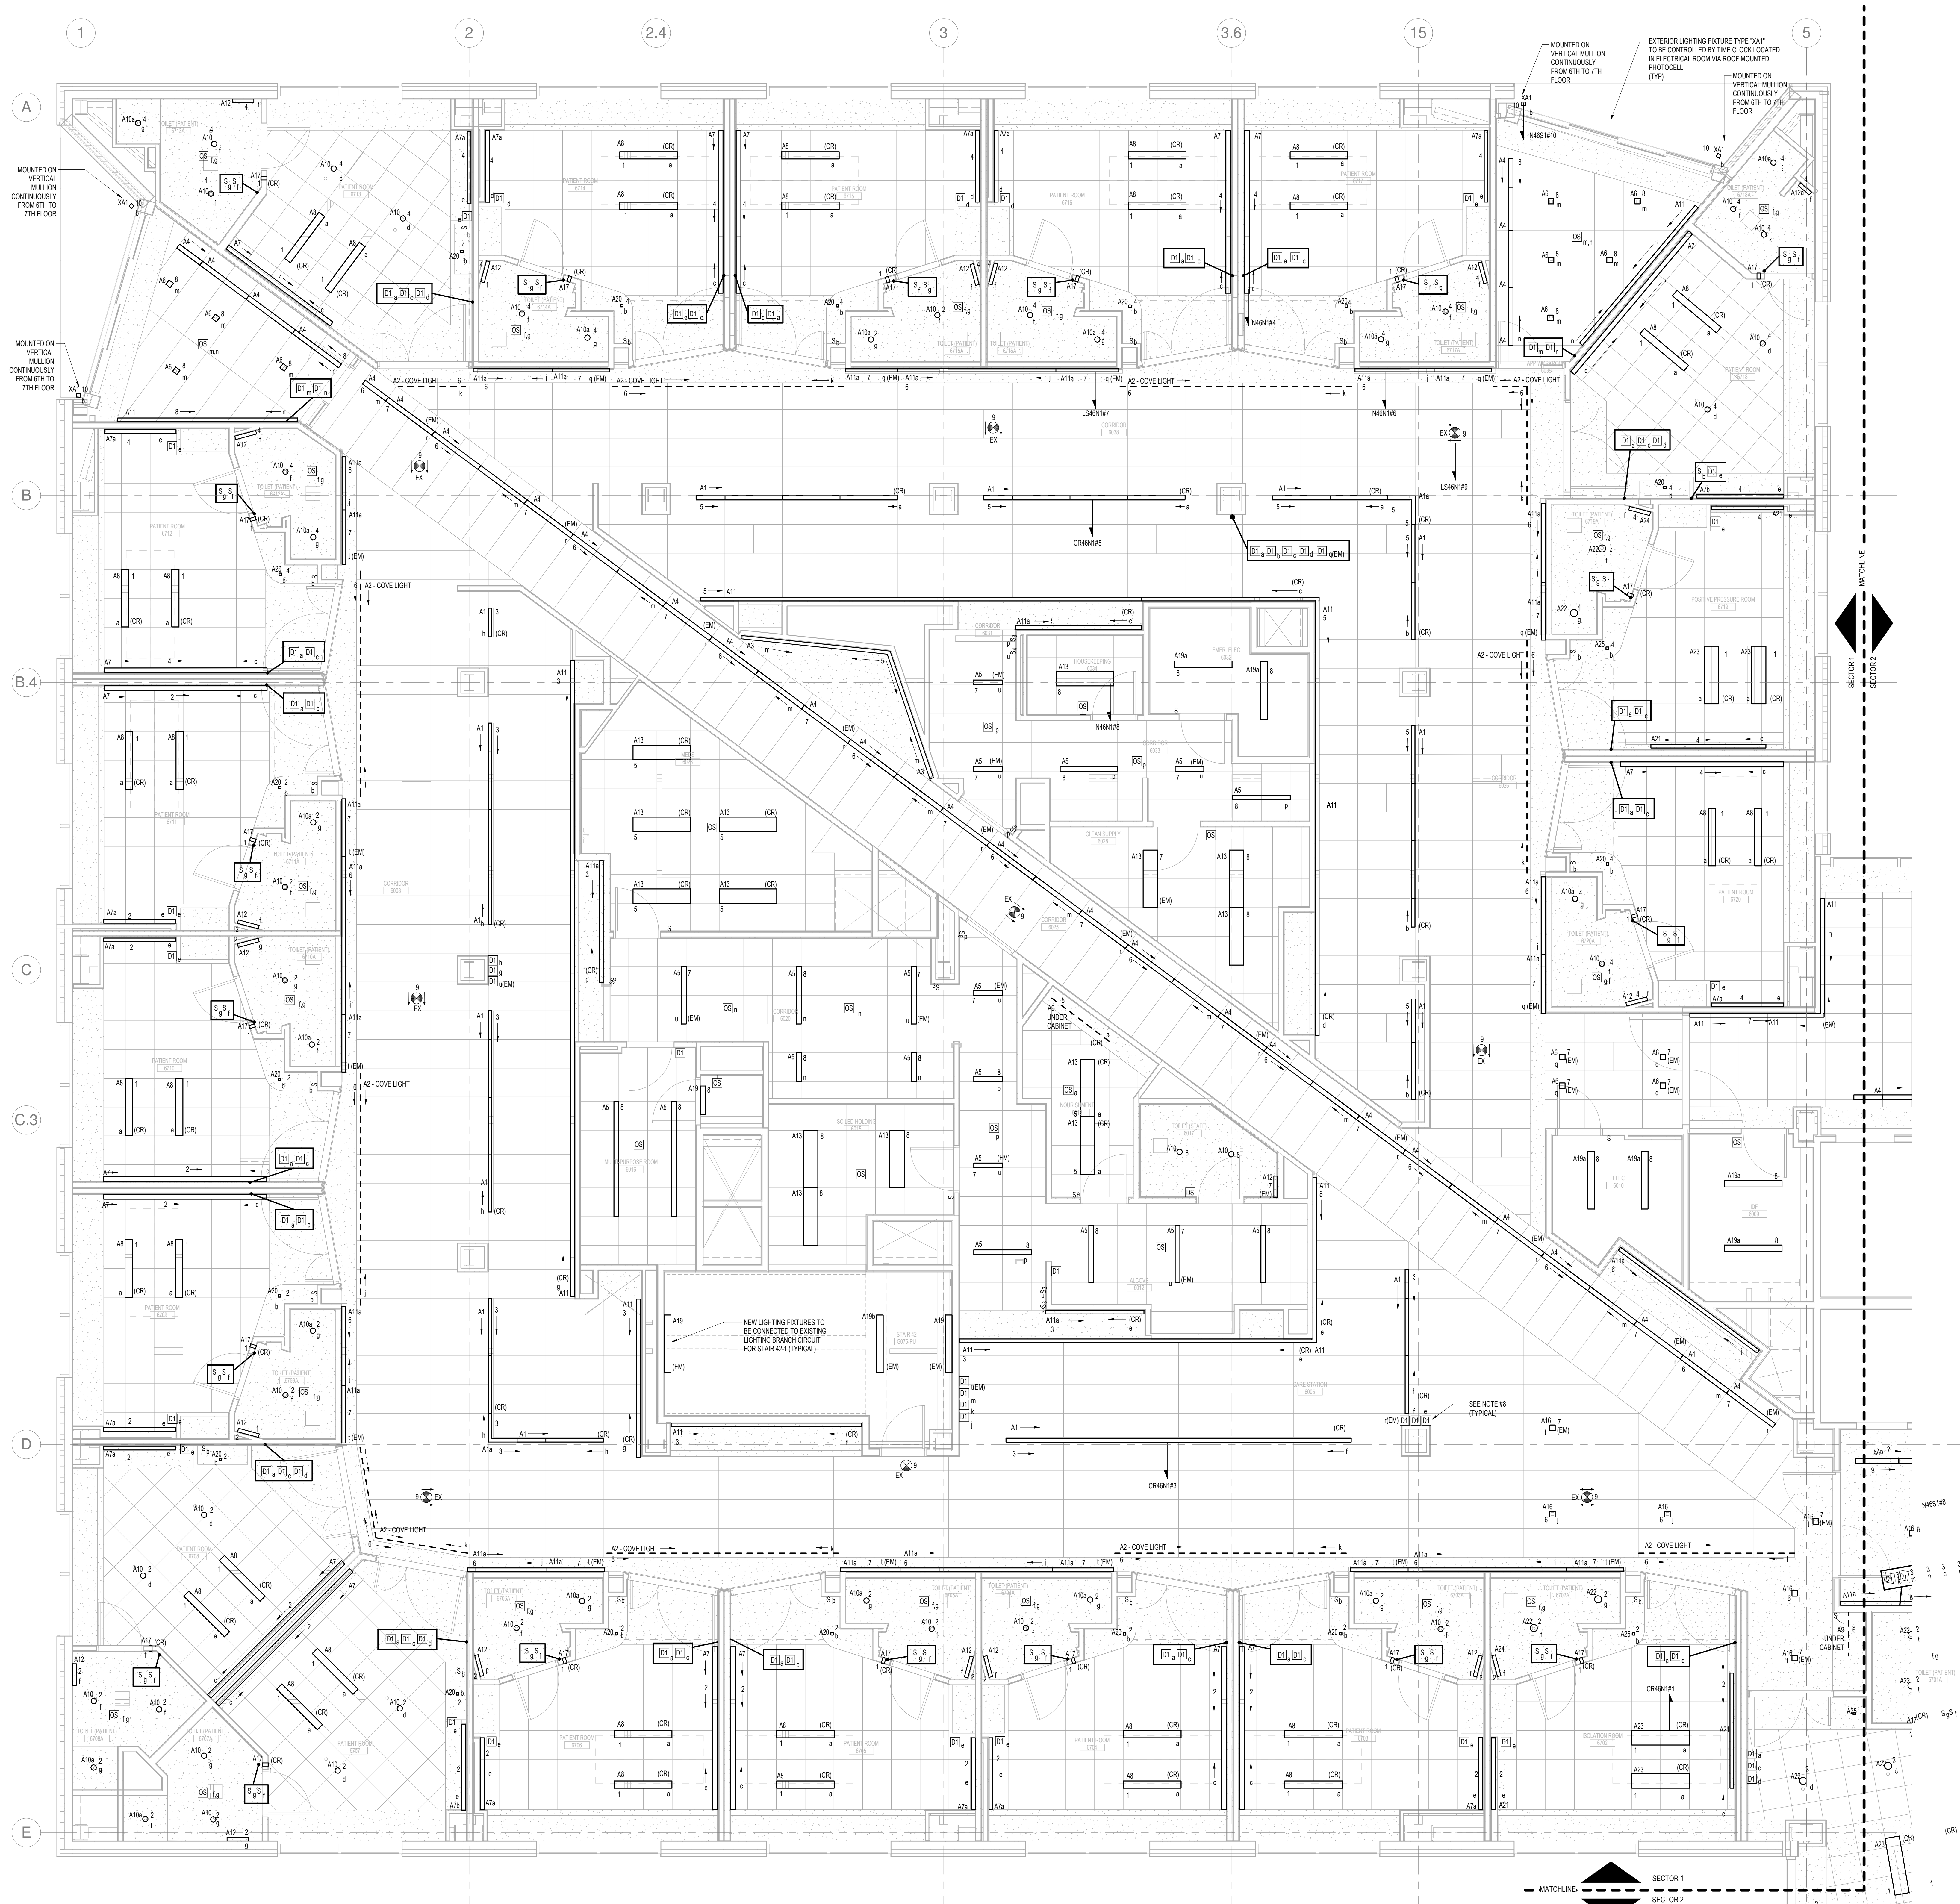

LEVEL 6 - SECTOR 1
SCALE: 1/4" = 1'-0"

3/23/2018 11:10:26 AM
 C:\Revit Local Files_B15012\000\MDC East Tower 6&7 MEP\17_Constr...