


ADDENDUM NO.	DATE
1	03/22/18

NO.	ISSUE	DATE

Job Number: B150312-000
Drawn: MMS
Checked: MFR
Approved: MFR

- DRAWING NOTES - SEVENTH FLOOR:**
- REFER TO DRAWING E00-01 FOR ELECTRICAL SYMBOLS, NOTES AND ABBREVIATIONS.
 - REFER TO DRAWINGS E00-11 AND E00-13 FOR LIGHTING FIXTURE SCHEDULE.
 - ALL 277V NORMAL LIGHTING SHALL BE CIRCUITED TO THE 277V/480V PANELBOARDS AS INDICATED ON THE FLOOR PLANS.
 - ALL LIGHT FIXTURES DESIGNATED AS EM AND EXIT SIGNS SHALL BE CONNECTED TO THE EMERGENCY LIGHTING CIRCUIT VIA THE LIFE SAFETY PANELBOARDS AS INDICATED ON THE FLOOR PLANS.
 - ALL LIGHT FIXTURES DESIGNATED AS ICR SHALL BE CONNECTED TO THE CRITICAL BRANCH LIGHTING CIRCUIT ON THE CRITICAL PANELBOARDS AS INDICATED ON THE FLOOR PLANS.
 - ALL OCCUPANCY SENSORS WITHIN THE FOLLOWING ROOM TYPES SHALL BE SPECIFIED WITH MANUAL ON/AUTOMATIC/OFF MODE ENABLED PER ICC 2015. IN AREAS WHERE CEILING OCCUPANCY SENSORS ARE SPECIFIED WITH THIS MODE ENABLED MOMENTARY CONTACT SWITCHES SHALL BE UTILIZED FOR MANUAL CONTROLS IN LIEU OF TOGGLE SWITCHES.
 - CLASSROOMS/LECTURE/TRAINING ROOMS
 - CONFERENCE/MEETING/PROSESSOR ROOMS
 - COPY PRINT ROOMS
 - EMPLOYEE LUNCH AND BREAK ROOMS
 - PRIVATE OFFICES
 - STORAGE ROOMS
 - ANTHROPOMETRIC ROOMS
 - LOCKER ROOMS
 - SPACES 300 SQUARE FEET OR LESS THAT ARE ENCLOSED BY FLOOR-TO-CEILING HEIGHT PARTITIONS.
 THE FOLLOWING ROOM TYPES ARE EXEMPT FROM THIS REQUIREMENT:
 - PUBLIC CORRIDORS
 - STAIRWAYS
 - RESTROOMS
 - PRIMARY BUILDING ENTRANCE AREAS AND LOBBIES
 - AREAS WHERE MANUAL OPERATION WOULD ENDANGER THE SAFETY OR SECURITY OF THE ROOM OR BUILDING OCCUPANTS
 - NUMERAL ADJACENT TO THE LIGHTING FIXTURE DENOTES CIRCUIT NUMBER, SUBSCRIPT LETTER WHERE SHOWN DENOTES SWITCH CONTROL, MINIMUM BRANCH CIRCUIT WIRING TO BE 30FT WITH THE INSULATED GROUND INSTALLED CONCEALED. REFER TO ELECTRICAL SPECIFICATIONS FOR WIRING METHODS.
 - ALL DIMMER SWITCHES TO BE LABELED STATING WHICH AREAS AND LIGHTS EACH DIMMER CONTROLS.

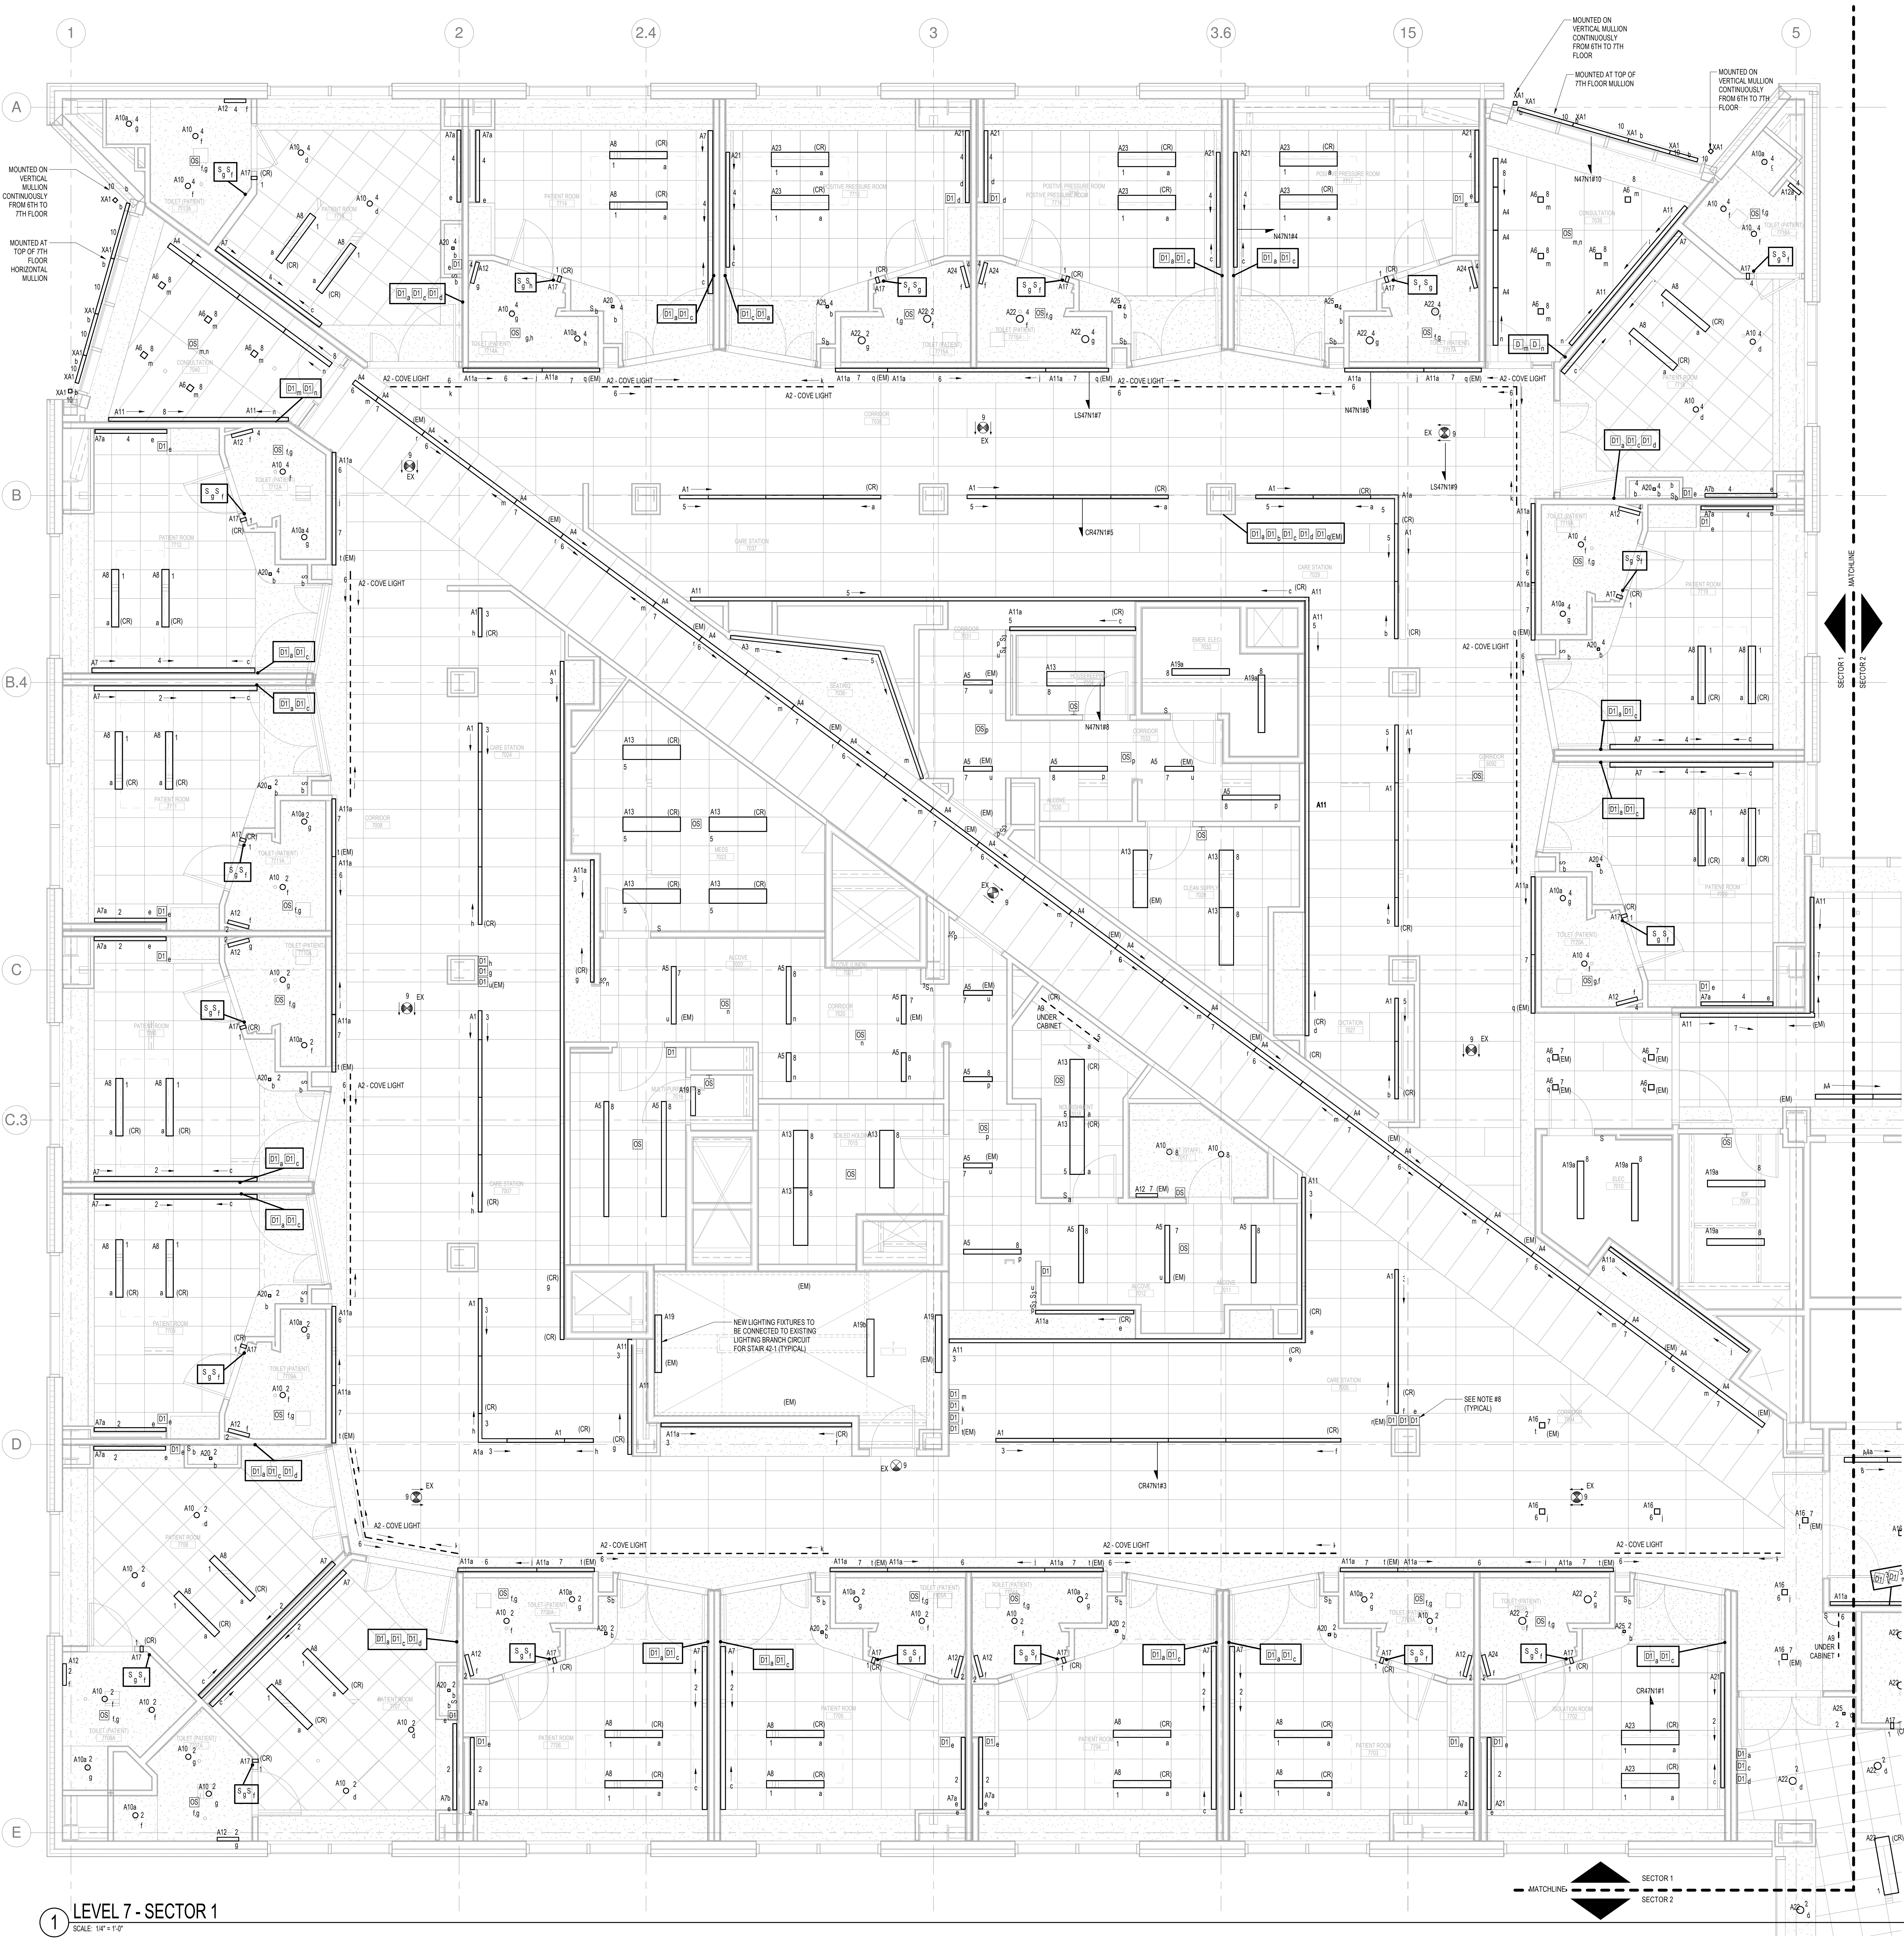

LEVEL 7 - SECTOR 1
SCALE: 1/4" = 1'-0"