


NO.	ISSUE	DATE
Job Number	B150312-000	
Drawn	MMS	
Checked	MFR	
Approved	MFR	

- DRAWING NOTES - PENTHOUSE:**
- REFER TO DRAWINGS E00-01 FOR ELECTRICAL SYMBOLS, NOTES AND ABBREVIATIONS.
 - REFER TO DRAWINGS E00-11 AND E00-13 FOR LIGHTING FIXTURE SCHEDULE.
 - ALL 277V NORMAL LIGHTING SHALL BE CIRCUITED TO THE 277V/480V PANELBOARDS AS INDICATED ON THE FLOOR PLANS.
 - ALL LIGHT FIXTURES DESIGNATED AS IEM AND EXIT SIGNS SHALL BE CONNECTED TO THE LINE SWITCHED EMERGENCY LIGHTING CIRCUIT VIA THE LIFE SAFETY PANELBOARDS AS INDICATED ON THE FLOOR PLANS.
 - ALL LIGHT FIXTURES DESIGNATED AS ICR SHALL BE CONNECTED TO THE CRITICAL BRANCH LIGHTING CIRCUIT VIA THE CRITICAL PANELBOARDS AS INDICATED ON THE FLOOR PLANS.
 - NUMERAL ADJACENT TO THE LIGHTING FIXTURE DENOTES CIRCUIT NUMBER. SUFFIX LETTER WHERE SHOWN DENOTES SWITCH CONTROL. MINIMUM BRANCH CIRCUIT WIRING TO BE 2#12 WITH #12 INSULATED GROUND INSTALLED CONCEALED. REFER TO ELECTRICAL SPECIFICATIONS FOR WIRING METHODS.

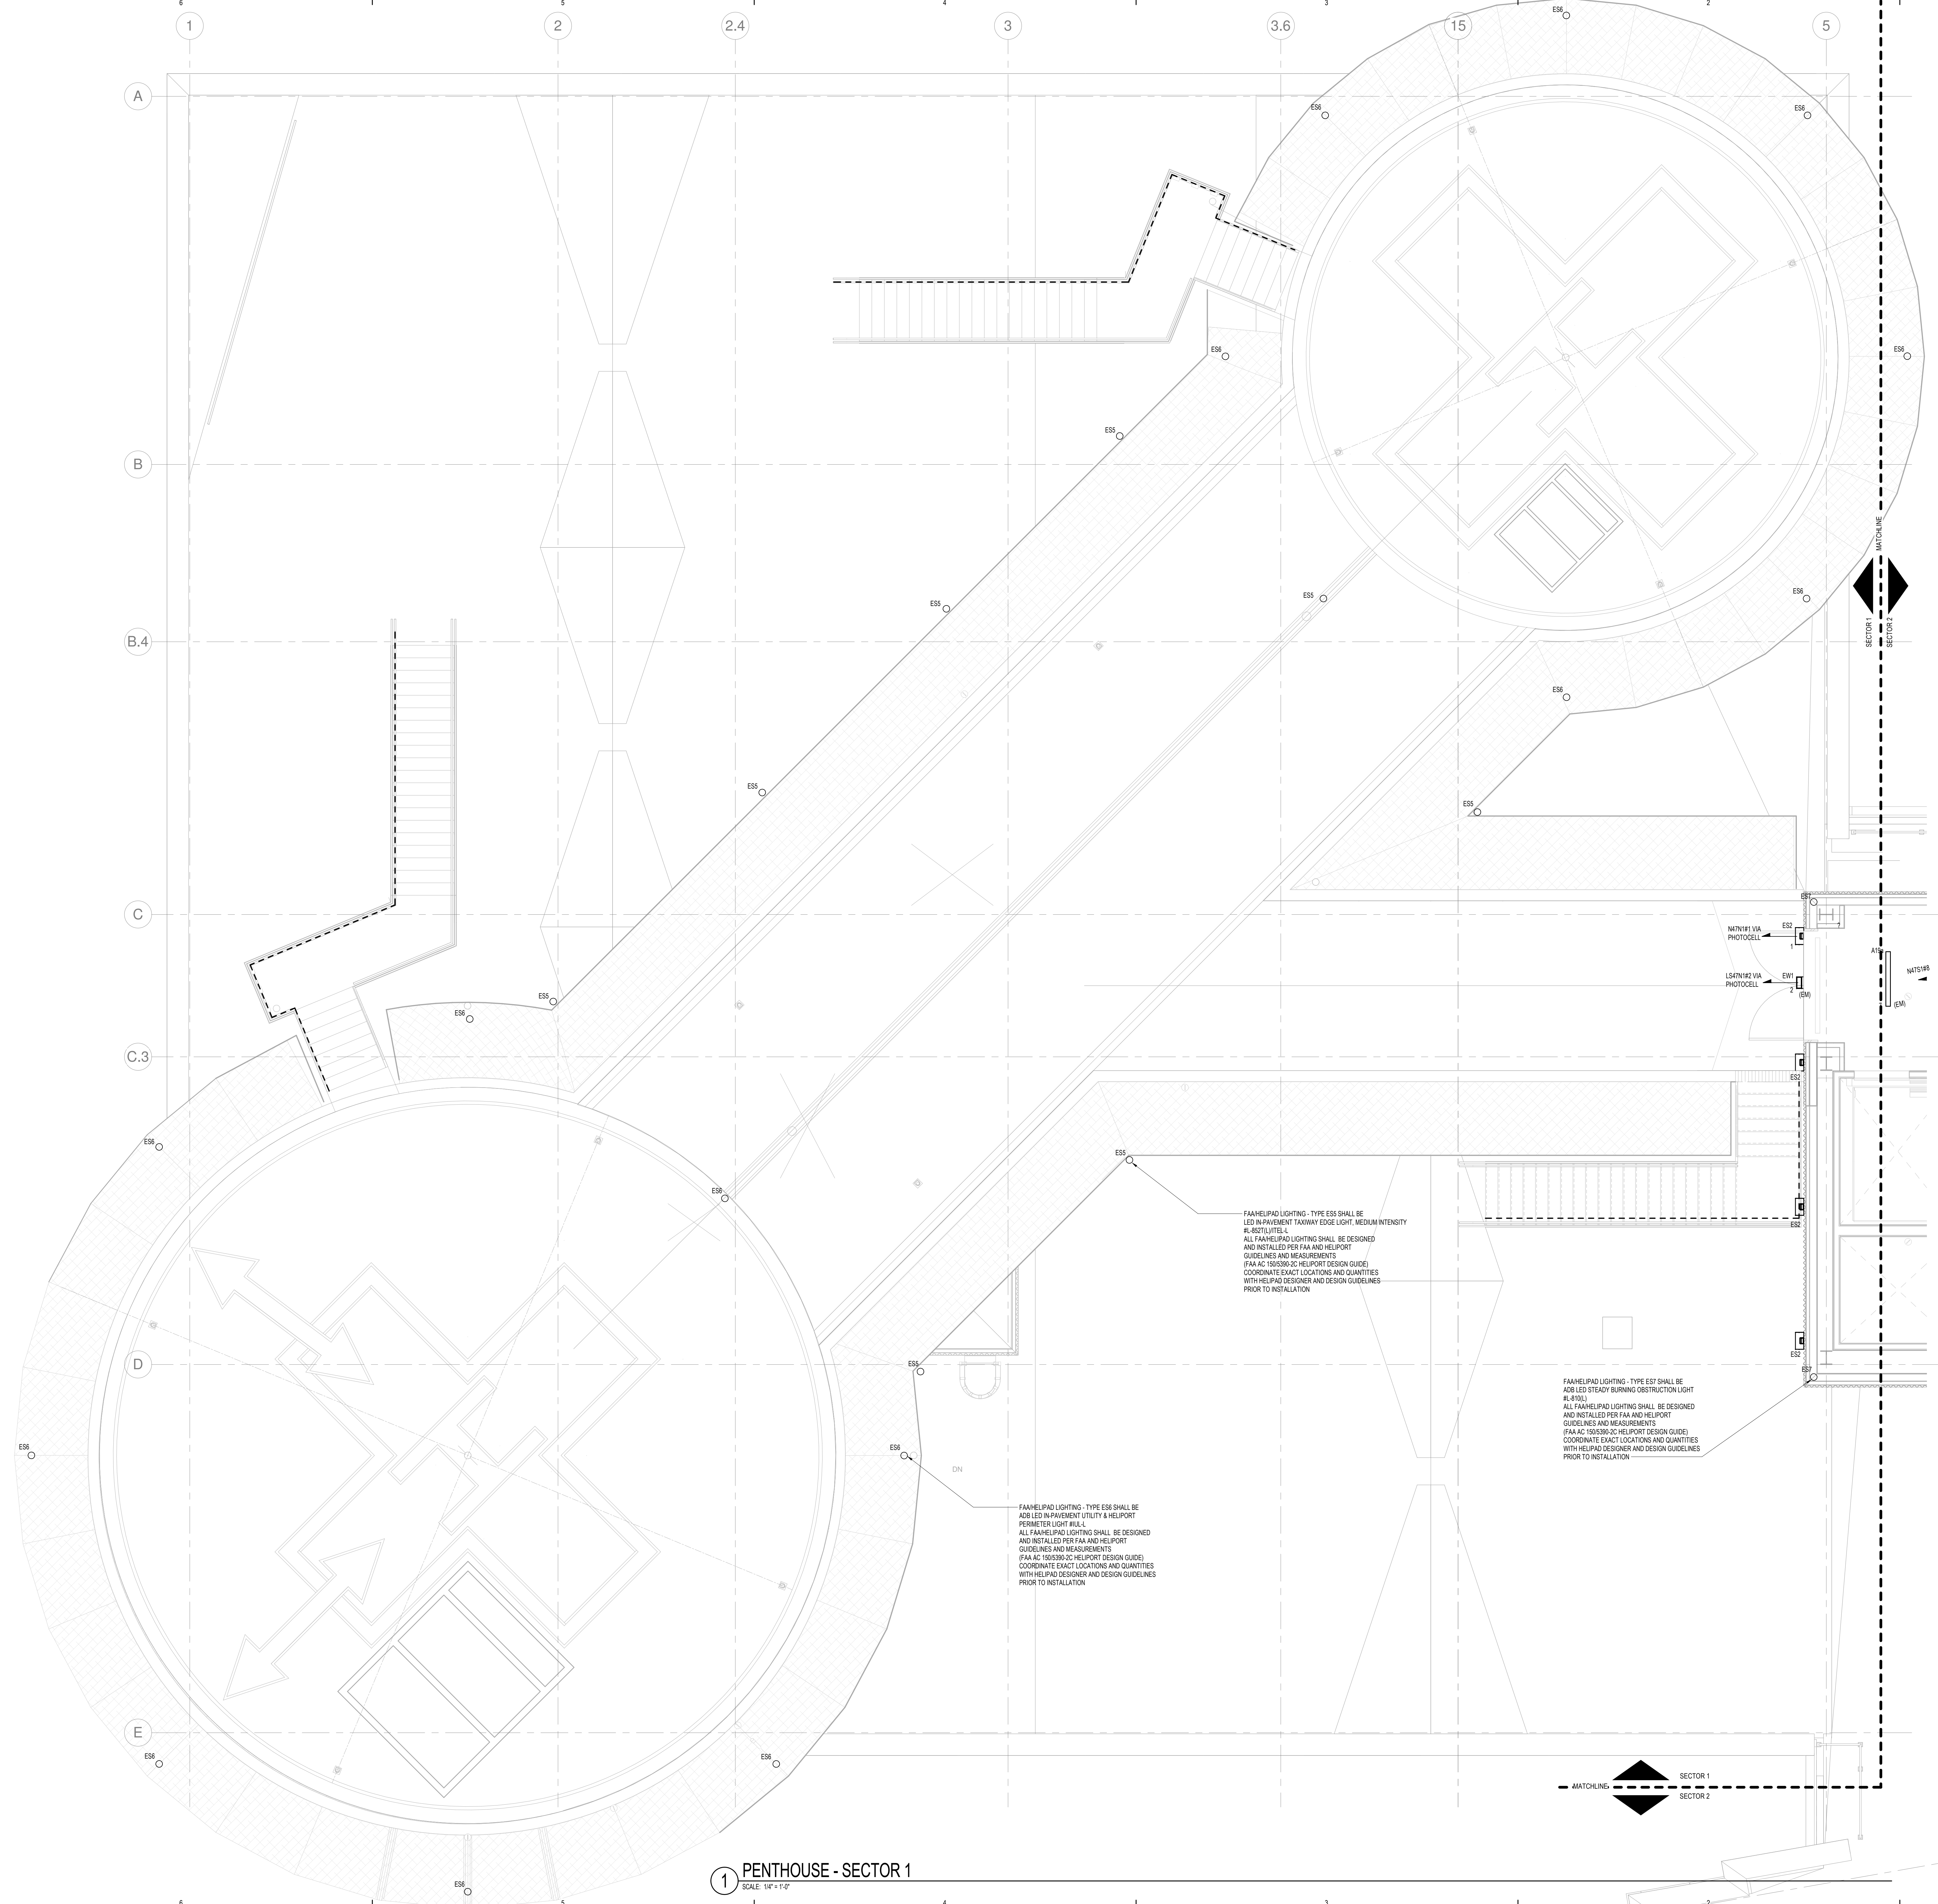

1 PENTHOUSE - SECTOR 1
SCALE: 1/4" = 1'-0"

