

CONSULTANTS

CIVIL / LANDSCAPE ARCHITECT  
**Sebago Technics**  
75 John Roberts Road, Suite  
1A, South Portland, ME 04106

STRUCTURAL ENGR: BUILDING ENVELOPE CONSULTANT  
**Simpson Gumpertz & Hager Inc.**  
41 Seay Street, Building 1, Suite 501,  
Waltham, MA 02453

MEP/ELECTRICAL ENGINEER: CODE  
**AKF Group LLC**  
99 Bedford Street, 2nd Floor, Boston MA 02111

CONSTRUCTION MANAGER  
**Turner Construction**  
2 Seaport Lane, Suite 200, Boston, MA 02210


ELEVATOR CONSULTANT  
**VDA (Van Deusen & Associates)**  
101 Summer Street, 4th Floor, Boston MA  
02110

COST ESTIMATOR  
**D. G. Jones International**  
3 Baldwin Green Common, Suite 202, Woburn, MA 01801

PROJECT TITLE

**East Tower 6 & 7  
Addition**  
22 Bramhall Street  
Portland, ME 04102

KEY PLANS

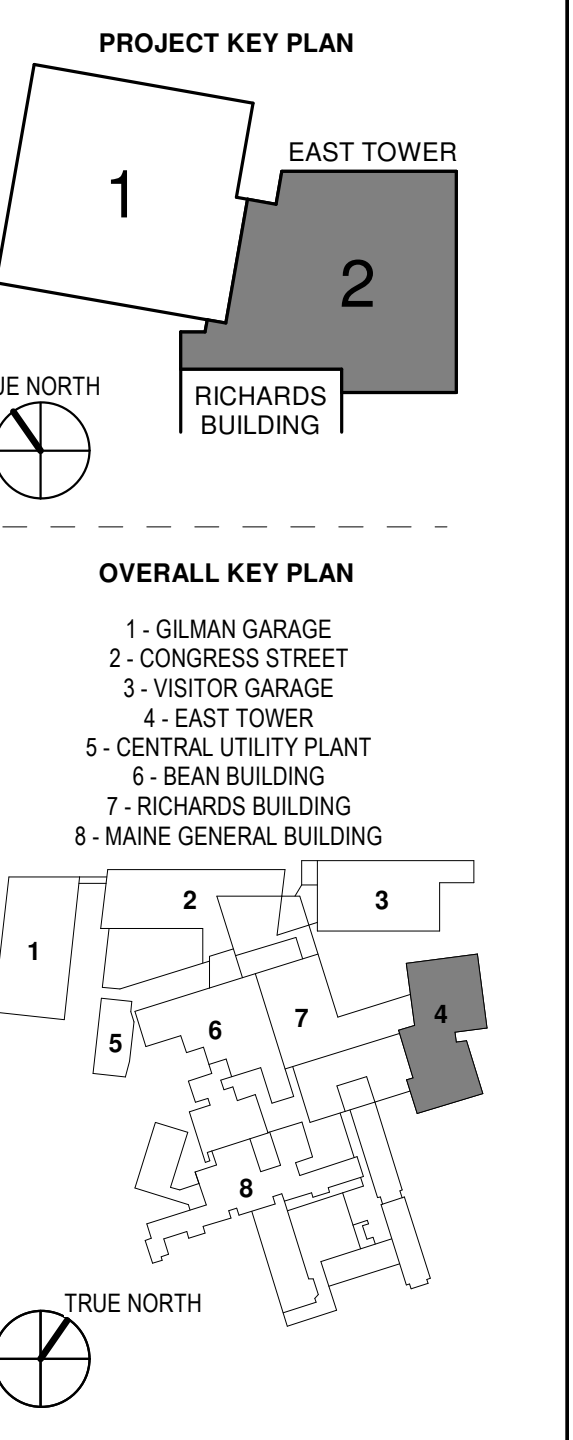


CONSTRUCTION DOCUMENTS  
JANUARY 28, 2018

ADDENDUM NO.	DATE
1	03/22/18
NO	ISSUE
Job Number	B150312-000
Drawn	NV
Checked	BN
Approved	BN

TITLE  
**SECURITY LEVEL 7  
FLOOR PLAN -  
SECTOR 2**

SHEET NUMBER

**SC11-72**

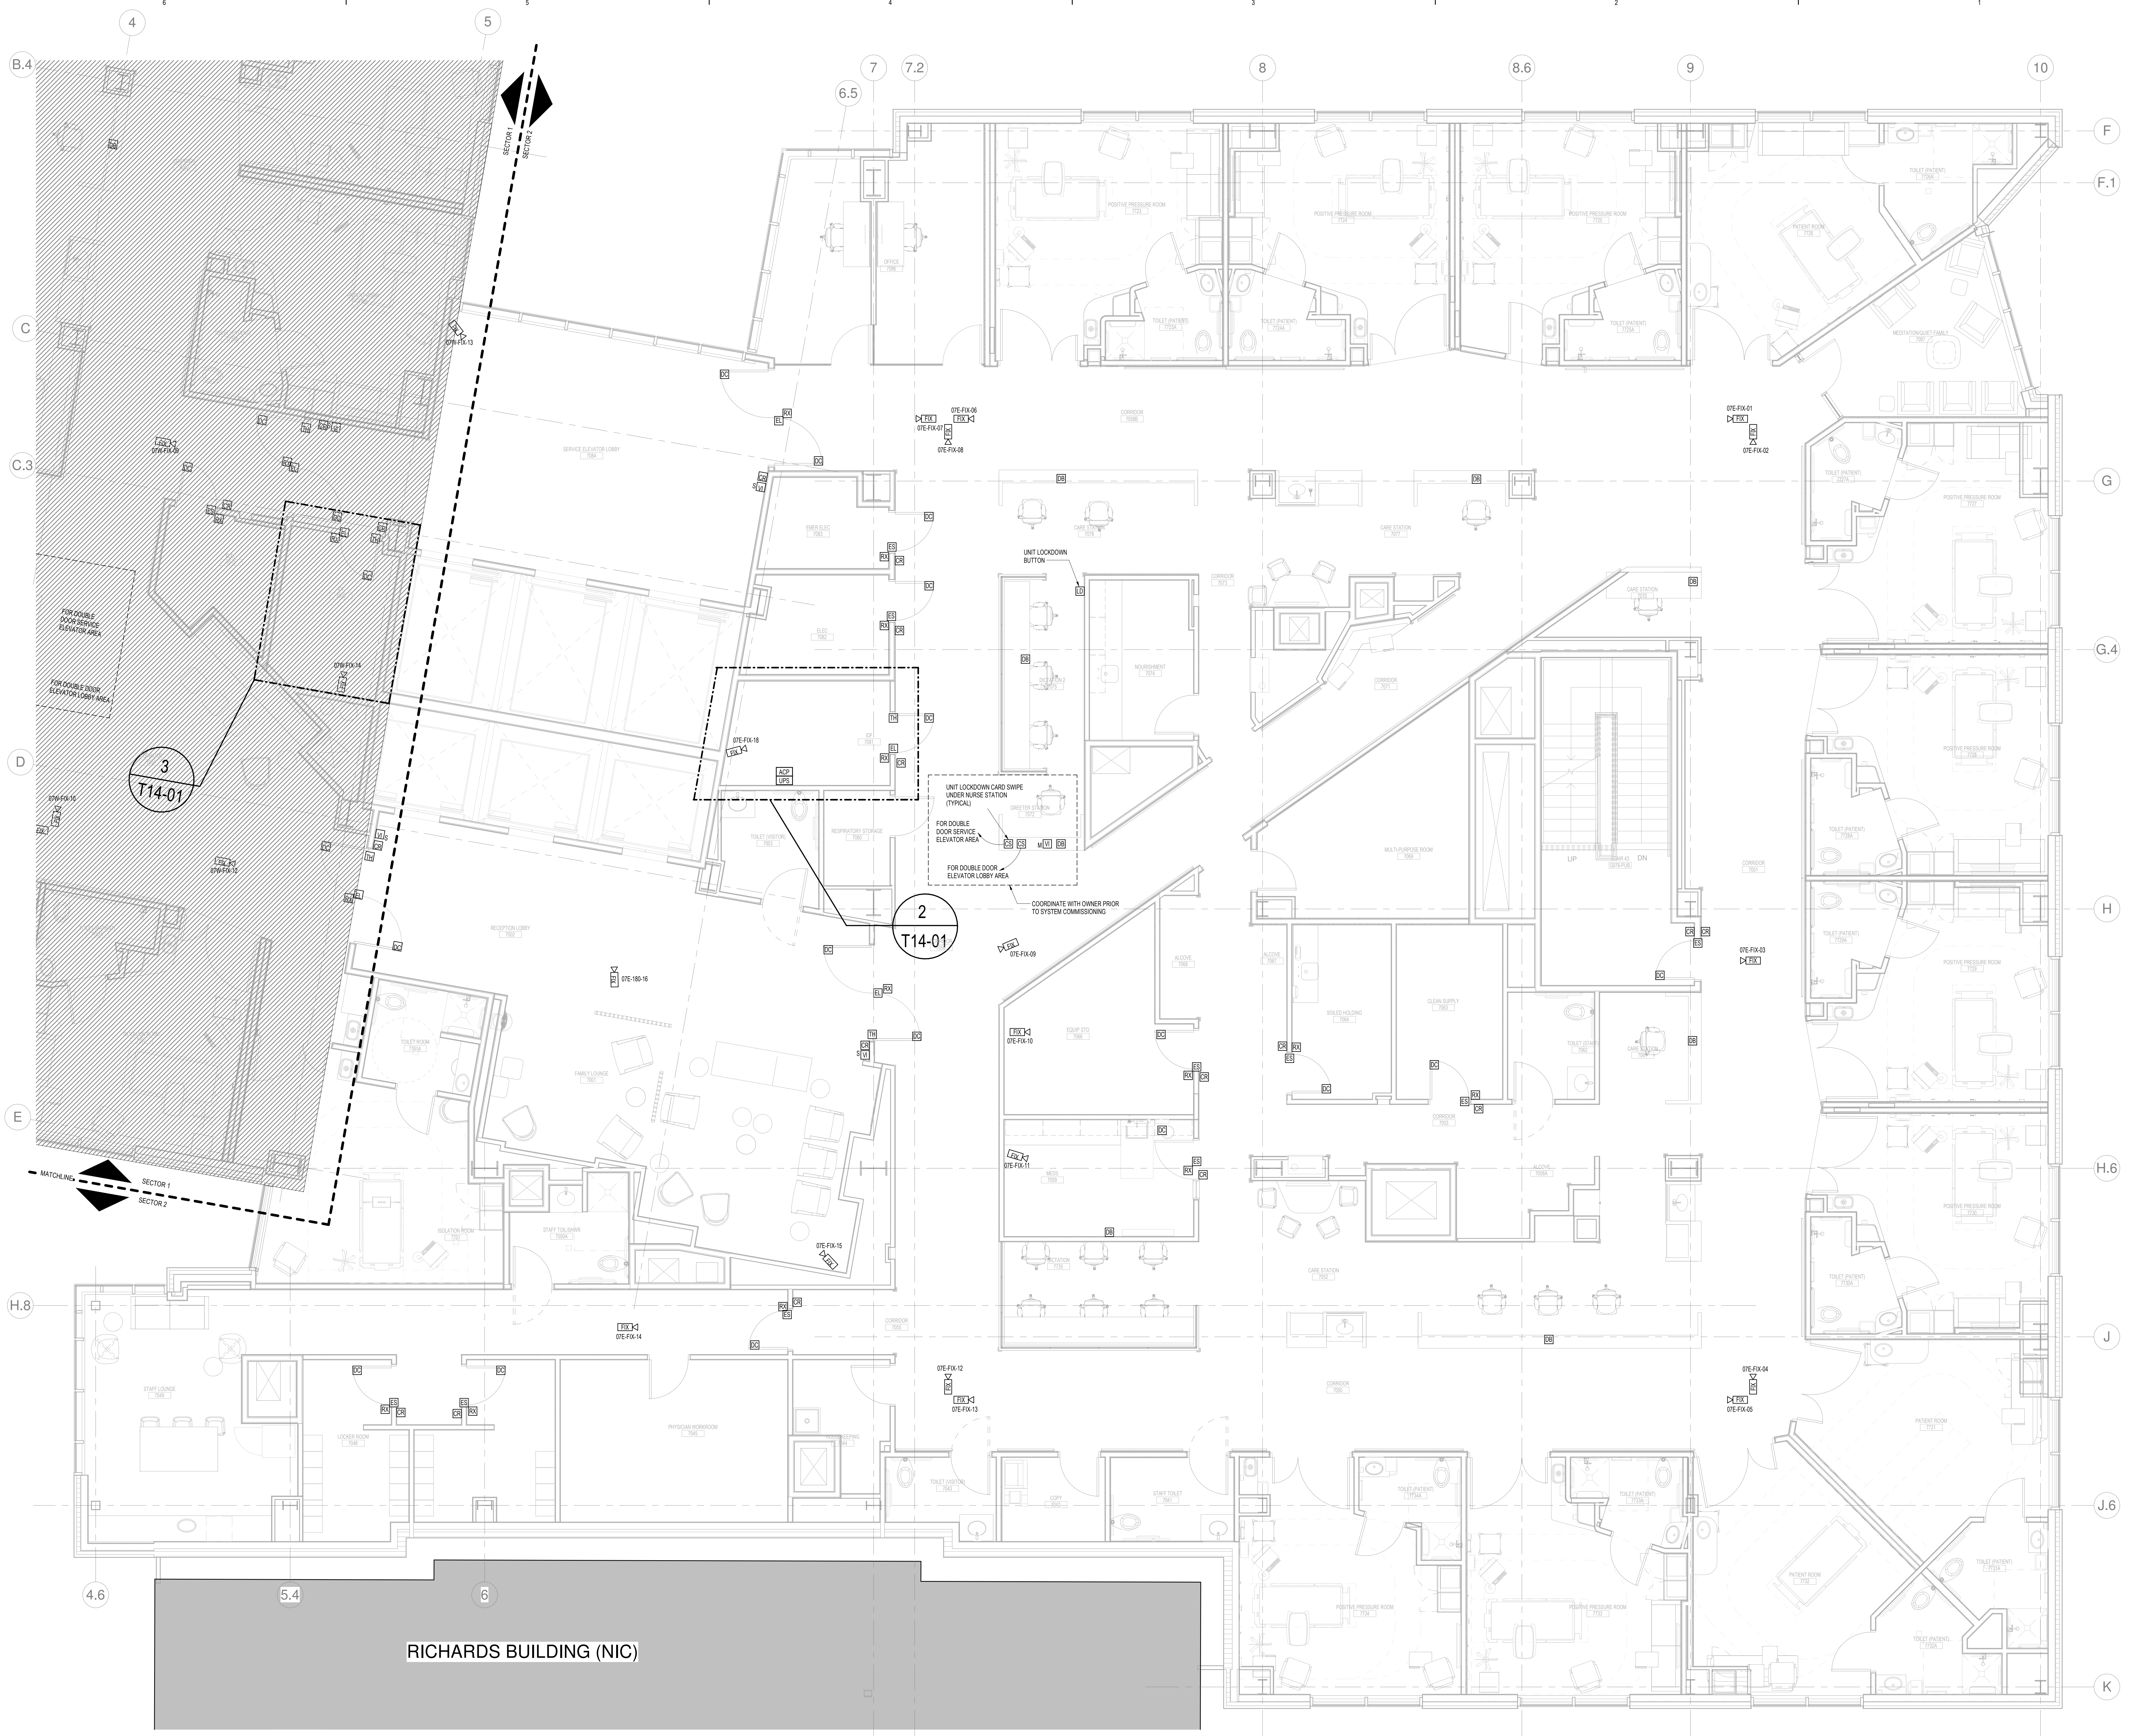

RICHARDS BUILDING (NIC)