
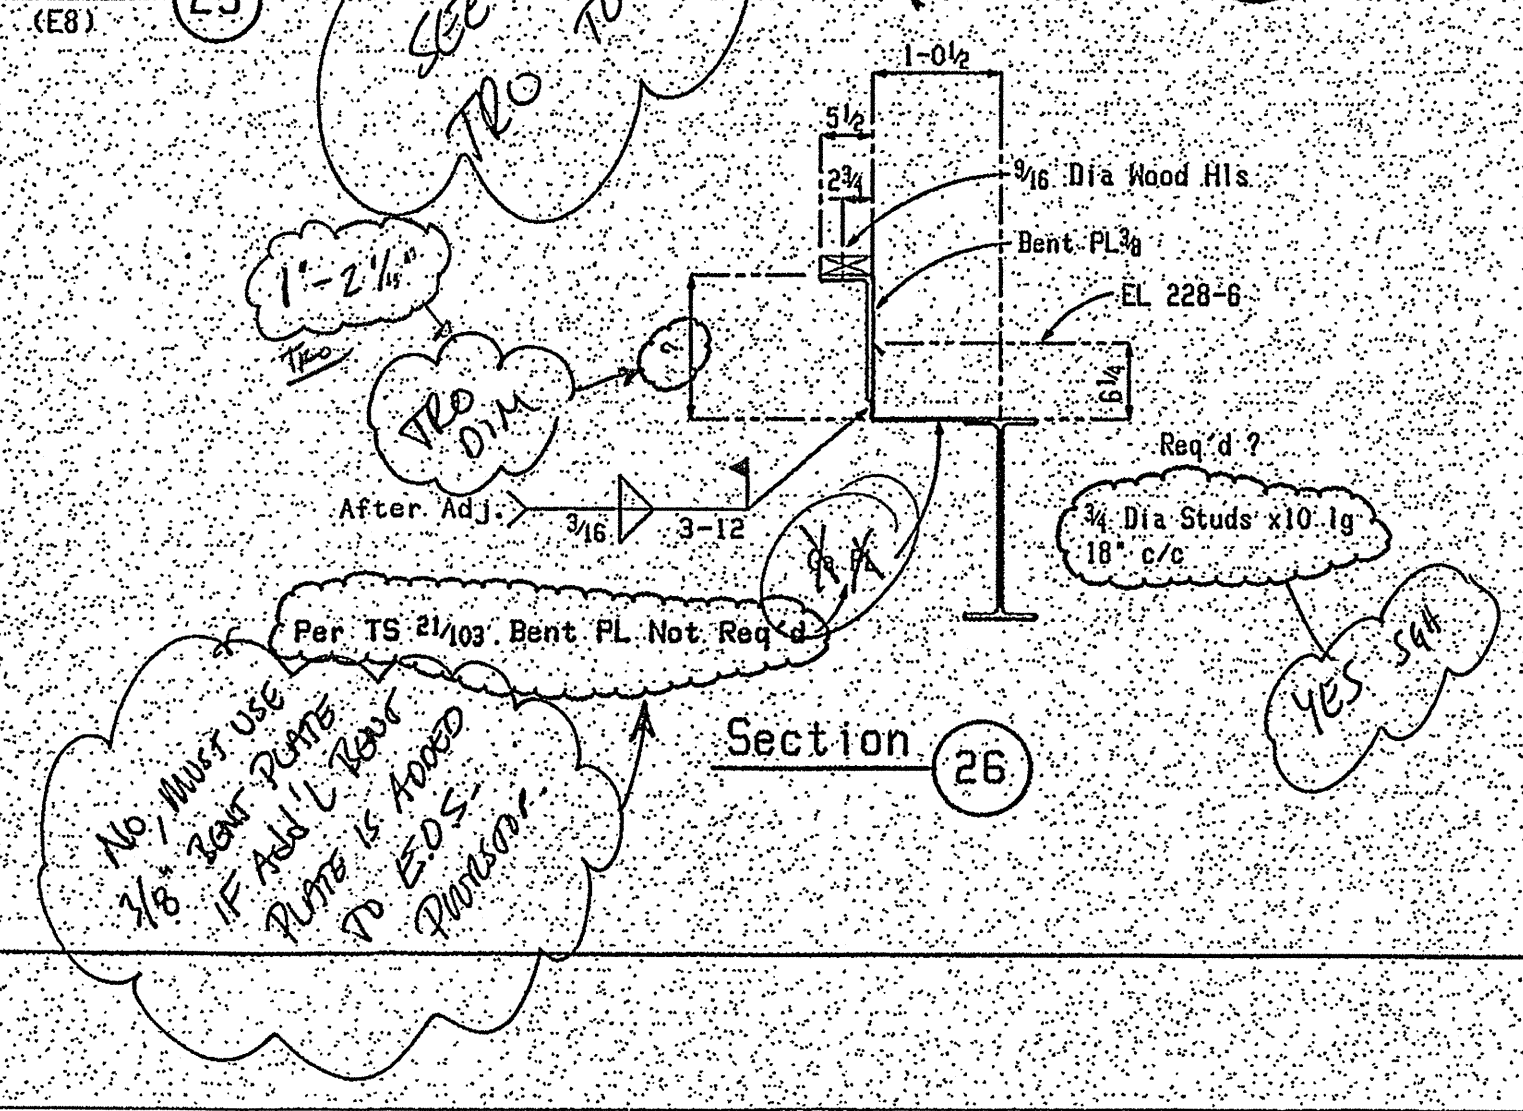
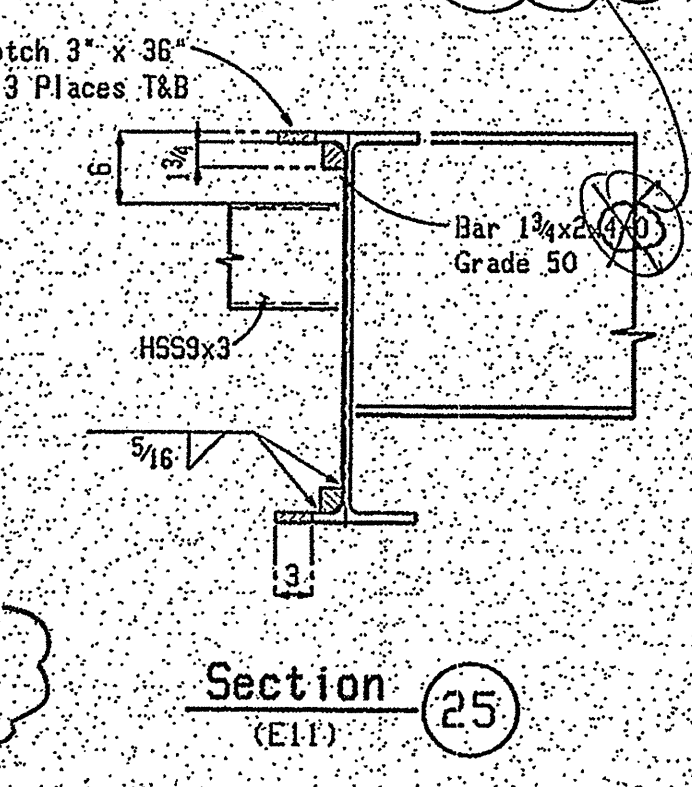


Additional Field Welding Relieving Angle Details

PPC RFI #33, SLEP-02  
3/16" EXTENSION (COUNT) FULL  
LENGTH OF BEAM ABOVE  
STOP 2' FROM FROM END  
END OF TIE BAR

SEE DETAIL F/ASLI  
TRO TO PROVIDE EXTENT ON ROOF PLAN E13

SEE NOTE ON E13  
TRO

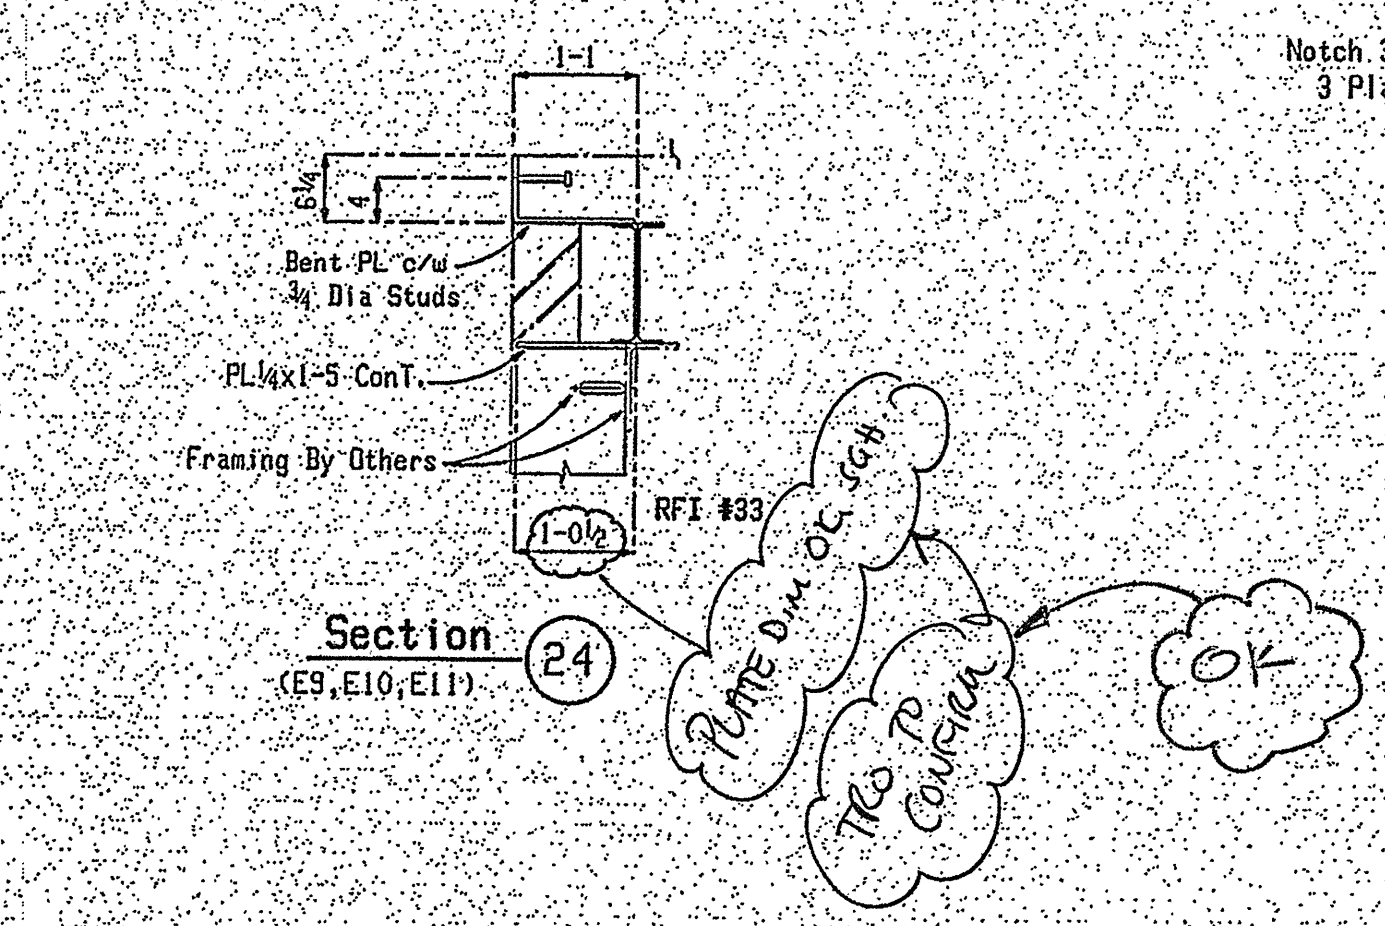

PPC RFI #33  
TRO TO CONFIRM  
OK

No. Must Use  
3/8" Rod Ropes  
Ropes is Moved  
TO E10  
Thinking

RECEIVED  
AUG 14 2006  
Simpson Gumpertz & Heger  
Consulting Engineers Inc.

WILLIAM A. BERRY & SON, INC.  
REVIEWED IN ACCORDANCE WITH  
THE CONTRACT DOCUMENTS.


BY: MBE DATE: 8-3-06  
JOB # 04-310-0 FOR NAME: MMC-CHKLES BY  
SUBMISSION # 017-001-2  
SPEC. CORRE. REF.  
REVIEWED FOR CONSTRUCTION

FOR APPROVAL  
JUL 31 2006  
TRO

Approved ( )  
Approved as Corrected ( )  
If checked above, fabrication MAY be undertaken. Approval does not authorize changes to Contract Sum unless stated in separate letter or Change Order.  
If checked below, fabrication MAY NOT be undertaken. Resubmit corrected copies for final approval. Correction shall be limited to items indicated:  
Revise and Resubmit ( )  
Not Approved ( )  
Reviewing is only for conformance with the information given in this Contract Documents. Contractor is responsible for dimensions, for information that pertains solely to the fabrication process or to the rigging, methods, techniques, sequences and procedures of construction, and for coordination of the work of all trades.  
THE NITCHE ORGANIZATION  
Date: 8/14/06 TRO

APPROVED  NOT APPROVED   
APPROVED AS CORRECTED   
REVISE AND RESUBMIT   
RESUBMIT FOR RECORD COPY

Checking is only for conformance with the design concept of the project and compliance with the information given in this Contract Documents. Contractor is responsible for dimensions to be confirmed and correlated at the job site. Do not make any settings solely by the fabrication process or to techniques of construction, and for coordination of the work of all trades.  
BY: MBE DATE: 7-29-06  
SIMPSON GUMPERTZ & HEGER INC.  
CONSULTING ENGINEERS  
41 SEASON ST., SUITE 600  
WALTHAM, MA 02453

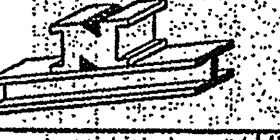Revisions			
No.	Date	Description	
1	31-07-06	UPDATED TO SUIT APPROVAL	
 <b>NOVEL IRON WORKS</b> 250 Ocean Road Greenland, NH 03840			
Project	Maine Medical Center	Hold	ASCC Certified Category III
Subcontract	Sections & Details	Hold	ER705
Architect	TRO	Drawn By	JL
Engineer	Simpson Gumpertz & Heger Inc.	Check By	M.J.L.
Customer	WILLIAM BERRY & SON, INC.	Job No.	316
		Sheet	E17