



- 1 - NOT USED
- 2 - CONGRESS STREET
- 3 - VISITOR GARAGE
- 4 - EAST TOWER
- 5 - CENTRAL UTILITY PLANT
- 6 - BEAN BUILDING
- 7 - RICHARDS BUILDING
- 8 - MAINE GENERAL BUILDING

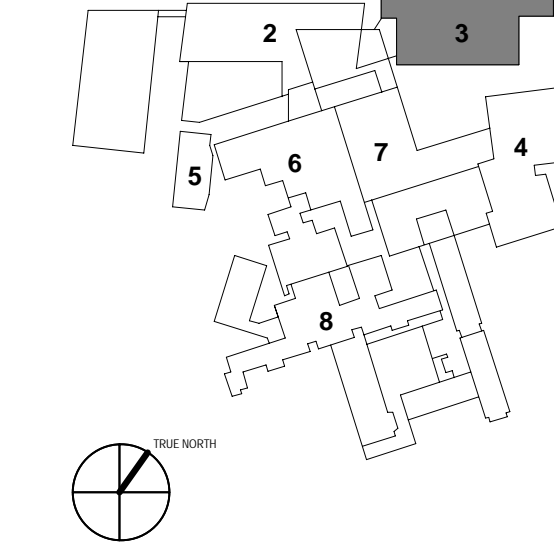

NO	ISSUE	DATE
PERMIT SET		03.28.16
PERMIT SET		03.08.16
DESIGN DEVELOPMENT		08.25.17
NO	ISSUE	DATE

Job Number: B150311-000  
 Drawn: DTM  
 Checked: PJR  
 Approved: PJR

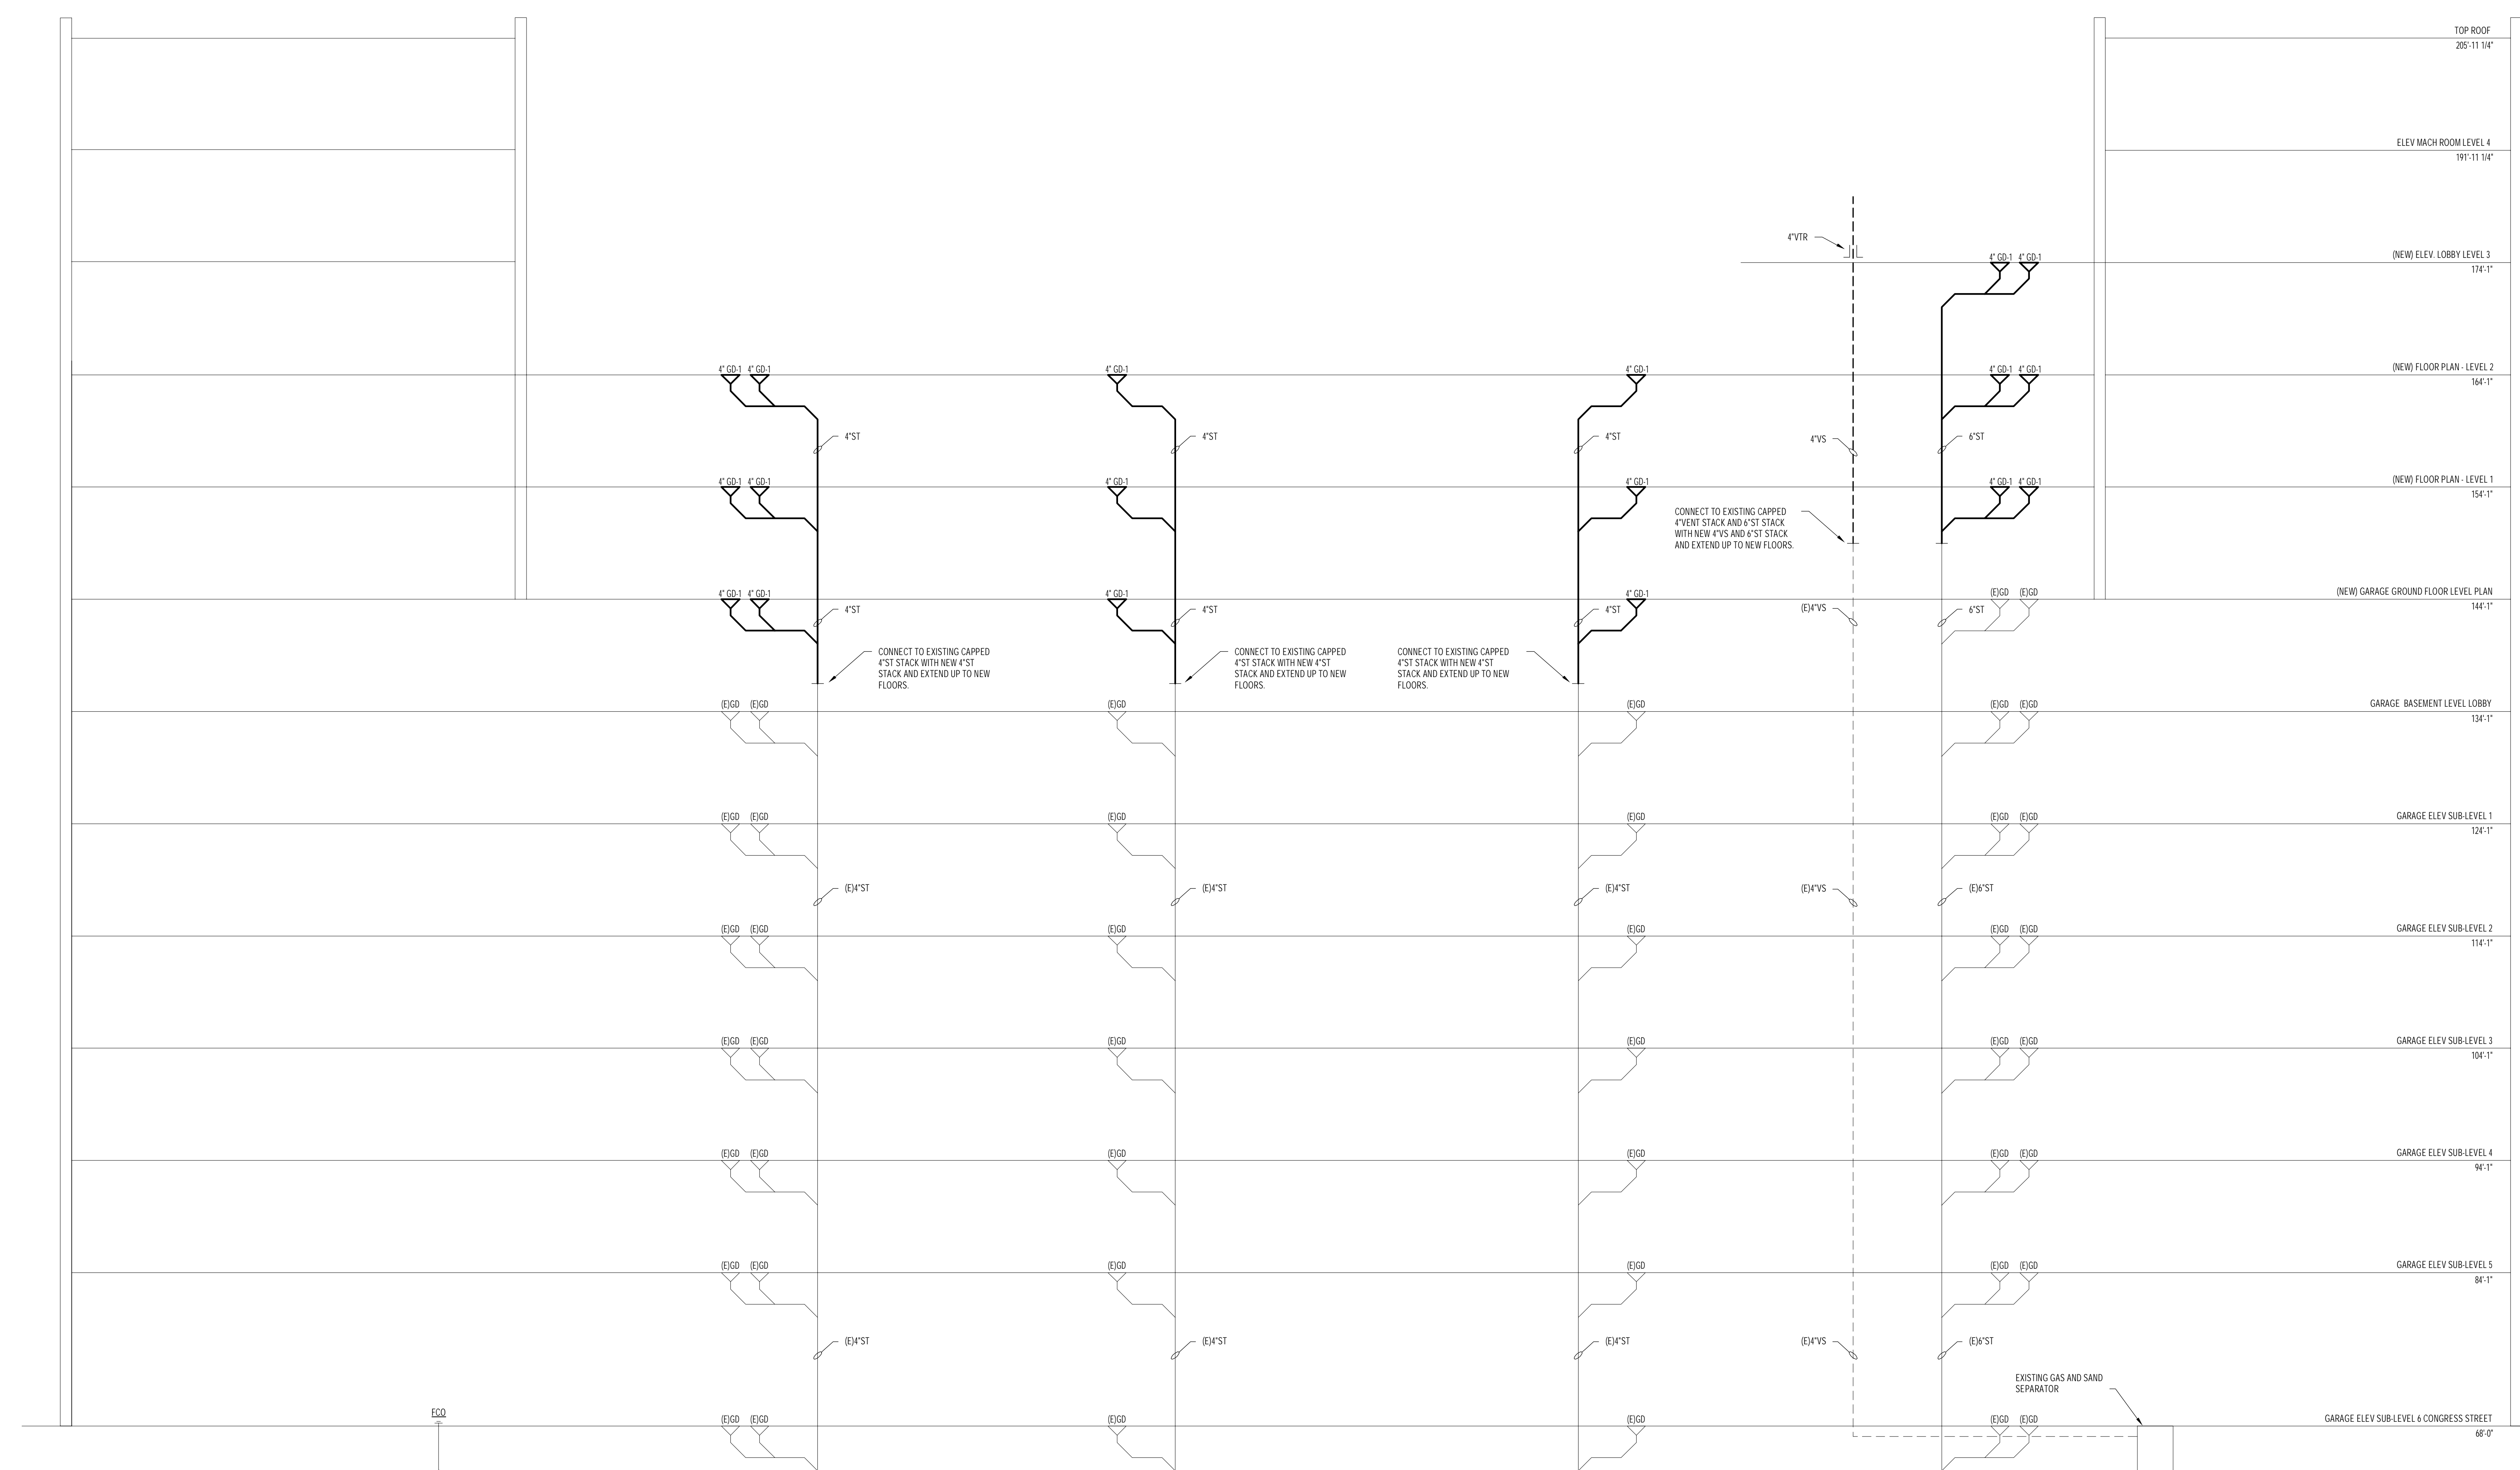

**1 PLUMBING RISER DIAGRAM**  
 SCALE: NONE