


NOTE:

1. SEE P-001 FOR LEGEND, ABBREVIATIONS AND GENERAL NOTES.



KEYED NOTE:

- ① CONNECT TO 1-1/2" V TO (E) V. VERIFY EXACT LOCATION IN FIELD.
- ② CONNECT 2" V TO (E) V. VERIFY EXACT LOCATION IN FIELD.

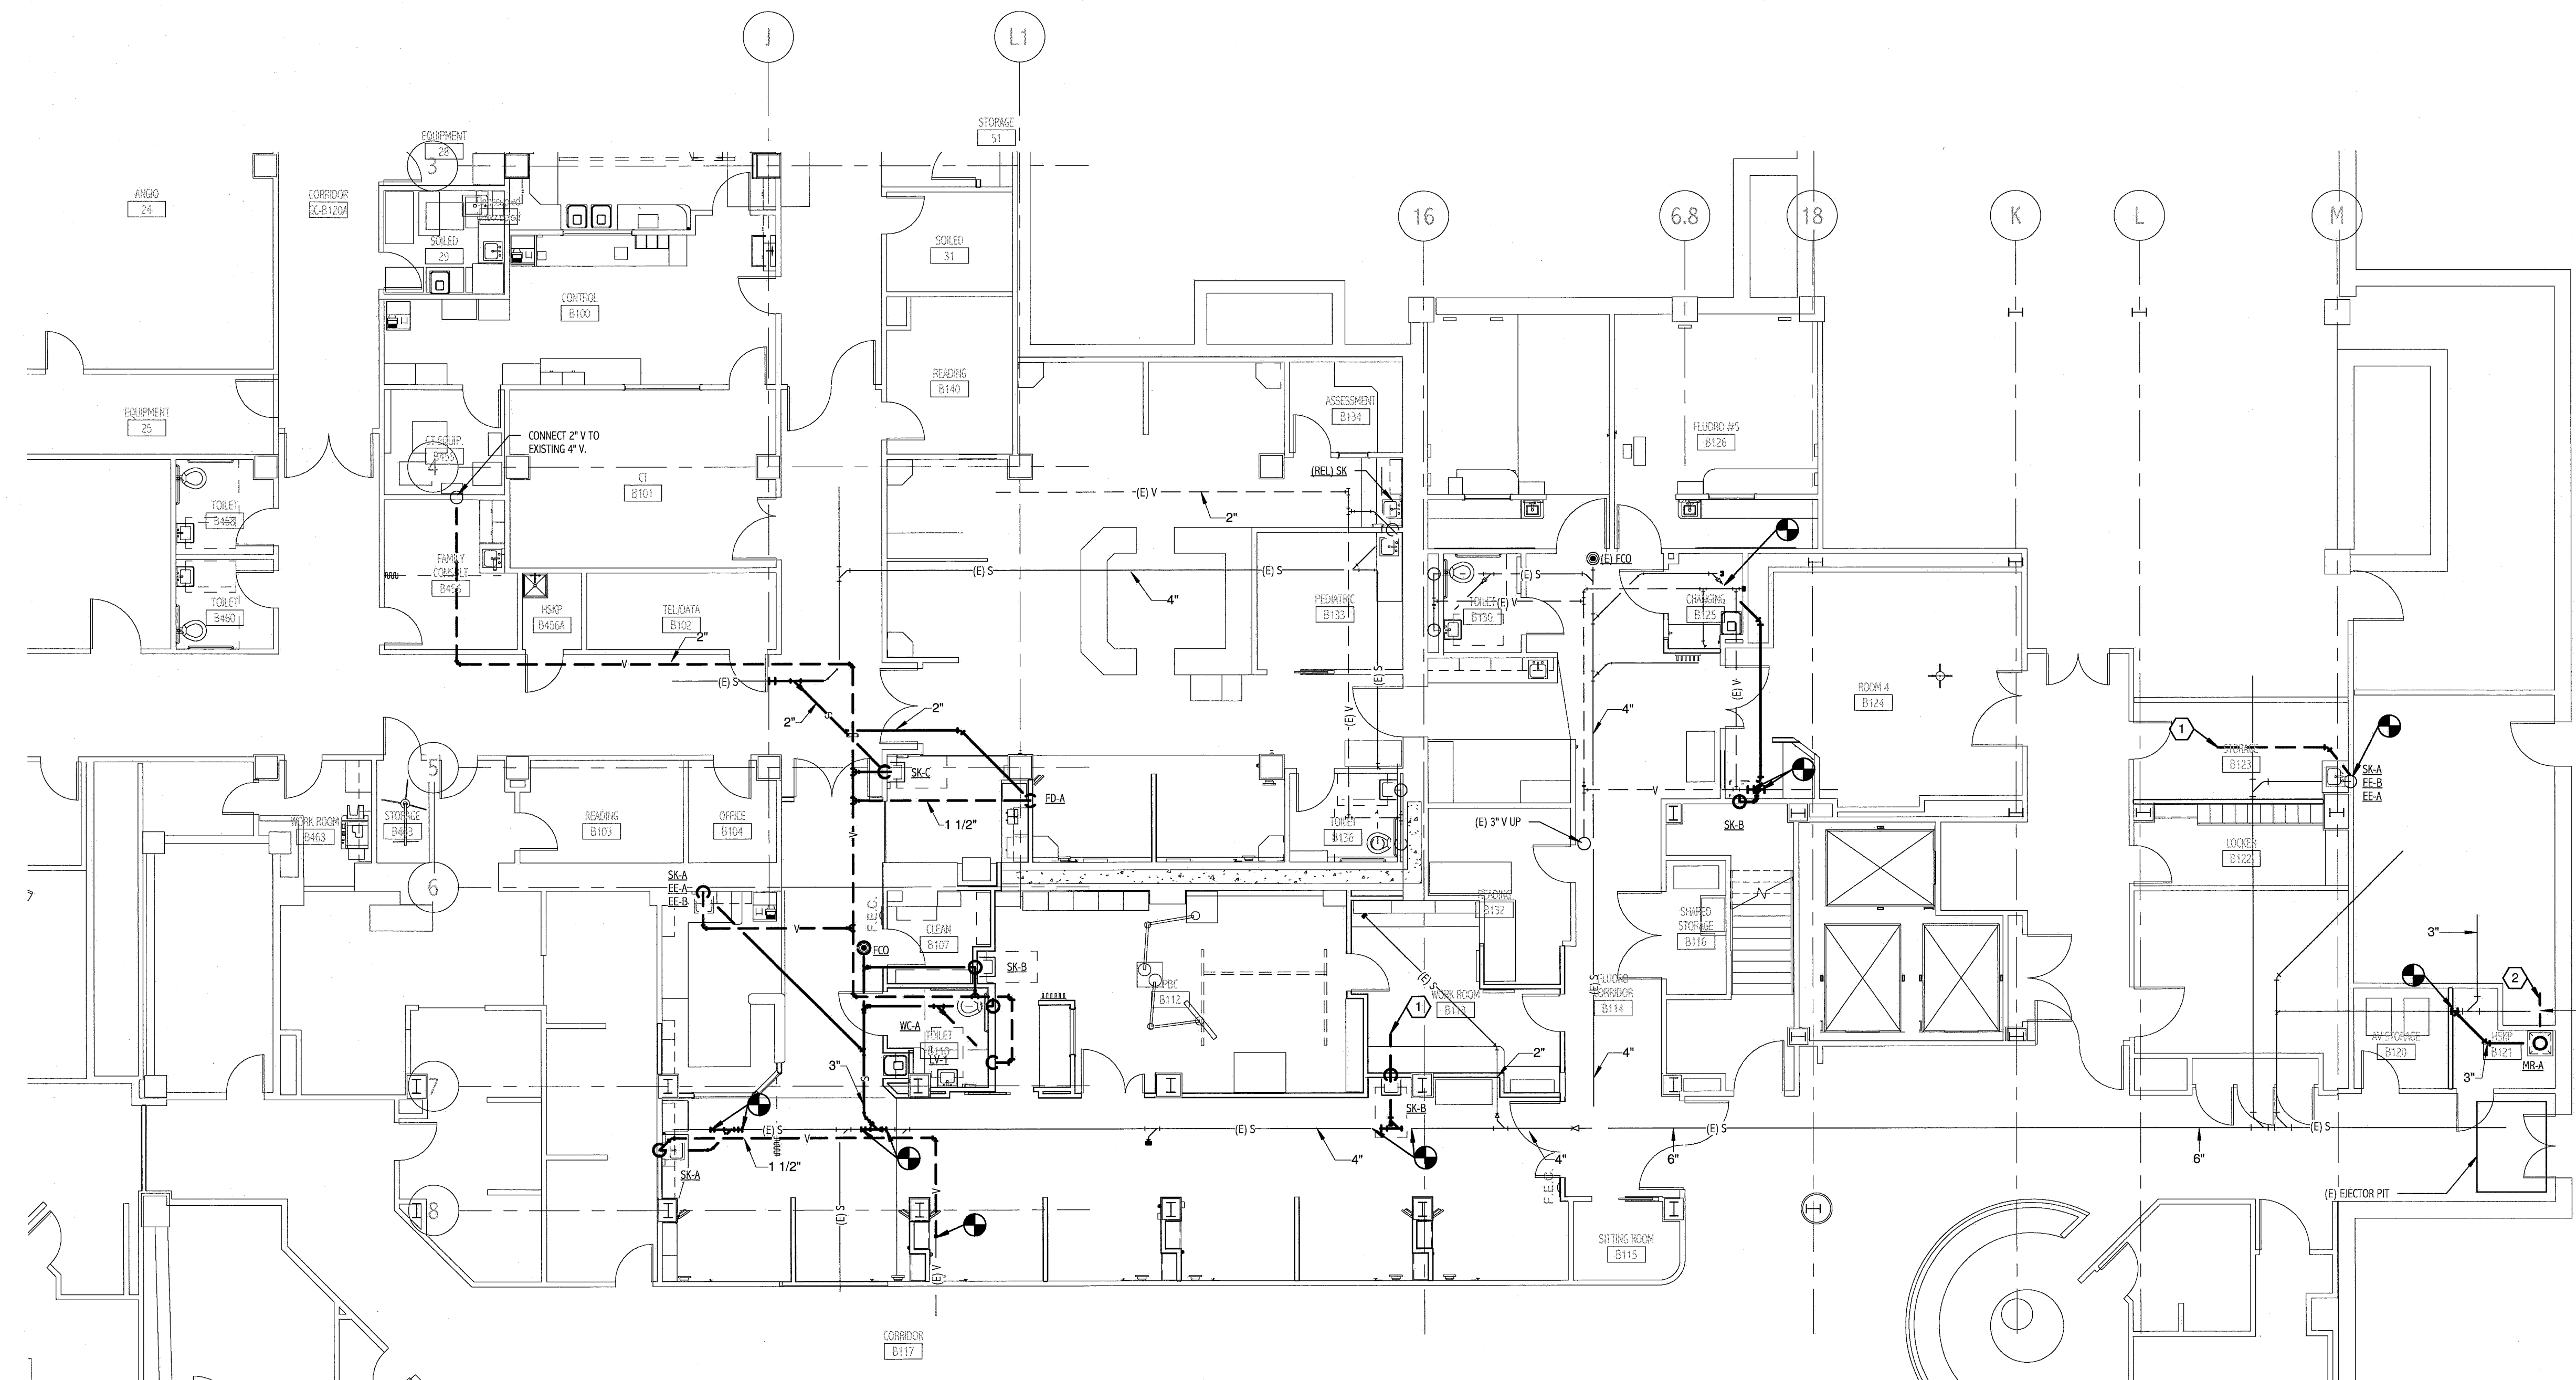

① BASEMENT LEVEL DWV PLAN
1/8" = 1'-0"

144 Free Street, P.O. Box 618
Portland, Maine 04104
Tel: (207) 772-3846
Fax: (207) 772-0703
www.smri.com

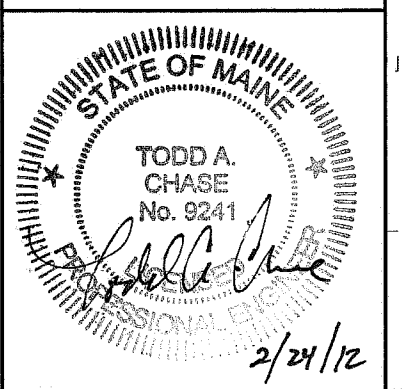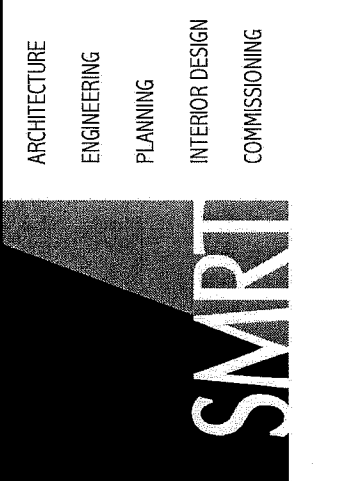

MAINE MEDICAL CENTER
HOLDING, RADCU & PBC RENOVATION
PORTLAND, ME

ISSUED FOR CONSTRUCTION
02.24.12

CURRENT ISSUE STATUS:

REV	DESCRIPTION	DATE
0	ISSUED FOR CONSTRUCTION	2.24.12

GRAPHIC SCALE:
0" 1"

SCALE: 1/8" = 1'-0"

PROJECT MANAGER: DM

DRAWN BY: BSG

DATE OF RECORD: TAC

PROJECT NO: 11063

DATE: 02.24.12

SHEET TITLE:
BASEMENT DWV
PIPING PLAN

SHEET No.
PL101