

REFLECTED CEILING NOTES

- FIRE SPRINKLERS SHALL BE LOCATED IN ALIGNMENT WITH OTHER CEILING ITEMS, TYPICALLY.
- FIRE SPRINKLERS SHALL BE CENTERED IN CEILING TILE.
- FIRE SPRINKLERS SHALL BE PLACED TO COORDINATE WITH LIGHT FIXTURE POSITIONS INDICATED.
- ALIGN CEILING ITEMS AS SHOWN, WITH COMMON CENTERLINES, TYPICALLY. CENTER ITEMS IN CEILINGS, OR IN AREAS UNLESS INDICATED OTHERWISE.
- REFER TO ROOM FINISH SCHEDULE FOR CEILING HEIGHTS AND CEILING FINISHES TO BE PROVIDED.
- EXCEPT WHERE INDICATED, CENTER CEILING GRIDS IN ROOMS. USE HALF TILES OR GREATER @ PERIMETERS AS POSSIBLE.
- PROVIDE ACCESS PANELS AS REQUIRED IN GWB CEILINGS FOR ACCESS TO MECHANICAL VALVES/ CONTROLS. REFERENCE MECHANICAL.

KEYED NOTES:

- 1/4" TRACK TO BE 3" LOWER THEN LOWEST ADJACENT CEILING AS SCHEDULED.
- CURTAIN TRACK
- CEILING MOUNTED PROJECTOR
- N TRACK

SYMBOL LEGEND

2x2 SUSPENDED CEILING PANEL AND GRID ASSEMBLY.

2x4 SUSPENDED CEILING PANEL AND GRID ASSEMBLY.

2x2 SUSPENDED ACT 5 ("WOOD LOOK") CEILING PANEL AND GRID ASSEMBLY.

OWB CEILING.

2x4 LAY-IN LIGHT FIXTURE.

1x4 PENDANT LIGHT FIXTURE.

DOWN LIGHT.

CEILING MOUNTED EXIT LIGHT.

RETURN AIR GRILLE.


SUPPLY AIR GRILLE.

EXHAUST AIR GRILLE.

RADIANT CEILING PANEL, SEE MECH.

CEILING MOUNTED SMOKE DETECTOR.

ACCESS PANEL. - FINAL QUANTITIES, SIZES AND LOCATIONS TO BE DETERMINED IN FIELD.

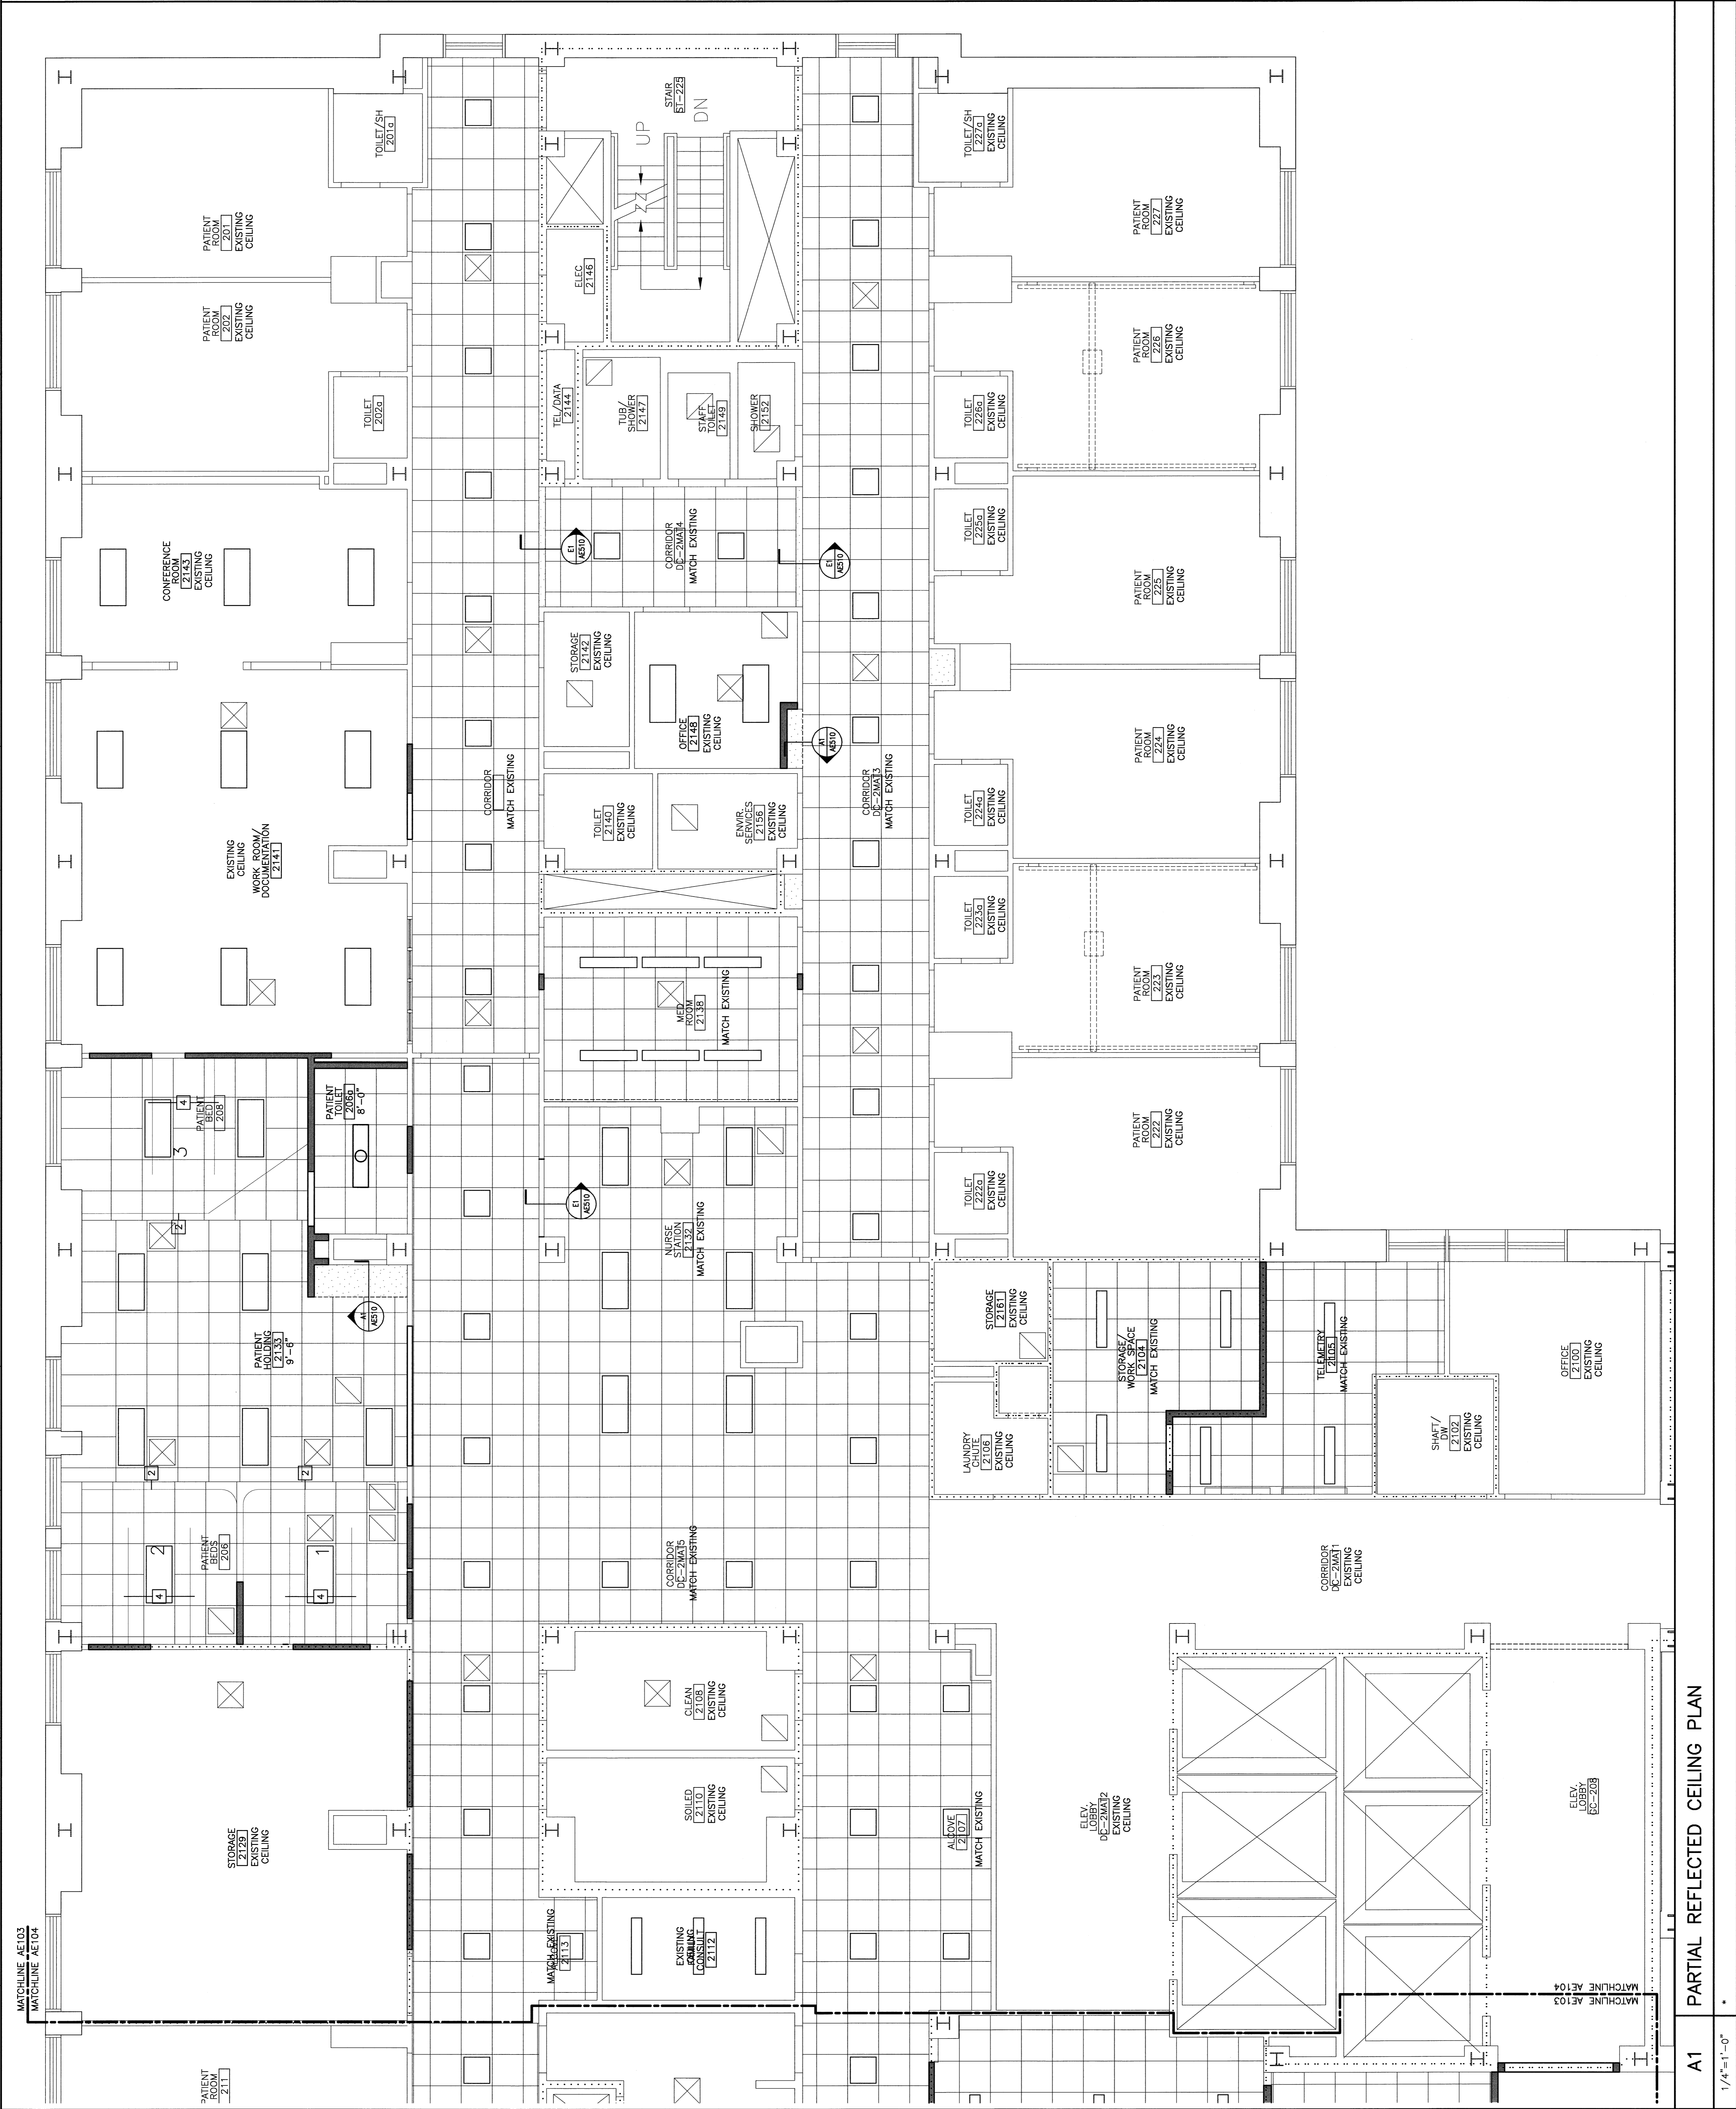

REV.	ISSUED FOR CONSTRUCTION	DESCRIPTION	DATE
0			9-12-08

ISSUED FOR CONSTRUCTION
9-12-08

CURRENT ISSUE STATUS:

144 Park Street, Portland, Maine 04104
Tel: (207) 773-3846
Fax: (207) 773-1070
www.smrt.com

ARCHITECTURE
ENGINEERING
PLANNING
INTERIOR DESIGN
COMMISSIONING

SMRT
MAINE MEDICAL CENTER - RICHARDS WING 2ND FLOOR
INPATIENT SERVICES
PORTLAND, MAINE

PARTIAL REFLECTED CEILING PLAN

SHEET TITLE

SCALE: 1/4" = 1'-0" DATE: 9-12-08

PROJECT NUMBER: COP GRAPHIC SCALE: 0'

JOB CADDWDR: RDR

DATE OF RECORD: COP

SMRT CADDLEE: AE104-08103

PROJECT NO.: 08103

SHEET NO.: AE104

A1 PARTIAL REFLECTED CEILING PLAN

1/4" = 1'-0"