

NOTES:

1. SEE NOTES ON M-001 FOR LEGENDS AND ABBREVIATIONS.
2. EXTEND EXISTING BRANCH FLEX DUCTS AT NEW DIFFUSER LOCATIONS TO MATCH EXISTING DUCT TRANSITIONS. PROVIDE DUCT TRANSITIONS IF NECESSARY TO MATCH DIFFUSER NECK SIZE. COORDINATE DIFFUSER LOCATION WITH CEILING FIXTURES.
3. BALANCING CONTRACTOR TO MEASURE AND RECORD AIRFLOWS TO EXISTING SUPPLY AND RETURN AIR TERMINALS PRIOR TO DEMOLITION. REBALANCE TERMINALS TO INDICATED AIRFLOWS AT NEW AIR TERMINALS AND TO PRESENT AIRFLOWS TO EXISTING AIR TERMINALS. PROVIDE BALANCING TERMINALS DESIGN AIRFLOWS INDICATED FOR INFORMATION ONLY.


KEYED NOTES:

- ① NOT USED.
- ② HWS/R PIPING IS LOCATED ABOVE THE CEILING OF FLOOR BELOW.
- ③ REMOVE EXISTING 24" LAY-IN SUPPLY DIFFUSER IN CORRIDOR TIE-IN TO EXISTING 1448 BRANCH DUCT AS INDICATED. HWS/R PIPING IS LOCATED ABOVE THE CEILING OF CORRIDOR AND BALANCE TO ARIELOW INDICATED.

REV.	ISSUED FOR CONSTRUCTION	DATE
0		9-12-08

ISSUED FOR CONSTRUCTION
9-12-08

CURRENT ISSUE STATUS:

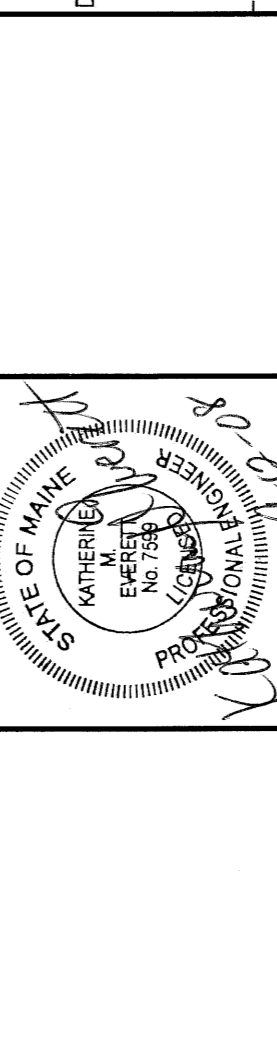

SMRI
ARCHITECTURE
ENGINEERING
PLANNING
INTERIOR DESIGN
COMMISSIONING

144 Fore Street, P.O. Box 618
Portland, Maine 04104
Tel: (207) 772-5846
Fax: (207) 772-1000
www.smri.com

MAINE MEDICAL CENTER - RICHARDS WING 2ND FLOOR
INPATIENT SERVICES

PARTIAL SECOND FLOOR
HVAC PLAN

SHEET TITLE:	DATE:	9-12-08
SCALE:	GRAPHIC SCALE:	0'
PROJECT MANAGER:	CDP:	
DATE CAP/DRAWN:	MORRILL:	
A/E OF RECORD:	K/RE:	
SHEET CAD FILE:	MH101-08103	
PROJECT NO.:	08103	

A5 SECOND FLOOR PARTIAL PLAN

1/4"=1'-0"

A1 PART PLAN

1/4"=1'-0"