

NOTES:


- SEE NOTES ON M-001 FOR LEGENDS AND ABBREVIATIONS.
- EXTEND EXISTING BRANCH FLEX DUCTS AT NEW DIFFUSER LOCATIONS TO MATCH EXISTING DUCT TRANSITIONS IF NECESSARY TO MATCH DIFFUSER NECK SIZE. COORDINATE DIFFUSER LOCATION WITH CEILING FEATURES.
- BALANCING CONTRACTOR TO MEASURE AND RECORD AIRFLOWS TO DETERMINE EXISTING AIRFLOW PATTERNS PRIOR TO DEMOLITION. REBALANCE TERMINALS TO INDICATED AIRFLOWS AT NEW AIR TERMINALS AND TO PRESENT AIRFLOWS TO EXISTING AIR TERMINALS. TERMINAL DESIGN AIRFLOWS INDICATED FOR INFORMATION ONLY.

KEYED NOTES:

- CONFIRM DUCT SIZE PRIOR TO SELECTION OF SMOKE DAMPER. SEE DETAIL G1/A-501 (SIMILAR) FOR INSTALLATION DETAILS.

REV.	ISSUED FOR CONSTRUCTION	DATE
0		9-12-08

ISSUED FOR CONSTRUCTION
9-12-08

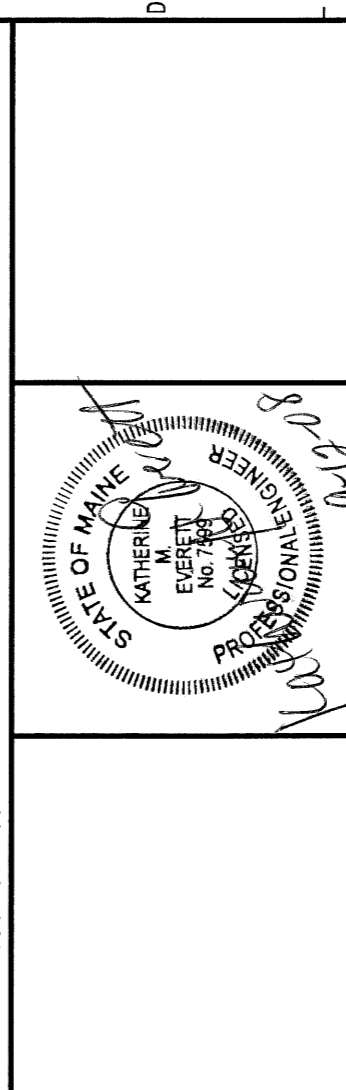

141 Fore Street, P.O. Box 418
Portland, Maine 04104
Tel: (207) 772-3646
Fax: (207) 772-8070
www.mhvac.com

ARCHITECTURE
ENGINEERING
PLANNING
INTERIOR DESIGN
COMMISSIONING

MAINE MEDICAL CENTER - RICHARDS WING 2ND FLOOR
INPATIENT SERVICES
PORTLAND, MAINE

PARTIAL SECOND FLOOR
HVAC PLAN

SHEET TITLE: 1/4" = 1'-0" DATE: 9-12-08
JOB CAP/DRAWN: CDP GRAPHIC SCALE: 0' 1'
A/E OF RECORD: RWE SHEET No.:
SHEET LOAD FILE: MH102-08103
PROJECT No.: 08103

A1 PARTIAL FLOOR PLAN
1/4" = 1'-0"

NEW INSULATED 5/8" LAMIN 5/8" SECTION PERFORANT LINES, 5/8" ELEVATION 6" ABOVE ROOF.

4x4 PRESSURE TREATED WOOD SLEEPERS. REFERENCING DOWN TO CEILING FLOOR ROOF. COORDINATE LOCATION WITH FIRST FLOOR WINDOWS.