

PLUMBING FIXTURE SCHEDULE

TAG	DESCRIPTION	FIXTURE	FAUCET/DRAIN	TRIM	SUPPORT	CW	HW	WASTE	VENT	NOTES
WC-A	WALL MOUNTED WATER CLOSET-ADA	AMERICAN STANDARD #2297.103 "AFWALL" VITREOUS CHINA SIPHON, JET TYPE, 1-1/2" TOP SPUD, 1.8 GPF	CHURCH #600-SSC SEAT-WHITE	CHURCH #600-SSC SEAT-WHITE	ZURN #Z-1203/1204	1"	-	4"	2"	1.3
LAV-A	WALL MOUNTED LAVATORY-ADA-SENSORED	AMERICAN STANDARD # 0355.012 "LUCERNE" VITREOUS CHINA, CENTER HOLE FAUCET AND CONCEALED ARM SUPPORT	SLOAN OPTIMA #ET-90-45-BDT #EL-248-40 TRANSFORMER AND #ET-160-A STRAINER	MCQUIRE LOOSE KEY ANGLE STOPS, RISERS, CHROME PLATED	ZURN #Z-1231	1/2"	1/2"	1-1/2"	1-1/2"	1.4,5
LAV-B	WALL MOUNTED LAVATORY-ADA	AMERICAN STANDARD # 0355.012 "LUCERNE" VITREOUS CHINA (S) HOLLOW MOUNTED CONCEALED ARM SUPPORT	CHICAGO #665-31TRGD/CP FAUCET	MCQUIRE LOOSE KEY ANGLE STOPS, RISERS, CHROME PLATED	ZURN #Z-1231	1/2"	1/2"	1-1/2"	1-1/2"	1.4,5
SK-A	GENERAL USE SINK COUNTER TOP DROP-IN-ADA	JUST #BL-ADA-1615-A-CR 304 SS SELF-RIMMING, 3 HOLES, CENTER DRAIN	CHICAGO #201-AGNBAE3377X FAUCET, JUST #J-ADA-35-FIS DRAIN AND OFFSET TAIL	MCQUIRE LOOSE KEY ANGLE STOPS, RISERS, CHROME PLATED	-	1/2"	1/2"	1-1/2"	-	2
SH-A	SHOWER-ADA	TILED SHOWER BY OTHERS. PROVIDE TRIM ONLY	SYMMONS #C-96-500-BS0-V-X "TEMPTRC" ADA SHOWER PACKAGE	SLIDE BAR, DIVERTER VALVE AND HAND SPRAY INCLUDED	-	1/2"	1/2"	-	-	2

- NOTES:
 1. PROVIDE PRI SIZED SHOCK ABSORBER WITH ISOLATION VALVE, ACCESSIBLE
 2. PROVIDE PRI SIZED SHOCK ABSORBER WITH ISOLATION VALVE, ACCESSIBLE
 3. PROVIDE PRI SIZED SHOCK ABSORBER WITH ISOLATION VALVE, ACCESSIBLE
 4. MOUNT RIM AT 34" AFF
 5. INSULATE EXPOSED PIPING - TRUERRO #102G

SHOCK ABSORBER SCHEDULE

TYPE	FIXTURE RATING	MANUF.	FIGURE NO.
"A"	1-10	ZURN	100
"B"	12-32	ZURN	200
"C"	33-60	ZURN	300
"D"	61-113	ZURN	400
"E"	114-154	ZURN	500
"F"	155-330	ZURN	600

MEDICAL GAS ALARM PANEL SCHEDULE

VALVE BOX No.	SERVES	GAS			
		OXYGEN	MEDICAL AIR	NITROUS OXIDE	EVAC
MGAP-5	R2 PATIENT ROOMS	X	X		

NOTES:
 1. "X" DESIGNATES GASES TO BE VALVES AT BOX
 2. VALVE SIZES ARE SAME AS PIPING SIZES. (SEE DRAWINGS)

MEDICAL GAS VALVE BOX SCHEDULE


VALVE BOX No.	GAS			
	OXYGEN	MEDICAL AIR	NITROUS OXIDE	EVAC
MGVB-1	X	X		

NOTES:
 1. "X" DESIGNATES GASES TO BE VALVES AT BOX
 2. VALVE SIZES ARE SAME AS PIPING SIZES. (SEE DRAWINGS)


DRAIN SCHEDULE

TAG	APPLICATION	TYPICAL UNIT MFR & MODEL NO.	DESCRIPTION	NOTES
FDA	PATIENT SHOWER	ZURN #ZN-415-6B-P	FLOOR AND SHOWER DRAIN COATED CAST IRON BODY, ADJUSTABLE NICKEL BRONZE STRAINER	1.2

NOTES:
 1. 1/2" TRAP PRIMER CONNECTION. SINGLE DRAIN APPLICATIONS: PRECISION PLUMBING PRODUCTS #PO-500. MULTIPLE DRAIN APPLICATIONS: PRECISION PLUMBING PRODUCTS #PO-500, #SS-8 SUPPLY TUBE & #DU-2.3 OR 4 DISTRIBUTION UNIT. PROVIDE SHUTOFF AND UNION UPSTREAM OF EACH TRAP PRIMER VALVE.
 2. NO HUB OUTLET

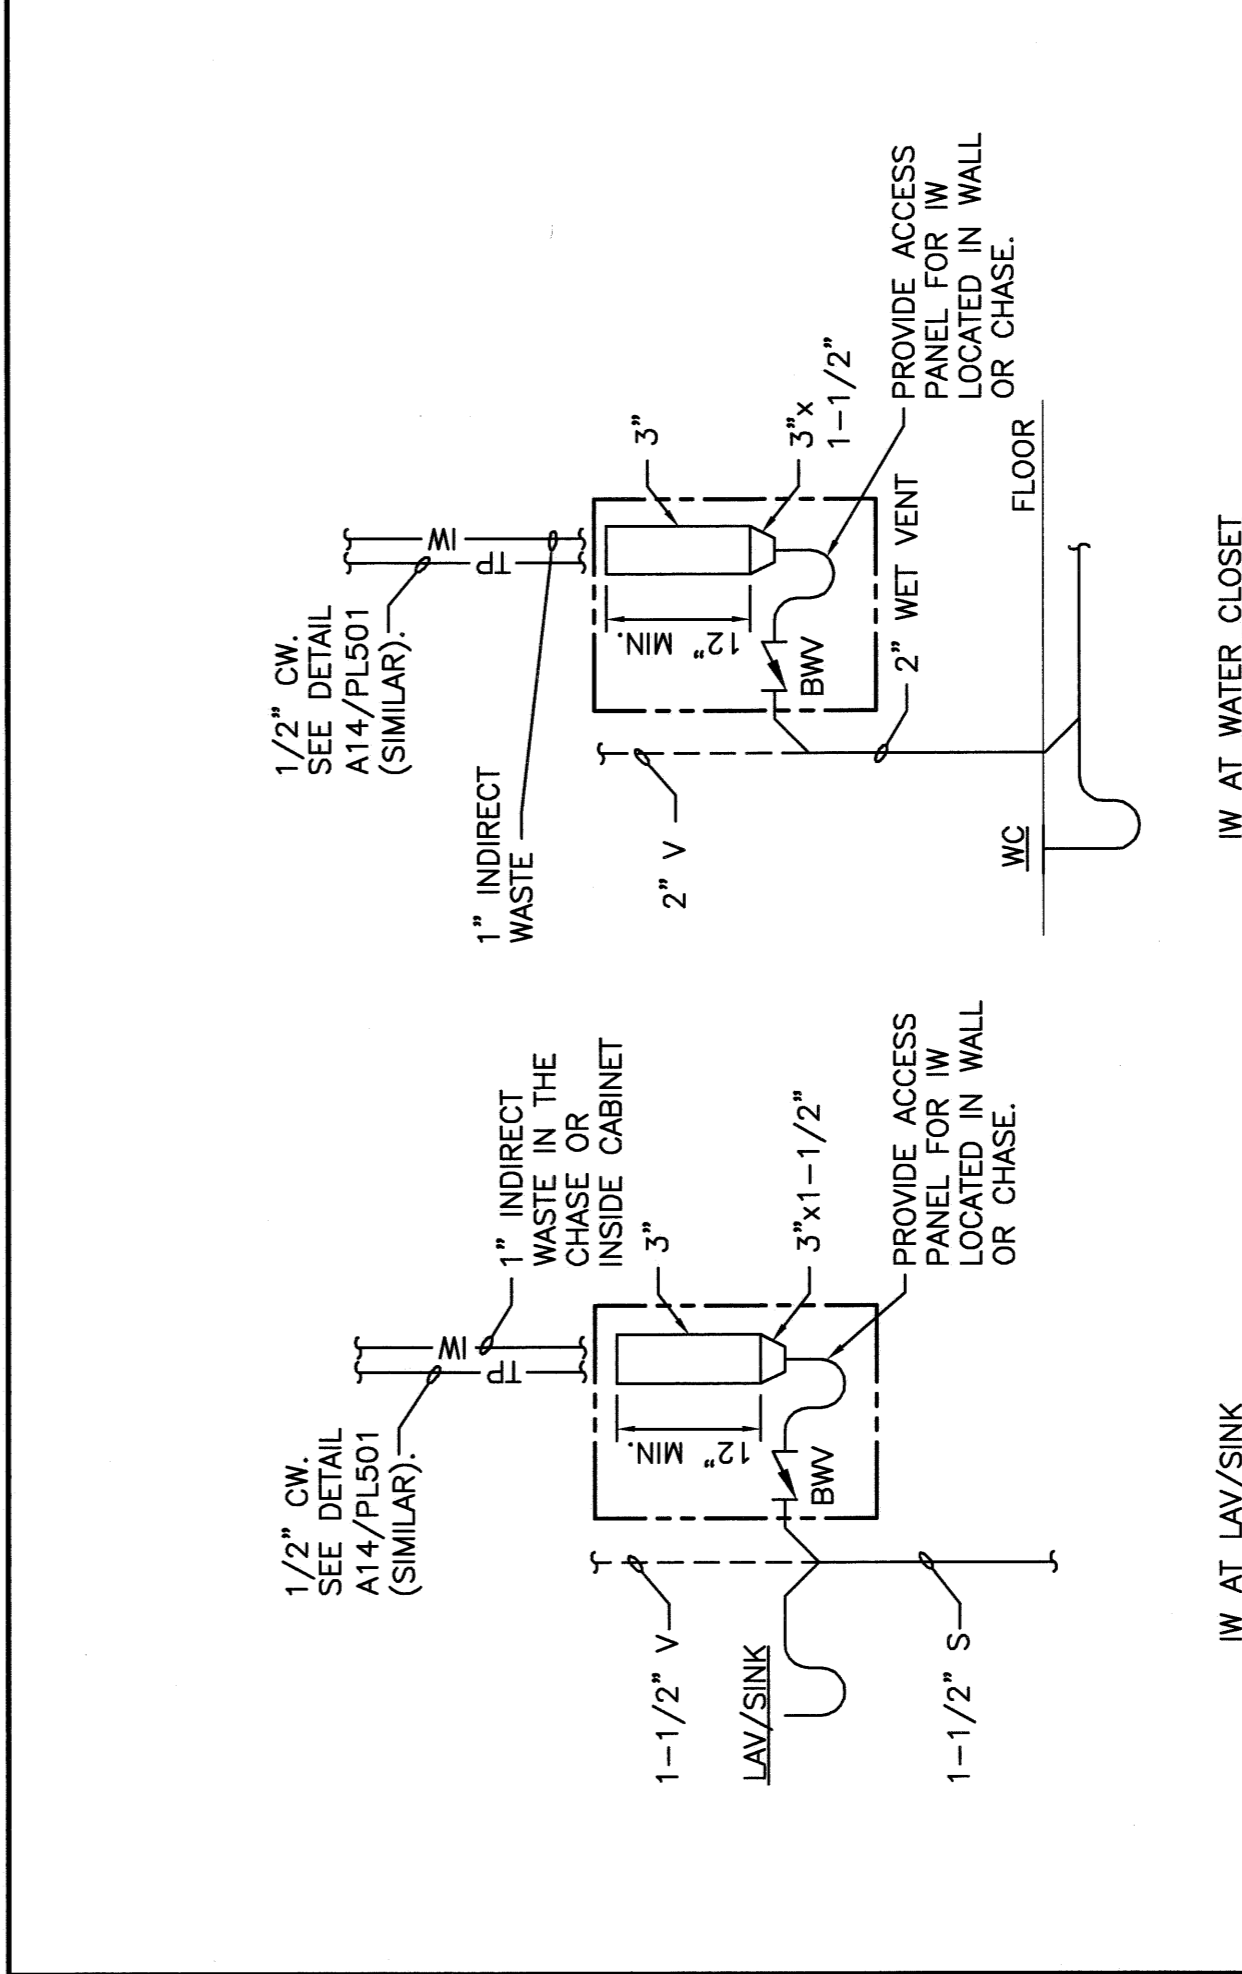

ISSUED FOR CONSTRUCTION
 9-12-08

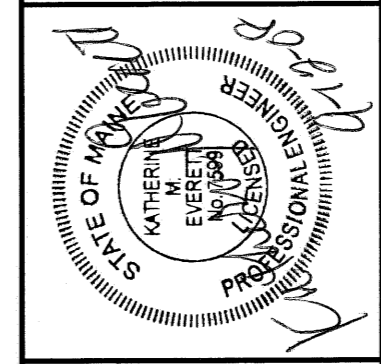

SMRT ARCHITECTURE
 ENGINEERING
 PLANNING
 INTERIOR DESIGN
 COMMISSIONING
 144 Eric Street, P.O. Box 618
 Portland, Maine 04101
 Tel: (207) 772-8846
 Fax: (207) 772-1070
 www.smrtinc.com

MAINE MEDICAL CENTER - RICHARDS WING 2ND FLOOR
 INPATIENT SERVICES
 PORTLAND, MAINE

SCHEDULES AND DETAILS

SHEET TITLE	NOT TO SCALE	DATE	9-12-08
PROJECT MANAGER	DATE	GRAPHIC SCALE	1" = 0'
DATE OF RECORD	DATE	SCALE	AS SHOWN
SMRT OUTLINE	DATE	SCALE	AS SHOWN
PROJECT No.	DATE	SCALE	AS SHOWN

A14 TRAP SEAL PRIMER DETAIL

A8 INDIRECT WASTE CONNECTION