

NOTE:


- SEE SHEET E-001 FOR LEGEND AND GENERAL NOTES.
- ALL CORRIDOR LIGHT FIXTURES SHALL BE CONNECTED TO THE EXISTING NORMAL OR EMERGENCY BRANCH CIRCUITS SERVING THE SPACE. ALL SWITCHING SHALL BE MAINTAINED AS-BUILT. ALL SWITCHING SHALL BE MAINTAINED AS-BUILT. PROVIDE AS-BUILT INFORMATION OF ACTUAL CIRCUIT NUMBERS AND SWITCHING USED.
- BRANCH CIRCUIT NUMBERS INDICATED ARE FOR CIRCUIT ORGANIZATION ONLY UNLESS SPECIFICALLY NOTED OTHERWISE. ALL WORK SHALL BE DOCUMENTED WITH AS-BUILT DRAWINGS. (EX. LP2-2-1 EQUALS THE FIRST AVAILABLE SPARE CIRCUIT IN PANELBOARD LP2-2).

KEYED NOTE:

- GENERAL 2"x4" 3-JUMP LEASED TRIGGER REMOVED DURING DEMOLITION. EXTEND EXISTING SWITCHING AND CONNECT TO EXISTING NORMAL LIGHTING BRANCH CIRCUIT SERVING THE AREA.
- CONNECT TO EXISTING NORMAL LIGHTING BRANCH CIRCUIT SERVING THE SPACE.
- CONNECT TO EXISTING EMERGENCY LIGHTING BRANCH CIRCUIT SERVING THE SPACE.
- REINSTALL EXIT SIGNAGE REMOVED DURING DEMOLITION AND RECONNECT TO EXISTING LIFE SAFETY BRANCH CIRCUIT.
- CONNECT NEW NURSE STATION LIGHT FIXTURES TO EXISTING DUAL LEVEL SWITCHING FOR INBOARD/OUTBOARD LAMP CONTROL.

REV.	DESCRIPTION	DATE
0	ISSUED FOR CONSTRUCTION	9-12-08

ISSUED FOR CONSTRUCTION
9-12-08

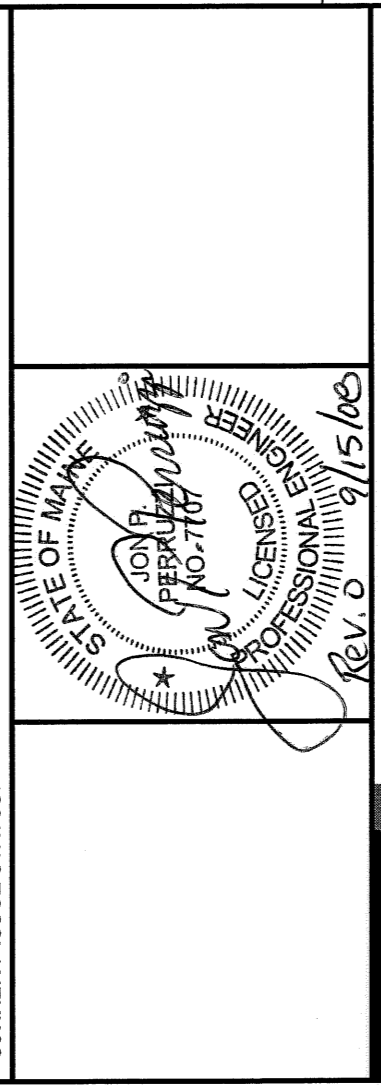

144 Free Street, P.O. Box 618
Portland, Maine 04104
Tel: (207) 773-3848
Fax: (207) 773-0770
www.smmrc.com

SMRC
ARCHITECTURE
ENGINEERING
PLANNING
INTERIOR DESIGN
COMMISSIONING

MAINE MEDICAL CENTER - RICHARDS WING 2ND FLOOR
INPATIENT SERVICES
PORTLAND, MAINE

LIGHTING
PARTIAL FLOOR PLAN SHEET 2

PROJECT TITLE	DATE	GRAPHIC SCALE
LIGHTING	9-12-08	1" = 1'-0"

PROJECT MANAGER	DATE	GRAPHIC SCALE
OP	9-12-08	1" = 1'-0"

JOB CAP/DRAWN	DATE	GRAPHIC SCALE
HP/KCS	9-12-08	1" = 1'-0"

DATE OF RECORD	DATE	GRAPHIC SCALE
HP	9-12-08	1" = 1'-0"

SHEET CAD FILE	DATE	GRAPHIC SCALE
EL102-08103	08/10/08	1" = 1'-0"

SHEET No.	DATE	GRAPHIC SCALE
EL102	08/10/08	1" = 1'-0"

A1 PARTIAL FLOOR PLAN

1/4"=1'-0"