


**GENERAL NOTES:**

- DO NOT SCALE THE DRAWINGS.
- FIELD VERIFY ALL DIMENSIONS AND LAYOUT PRIOR TO PROCEEDING WITH WORK. NOTIFY ARCHITECT IN WRITING OF ANY DISCREPANCIES WITHIN THESE CONSTRUCTION DOCUMENTS TO THE ARCHITECT WILL NOT BE GROUNDS FOR ADDITIONAL COST OR CHANGE ORDERS.
- "PROVIDE" MEANS "FURNISH AND INSTALL".
- THE CONTRACTOR SHALL BE RESPONSIBLE FOR PROVIDING ALL MATERIALS, AND WORKMANSHIP IN ACCORDANCE WITH FEDERAL, STATE AND LOCAL BUILDING CODES AND THEIR REQUIREMENTS.
- THE CONTRACTOR AND ALL TRADES SHALL NOTE REQUIREMENTS OF "GENERAL NOTES" ON ALL SHEETS.
- REFER TO LARGE SCALE PLANS FOR PARTITION TYPES AND DIMENSIONS IN AREAS WHICH ARE DETAILED AT A LARGER SCALE.
- EACH TRADE TO PROVIDE SMOKE OR FIRE SEALANT AT PENETRATIONS AS REQUIRED FOR WALL TYPE. ALL SEALANT, FIRE STOPPING, AND SMOKE STOPPING ASSEMBLIES SHALL BE U.L. RATED.
- DIMENSIONS ARE FACE OF CONCRETE, FACE OF MASONRY, AND CENTERLINE OF METALS UNLESS OTHERWISE NOTED. DIMENSIONS OF PARTITIONS ARE DIMENSIONED TO EXTERIOR FACE OF STUD, UNLESS INDICATED OTHERWISE.
- REFER TO SHEET G101 FOR TYPICAL MOUNTING HEIGHTS OF PLUMBING FIXTURES & MISCELLANEOUS ITEMS.
- REFER TO ALL CONSTRUCTION DOCUMENTS FOR REQUIREMENTS WHICH MAY AFFECT THE WORK AND COORDINATE SAME.
- REFERENCE DETAILS AND ENLARGED PLANS FOR ADDITIONAL DIMENSIONAL INFORMATION.
- DOOR JAMBS SHALL BE LOCATED 6" FROM CORNER IN STUD PARTITIONS AND 8" FROM CORNER IN MASONRY PARTITIONS, UNLESS INDICATED OTHERWISE.
- REFERENCE STRUCTURAL DRAWINGS FOR LOCATIONS OF FLOOR OPENINGS FOR HVAC DUCTS.
- FLOOR CONSTRUCTION FUNCTIONS AS SMOKE BARRIER. DUCT ENCLOSURES ARE CONSTRUCTED OF NON-FIRE RATED MATERIALS WHICH ARE DIMENSIONED TO MAINTAIN CEILING HEIGHT UNLESS OTHERWISE DESIGNATED. MECHANICAL/ELECTRICAL CONTRACTORS SHALL PROVIDE FOR SMOKE TIGHT CONSTRUCTION AT FLOOR PENETRATIONS. DUCTS PENETRATING FLOOR ASSEMBLIES SHALL BE PROVIDED WITH SMOKE DAMPERS.

**PARTITION NOTES:**

- PARTITION TYPE DRAWINGS ARE DIAGRAMS ONLY, AND ARE NOT TO SCALE.
- ALL BATT INSULATION IS TO BE CONTINUOUS FULL THICKNESS AND FULL HEIGHT UNLESS NOTED OTHERWISE.
- NON-RATED PARTITIONS FOR DUCT ENCLOSURES TO TERMINATE 6" ABOVE CEILING; COORDINATE WITH TENANT IMPROVEMENTS.

ISSUED FOR CONSTRUCTION  
9-12-08

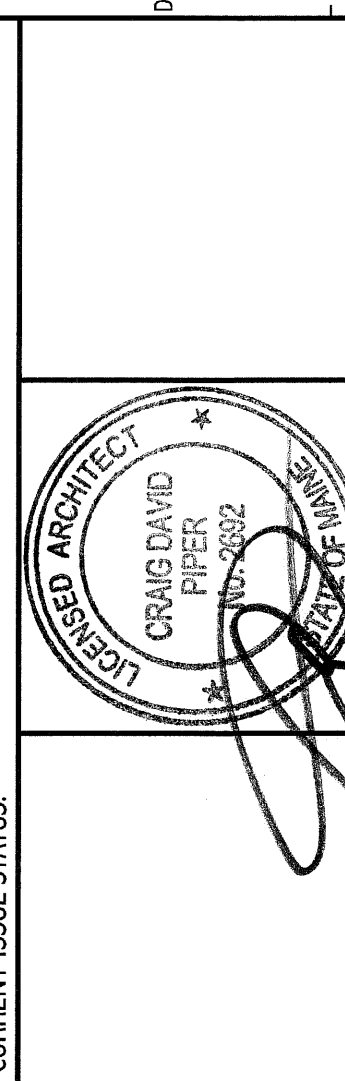


144 Five Star Blvd, Box 618  
Portland, Maine 04104  
Tel: (207) 772-8946  
Fax: (207) 772-8070  
www.smrtinc.com

**SMRT**  
ARCHITECTURE  
ENGINEERING  
PLANNING  
INTERIOR DESIGN  
COMMISSIONING



MAINE MEDICAL CENTER - L.L. BEAN WING 2ND FLOOR  
SURGICAL SERVICES  
PORTLAND, MAINE

**PARTITION SCHEDULE**

SHEET TITLE:	AS NOTED	DATE:	9-12-08
PROJECT MANAGER:	COP	GRAPHIC SCALE:	0" = 1'
DESIGNER/DRAWN:	MOR		
DATE OF RECORD:	COP		
SHEET CAD FILE:	G1002-08098	SHEET NO.:	G1002
PROJECT NO.:	08098		

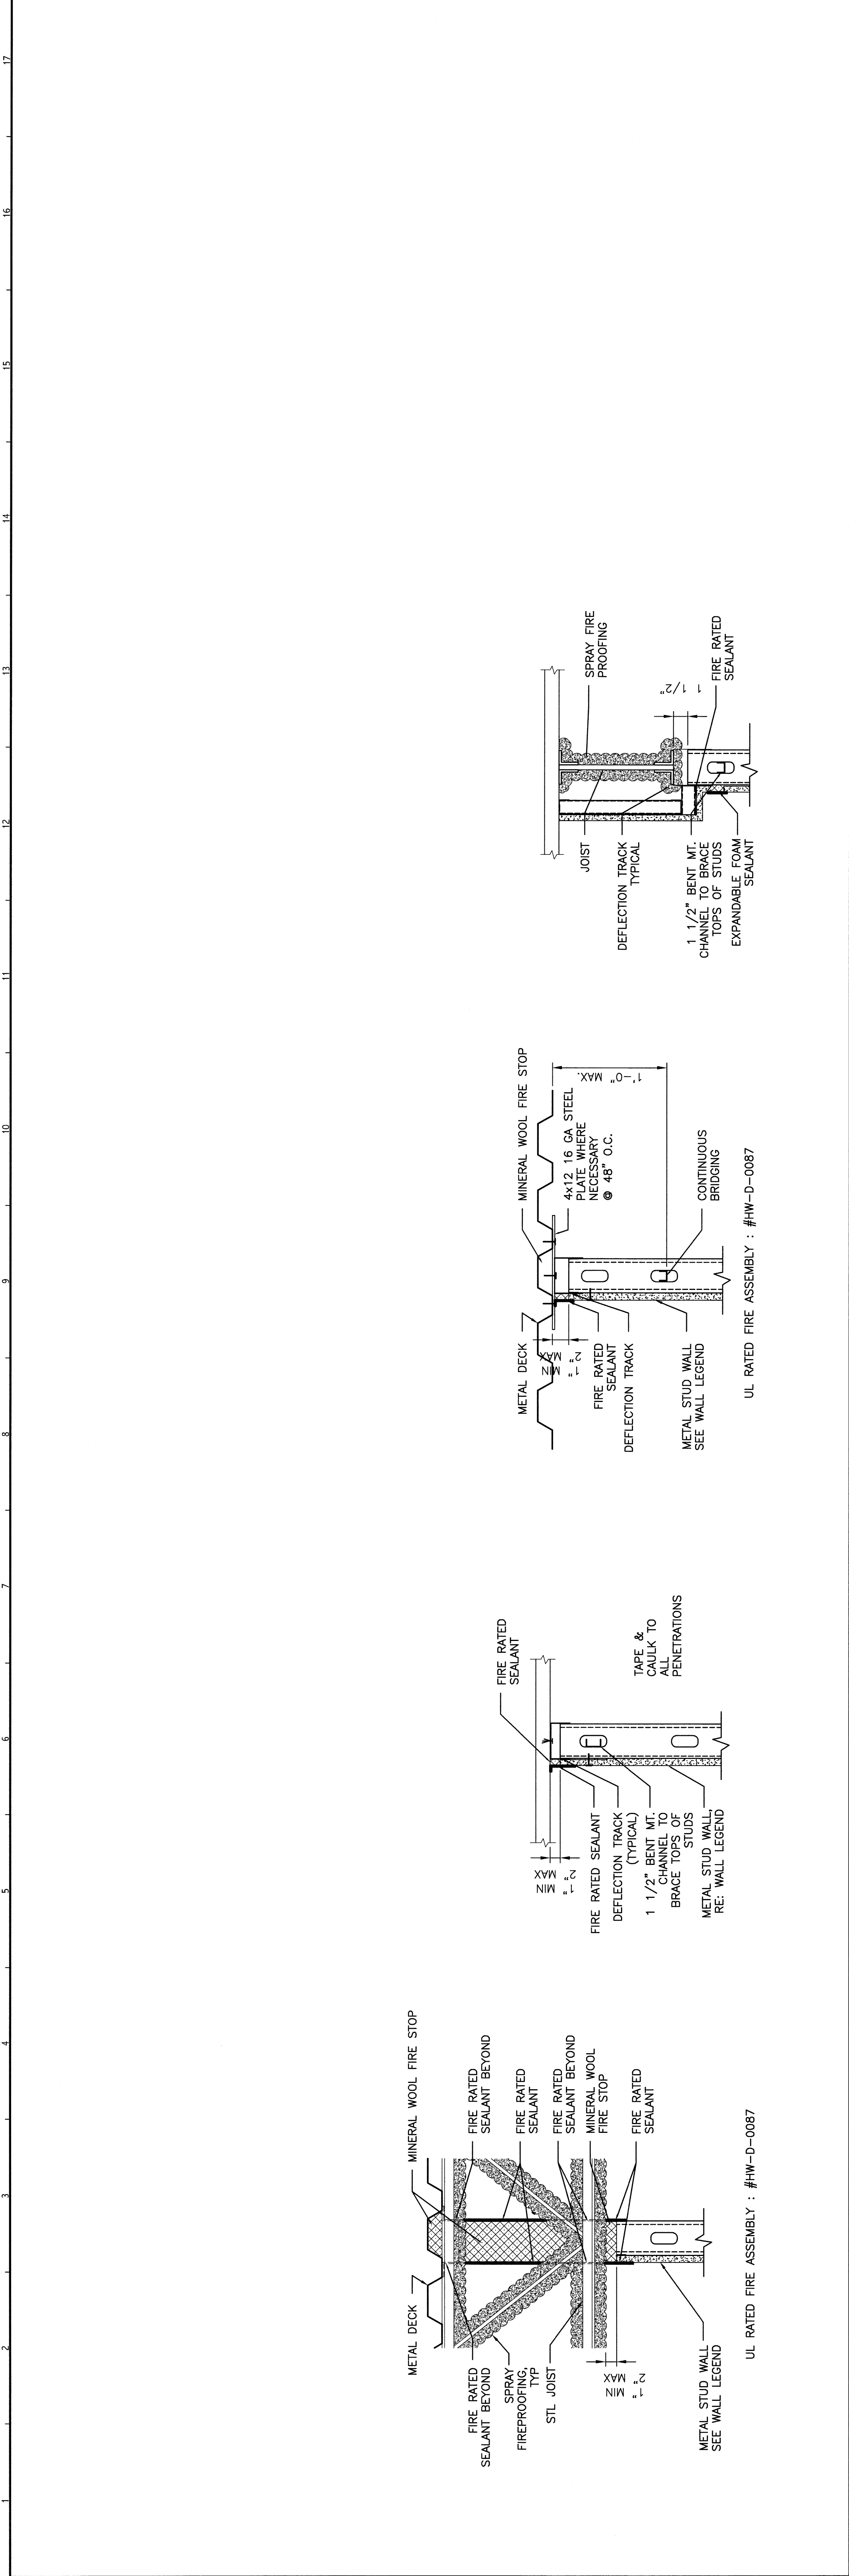

**A1 TOP OF WALL DETAILS**

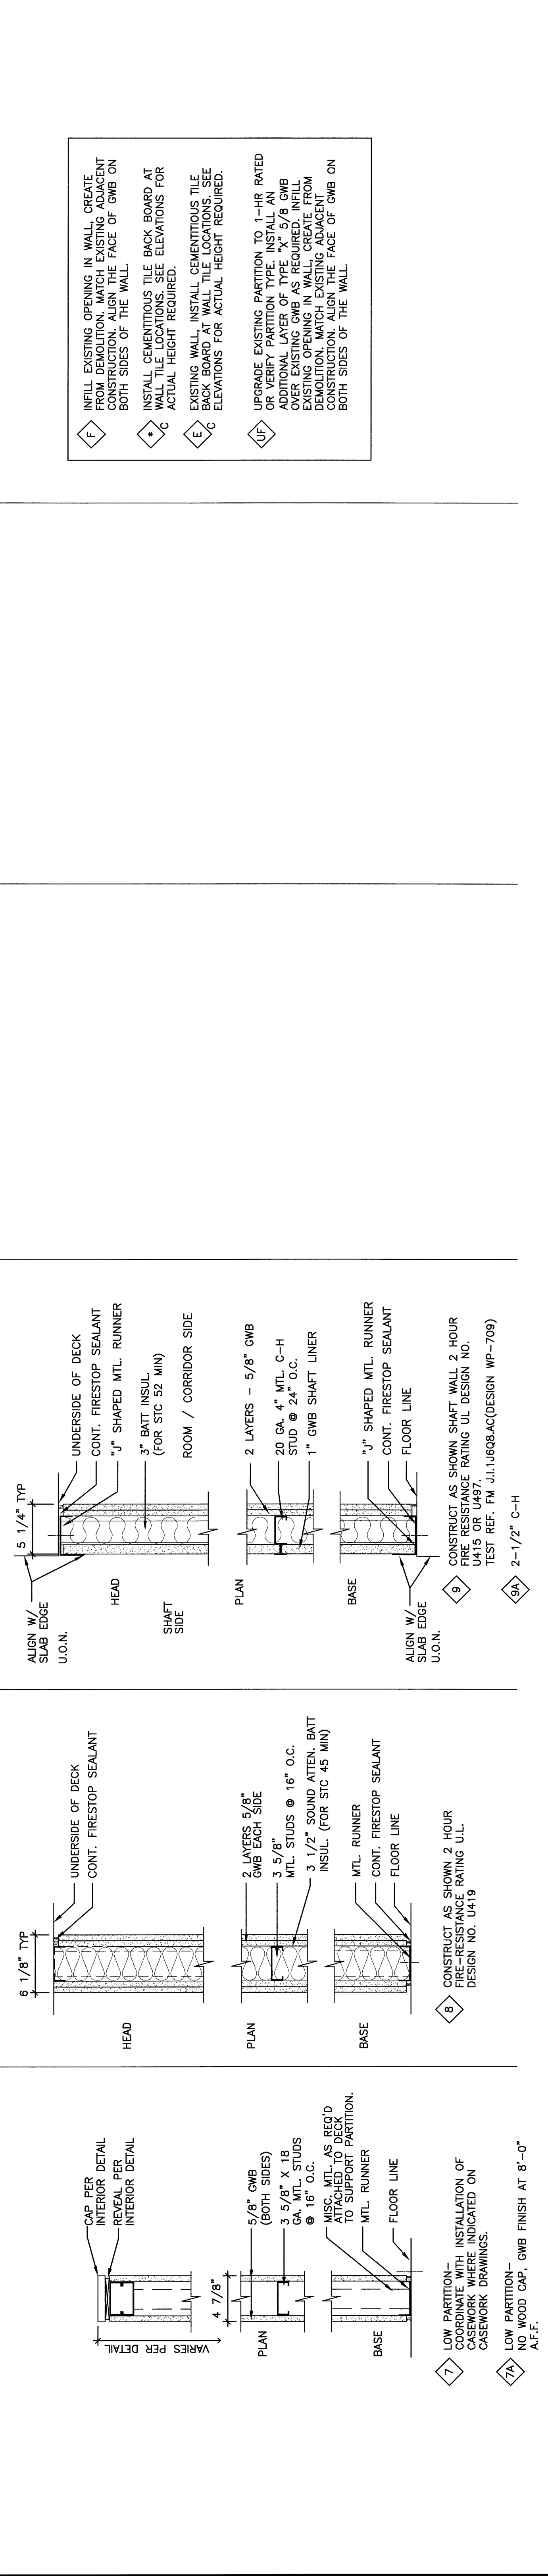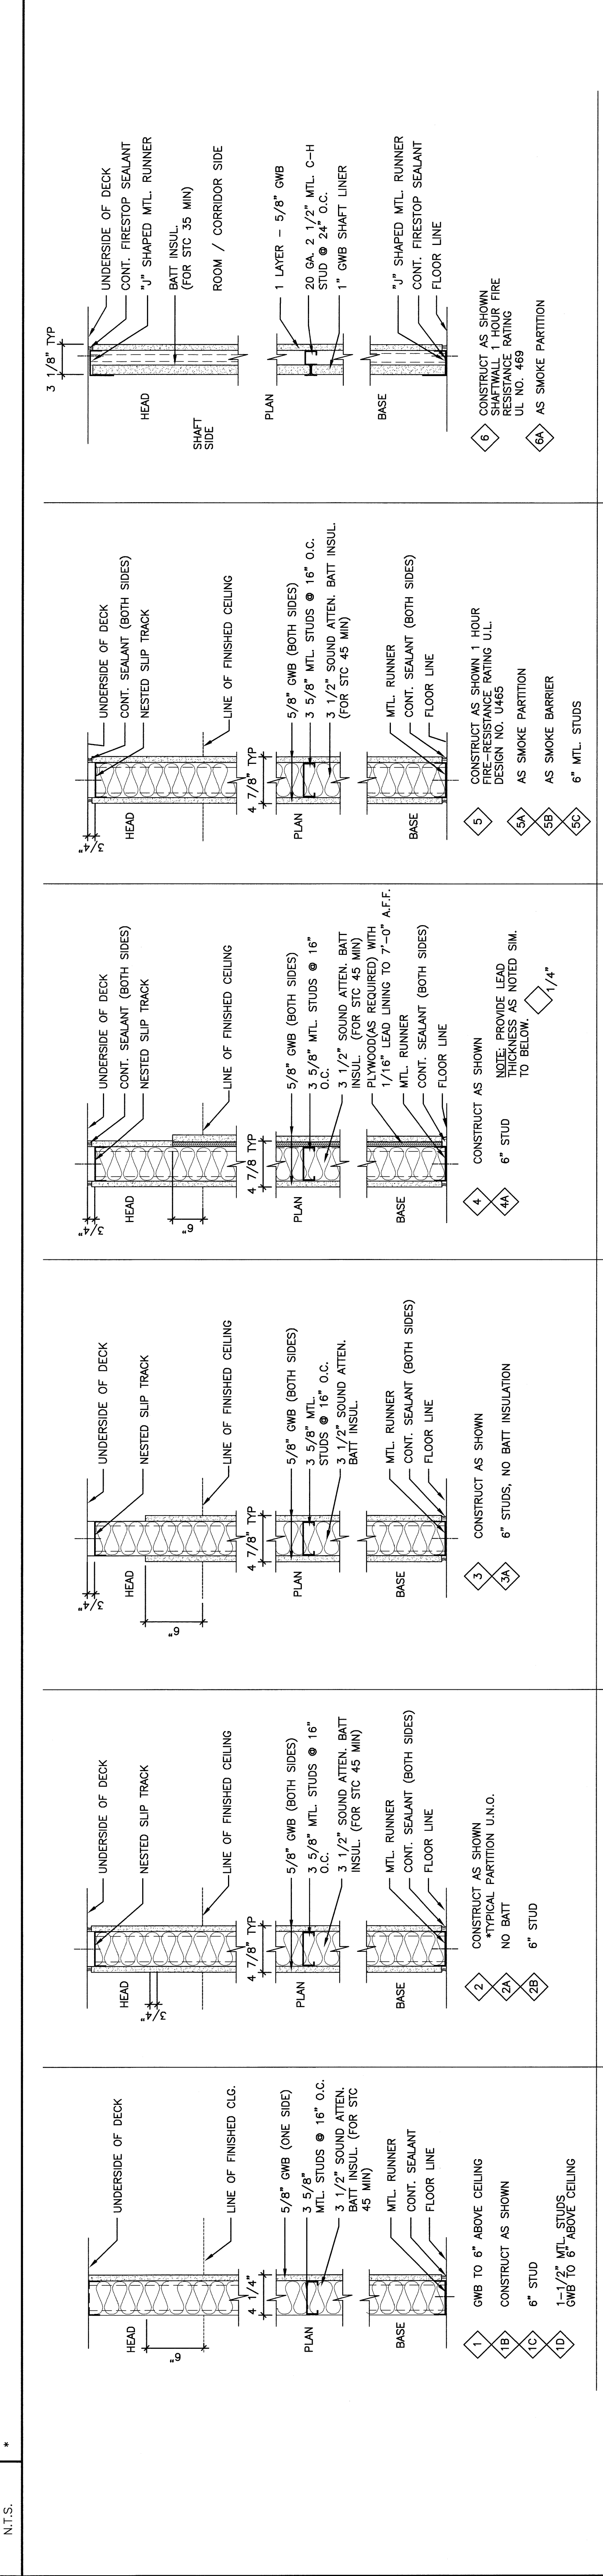

**A1 PARTITION TYPES**

- 6 INFL EXISTING OPENING IN WALL. CREATE FROM DEMOLITION. MATCH EXISTING ADJACENT WALL. BOTH SIDES OF THE WALL.
- 7 INSTALL CEMENTITIOUS TILE BACK BOARD AT WALL TILE LOCATIONS. SEE ELEVATIONS FOR ACTUAL HEIGHT REQUIRED.
- 8 EXISTING WALL. INSTALL CEMENTITIOUS TILE BACK BOARD AT WALL TILE LOCATIONS. SEE ELEVATIONS FOR ACTUAL HEIGHT REQUIRED.
- 9 UPGRADE EXISTING PARTITION TO 1-HR RATED OR VERIFY PARTITION TYPE. INSTALL AN OVER EXISTING GWB AS REQUIRED. REMOVE EXISTING OPENING IN WALL. CREATE FROM CONSTRUCTION. ALIGN THE FACE OF GWB ON BOTH SIDES OF THE WALL.

7 LOW PARTITION- COORDINATE WITH INSTALLATION OF CASEWORK DRAWINGS.

8 6\"/>