


**NOTE:**  
 1. SEE SHEET P-001 FOR LEGEND AND ABBREVIATIONS.  
 2. CONTRACTOR SHALL PATCH FLOOR TO MATCH EXISTING AS NECESSARY.

- KEYED NOTES:**
- ① EXISTING PLUMBING FIXTURE(S) AND ASSOCIATED PIPING TO REMAIN IN SERVICE.
  - ② EXISTING MEDICAL GAS OUTLET(S) TO REMAIN.
  - ③ EXISTING MEDICAL GAS VALVE BOX/ALARM PANEL AND ASSOCIATED PIPING TO REMAIN.
  - ④ DISCONNECT AND REMOVE EXISTING PLUMBING FIXTURE AS INDICATED. REMOVE INACTIVE WASTE, VENT, MOUNT OR COLD FINISHED SURFACES OR AS INDICATED AND CAP.
  - ⑤ REMOVE EXISTING MEDICAL GAS OUTLETS. REMOVE AND CAP INACTIVE PIPING BACK TO NEAREST MAIN OR AS INDICATED.
  - ⑥ REMOVE EXISTING MEDICAL GAS VALVE BOX/ALARM PANEL AND ASSOCIATED MEDICAL GAS PIPING.
  - ⑦ EXISTING MED. GAS DN TO FLOOR BELOW (SERVING ISLAND CASUALTY) ABOVE CEILING. PIPING INSIDE CHASE TO REMAIN (ABANDONED).
  - ⑧ EXISTING MED GAS FROM CEILING BELOW. CUT & CAP BELOW FLOOR.

| REV. | ISSUED FOR CONSTRUCTION | DESCRIPTION | DATE    |
|------|-------------------------|-------------|---------|
| 0    |                         |             | 9-12-08 |

**ISSUED FOR CONSTRUCTION**  
 9-12-08

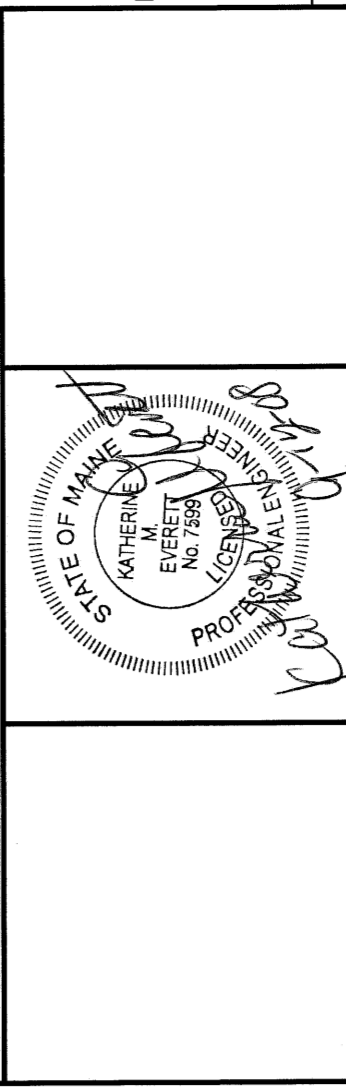

144 Fore Street, Box 688  
 Portland, Maine 04108  
 Tel: (207) 772-8000  
 Fax: (207) 772-8005  
 www.smrtinc.com

**SMRTI**  
 MAINE MEDICAL CENTER - L.L. BEAN WING 2ND FLOOR  
 SURGICAL SERVICES  
 PORTLAND, MAINE

PLUMBING AND MED GAS  
 DEMOLITION PARTIAL PLAN

|  |             |             |               |
|--|-------------|-------------|---------------|
| SHEET TITLE                                  | DATE        | SCALE       | GRAPHIC SCALE |
| PLUMBING AND MED GAS DEMOLITION PARTIAL PLAN | 9-12-08     | 1/4"=1'-0"  | 0'            |
| PROJECT MANAGER                              | DATE        | PROJECT NO. | SHEET NO.     |
| EGG  | 9-12-08     | PD102-08098 | PD102         |
| DATE OF RECORD                               | PROJECT NO. | SHEET NO.   | PROJECT NO.   |
| 9-12-08                                      | 08098       | 08098       | 08098         |

**A1 PARTIAL FLOOR PLAN**

1/4"=1'-0"