


NOTE:
 1. SEE SHEET P-001 FOR LEGEND AND ABBREVIATIONS.

KEYED NOTES:

- ① 2" V RISE
- ② 1-1/2" V RISE AND 1-1/2" W DN. CTE VENT ABOVE CEILING. CTE 2" W WITHIN WALL.
- ③ 3/4" CW AND 3/4" HW-DN. ROUTE FULL SIZE WITHIN WALL. CONNECT 1/2" CW AND 1/2" HW TO EACH LAV-C.
- ④ 1/2" CW AND 1/2" HW-DROP.
- ⑤ 1-1/2" CW-DROP. ROUTE FULL SIZE WITHIN CHASE. CONNECT 1" CW TO EACH WC-A. CONNECT 3/4" CW TO EACH WC-B. PROVIDE SHOCK ABSORBERS AT TOP OF DROPS WITH SHUT-OFF VALVE-ACCESSIBLE.
- ⑥ 1/2" CW AND 1/2" HW-DROP. 1-1/2" V RISE AND 1-1/2" W DN.
- ⑦ 2" CW AND 1-1/4" HW-DROP. ROUTE FULL SIZE WITHIN CHASE. CONNECT TO EACH WC-A AND WC-B. PROVIDE SHOCK ABSORBERS AT TOP OF DROPS WITH SHUT-OFF VALVE-ACCESSIBLE. ROUTE 3/4" CW AND 3/4" HW-EACH TO WC-A AND WC-B. PROVIDE SHOCK ABSORBERS AT TOP OF DROPS WITH SHUT-OFF VALVE-ACCESSIBLE. ROUTE 3/4" TW FROM EE-B AND 3/4" HW-EACH TO WC-A. CONNECT 1" CW AND 1/2" HW-EACH TO SE-A. PROVIDE SHOCK ABSORBERS WITH SHUT-OFF VALVES AT TOP OF DROPS-ACCESSIBLE (TYP. FOR 2).
- ⑧ 3/4" CW AND 3/4" HW-EACH TO DULCA MOUNTED TO WALL. PROVIDE SHOCK ABSORBERS AT TOP OF DROPS WITH SHUT-OFF VALVE-ACCESSIBLE. ROUTE 3/4" TW FROM DULCA TO DROCKING UNIT. PROVIDE A 3/4" RPZ BACKFLOW PREVENTER, WATTS OOB-OT, AND SHUT-OFF VALVE ON INLET. DRAIN 1" WASTE OUTLET ROSE FROM RPZ TO WASTE LINE. PROVIDE SHOCK ABSORBER ADJACENT TO UNIT OR IN PIPE CHASE WITH ACCESS PANEL. SEE DETAIL A7/PLS01 (SIMILAR).
- ⑨ 3" CW AND 1/2" HW-DROP. ROUTE FULL SIZE WITHIN CHASE. CONNECT 1" CW-EACH WC-A AND WC-B. PROVIDE SHOCK ABSORBERS AT TOP OF DROPS WITH SHUT-OFF VALVE-ACCESSIBLE. ROUTE 1/2" TW FROM EACH WC TO WASTE LINE. PROVIDE SHOCK ABSORBER ADJACENT TO UNIT OR IN PIPE CHASE WITH ACCESS PANEL. SEE DETAIL A7/PLS01 (SIMILAR).
- ⑩ 1/2" CW AND 1/2" HW-DROP. ROUTE FULL SIZE WITHIN CHASE. CONNECT 1" CW TO EACH WC-A AND WC-B. PROVIDE SHOCK ABSORBERS AT TOP OF DROPS WITH SHUT-OFF VALVE-ACCESSIBLE. ROUTE 1-1/2" W WITH-IN WALL FROM EACH LAV-C TO 2" W DN. 1-1/2" V RISE.
- ⑪ INSTALL LOCKABLE SERVICE VALVES.
- ⑫ LOCATE FD SAME AS EXISTING (OBNOVD).

REV	ISSUED FOR CONSTRUCTION	DATE
		9-12-08

ISSUED FOR CONSTRUCTION
 9-12-08

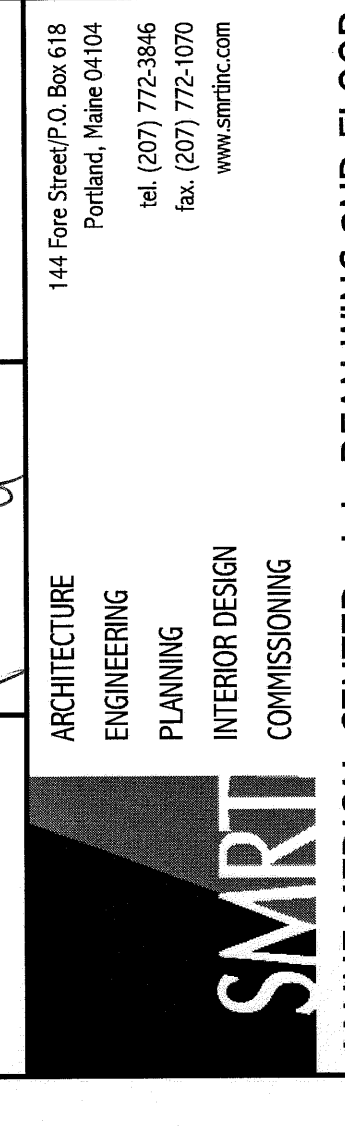

SMRI
 ARCHITECTURE
 ENGINEERING
 PLANNING
 INTERIOR DESIGN
 COMMISSIONING

144 Elm Street, Box 618
 Portland, Maine 04108
 Tel: (207) 775-3846
 Fax: (207) 775-0505
 www.smri.com

MAINE MEDICAL CENTER - L.L. BEAN WING 2ND FLOOR
SURGICAL SERVICES
 PORTLAND, MAINE

PLUMBING AND MED GAS
PARTIAL PLAN

SHEET TITLE:	DATE:	9-12-08
SCALE:	GRAPHIC SCALE:	0'
PROJECT MANAGER:	BCG	
JOB SUPERVISOR:	RME	
DATE OF RECORD:	PL101-08038	
SHEET NO.:	PL101	
PROJECT NO.:	08038	

A1 PARTIAL FLOOR PLAN
 1/4"=1'-0"