


NOTE:
 1. SEE SHEET P-001 FOR LEGEND AND ABBREVIATIONS.
 2. PATCH FLOOR TO MATCH EXISTING AS/F NECESSARY.

KEYED NOTES:
 ① NOT USED.
 ② NOT USED.
 ③ NOT USED.

④ DISCONNECT AND REMOVE EXISTING PLUMBING FIXTURE AS INDICATED. REMOVE AND CAP INACTIVE WASTE, VENT, HOT OR COLD WATER PIPING BEHIND FINISHED SURFACES OR AS INDICATED.
 ⑤ REMOVE EXISTING METEORICAL GAS OUTLETS. REMOVE ANY CAP INACTIVE PIPING BACK TO NEAREST MAIN OR AS INDICATED.

REV.	ISSUED FOR CONSTRUCTION DESCRIPTION	DATE
0	ISSUED FOR CONSTRUCTION	9-12-08

ISSUED FOR CONSTRUCTION
 9-12-08

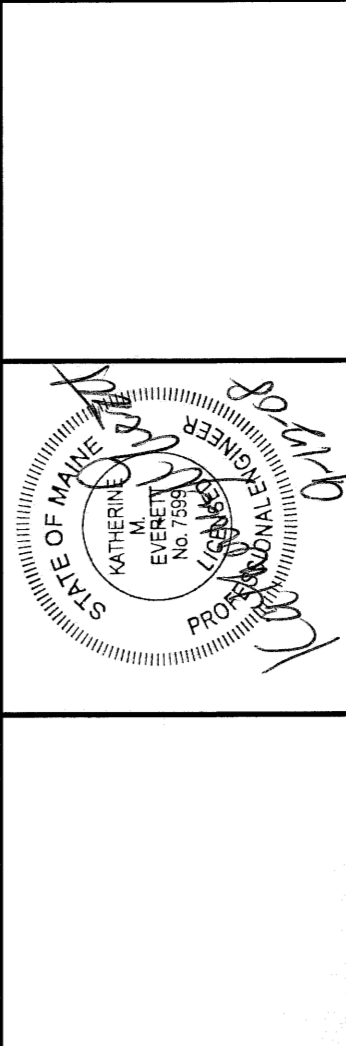

1441 Pine Street, Box 638
 Portland, Maine 04106
 Tel: (207) 772-3000
 Fax: (207) 772-3001
 www.smrts.com



MAINE MEDICAL CENTER - L.L. BEAN WING 2ND FLOOR
 INPATIENT SERVICES
 DEMOLITION PART PLAN

PLUMBING AND MED GAS
 DEMOLITION PART PLAN

PROJECT MANAGER:	DATE:	GRAPHIC SCALE:	SHEET No.:
JOB CAPTAIN/INCH:	9-12-08	1/4" = 1'-0"	PD102
DATE OF RECORD:	PROJECT No.:		
SMRT CAD FILE:	080999		

A8 PARTIAL FLOOR PLAN

1/4"=1'-0"

A1 *

PD102