
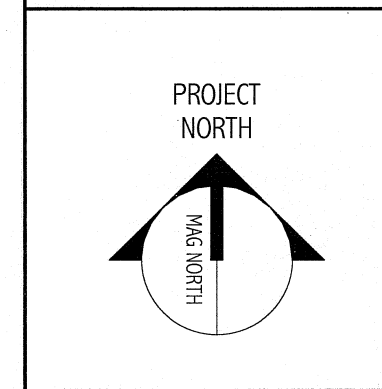
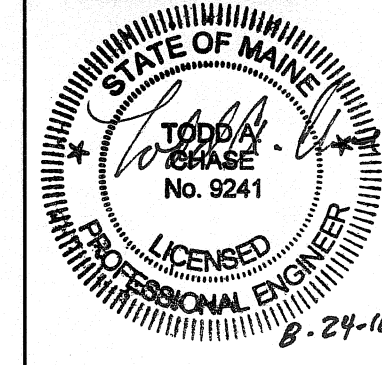


144 Free Street/PO Box 618
 Portland, Maine 04104
 Tel: (207) 772-8446
 Fax: (207) 772-1070
 www.smrtinc.com

ARCHITECTURE
 ENGINEERING
 PLANNING
 INTERIOR DESIGN
 COMMISSIONING

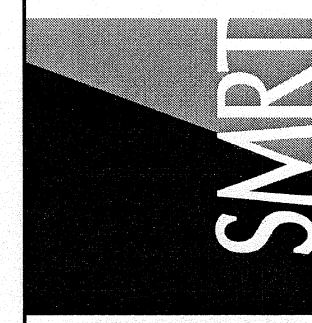

Bramhall Radiology
FLUORO RENOVATIONS
 PORTLAND, ME

ISSUED FOR CONSTRUCTION
 08.24.10

CURRENT ISSUE STATUS:


| REV | DESCRIPTION | DATE |
|-----|-------------------------|---------|
| 0 | ISSUED FOR CONSTRUCTION | 8.24.10 |

GRAPHIC SCALE:


SCALE: 1/8" = 1'-0"
 PROJECT MANAGER: DM
 DRAWN BY: KPB
 A/E OF RECORD: TAC
 PROJECT NO: 09022-02
 DATE: 08.24.10

SHEET TITLE:
**FLUORO PLUMBING
 PLANS**

SHEET No.
PL 101
©COPYRIGHT 2008 SMRT INC.

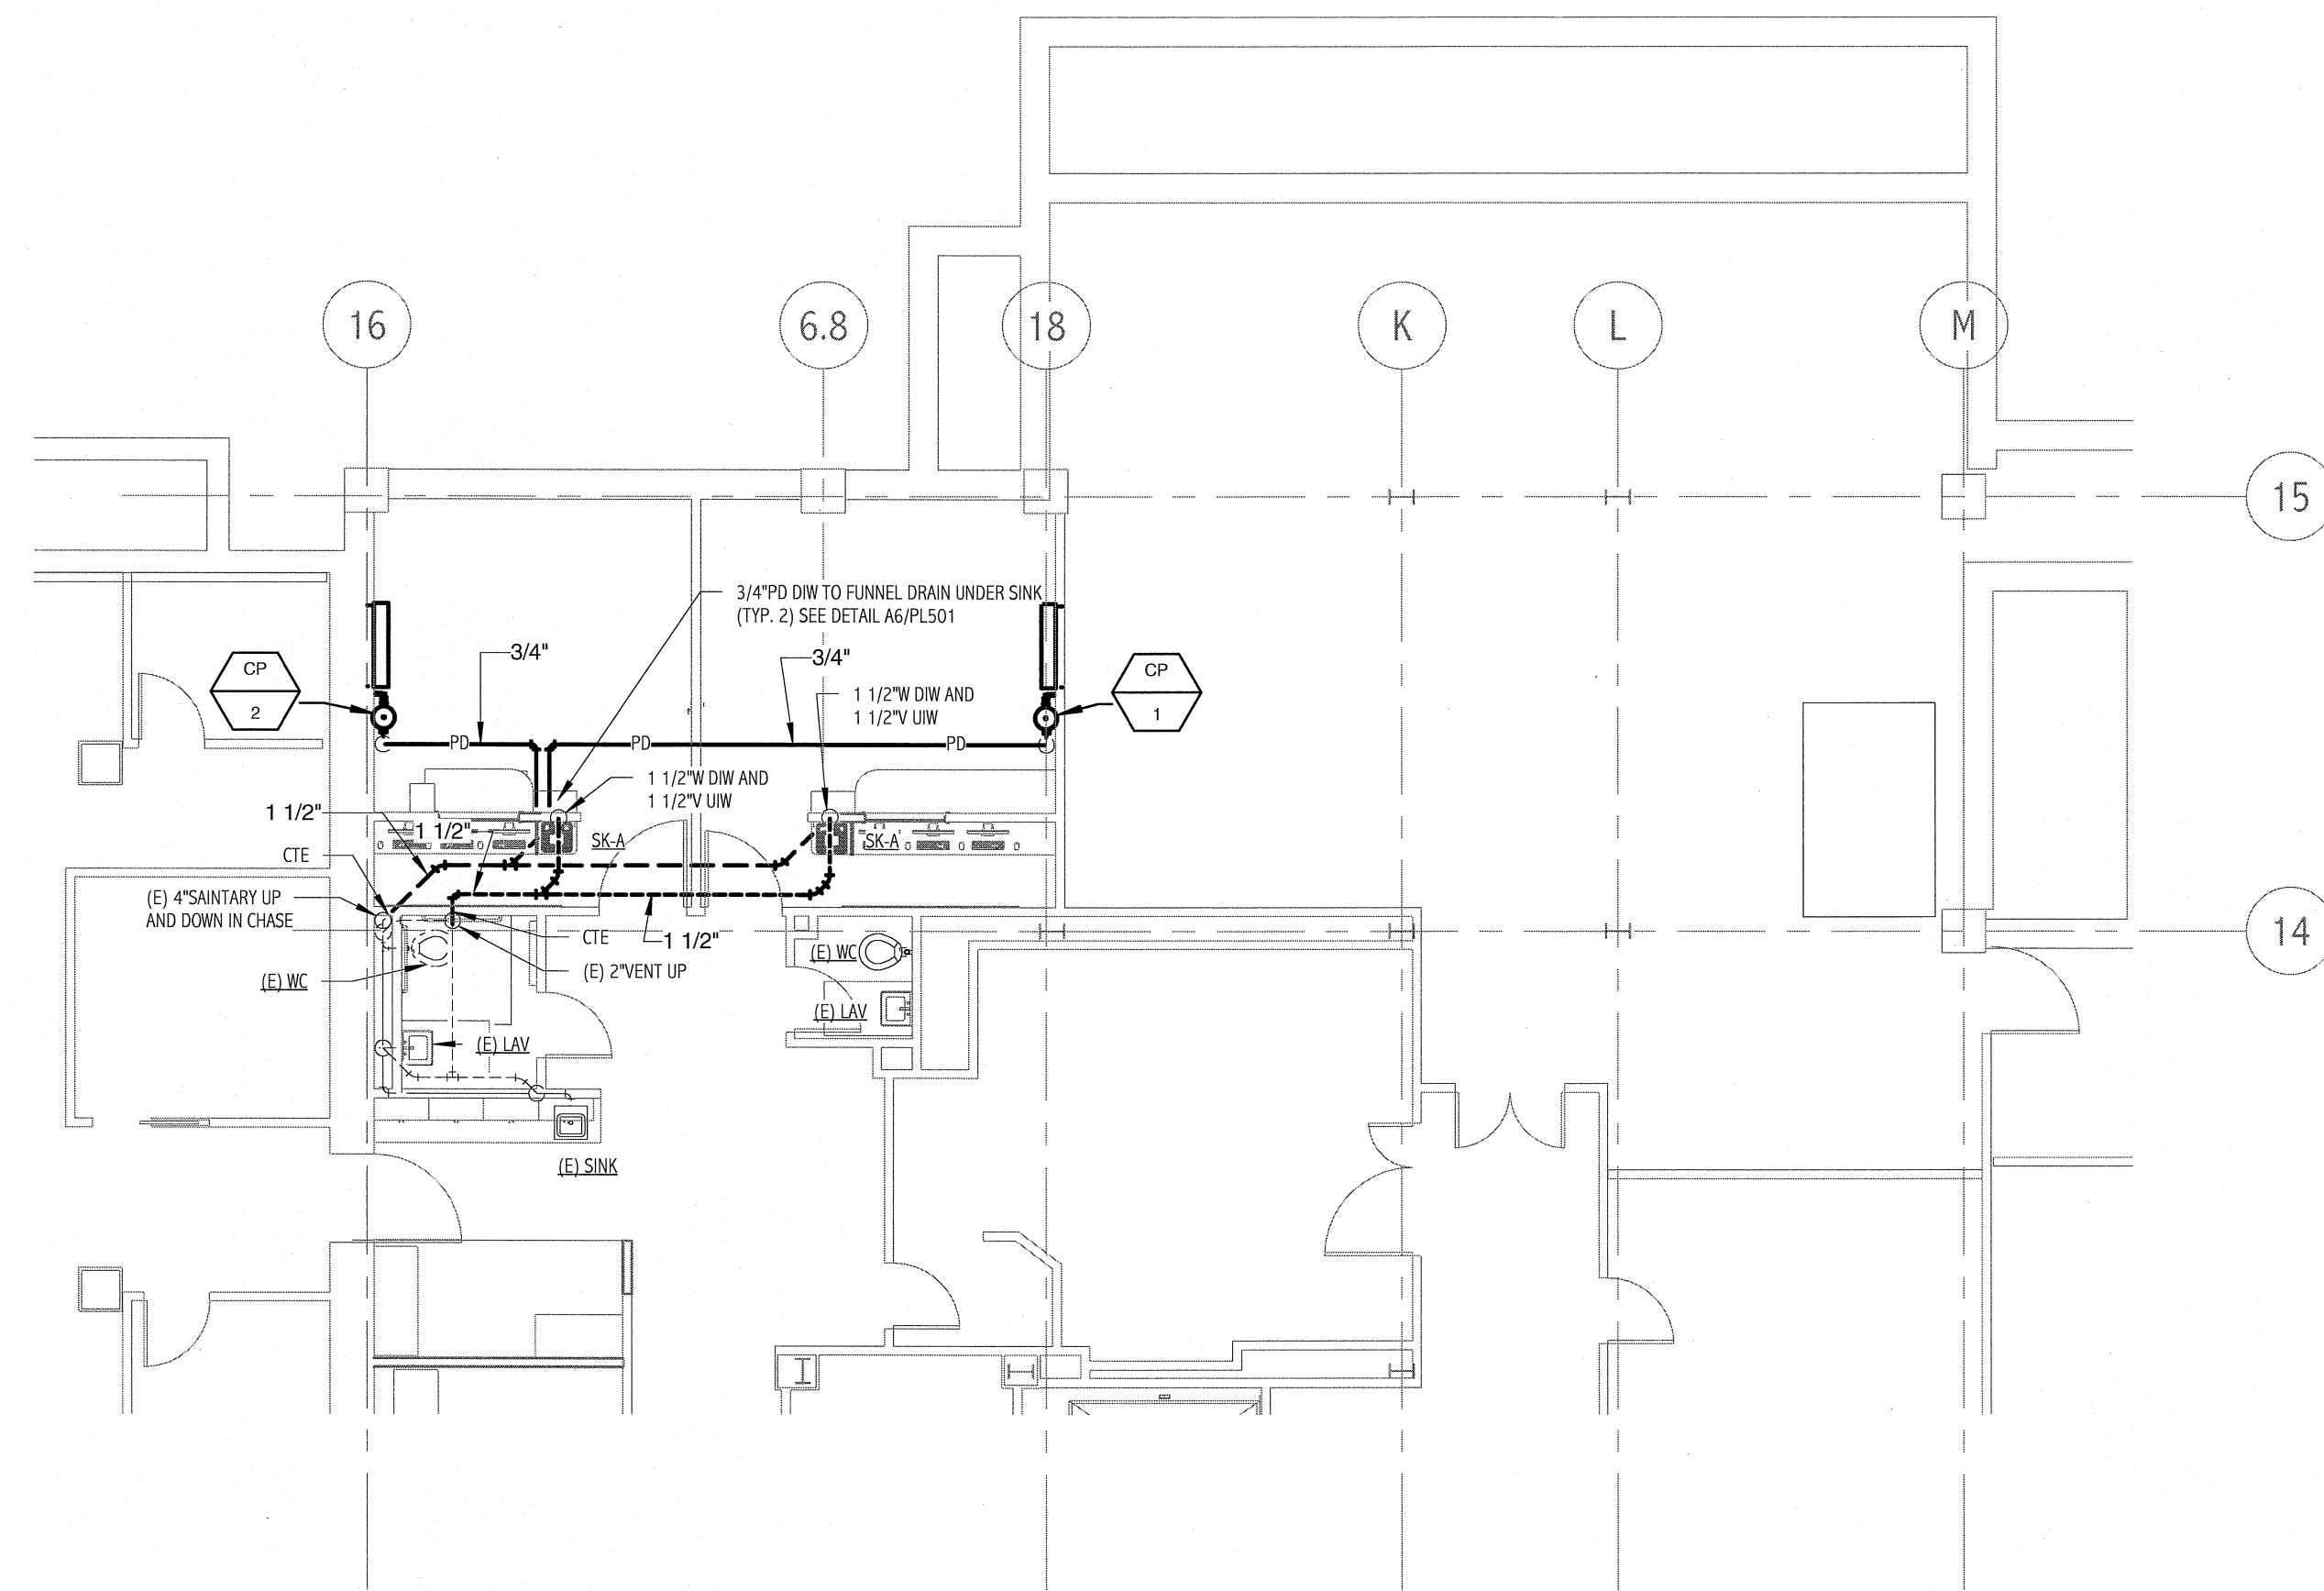

① FLUORO SANITARY PIPING PLAN
 1/8" = 1'-0"

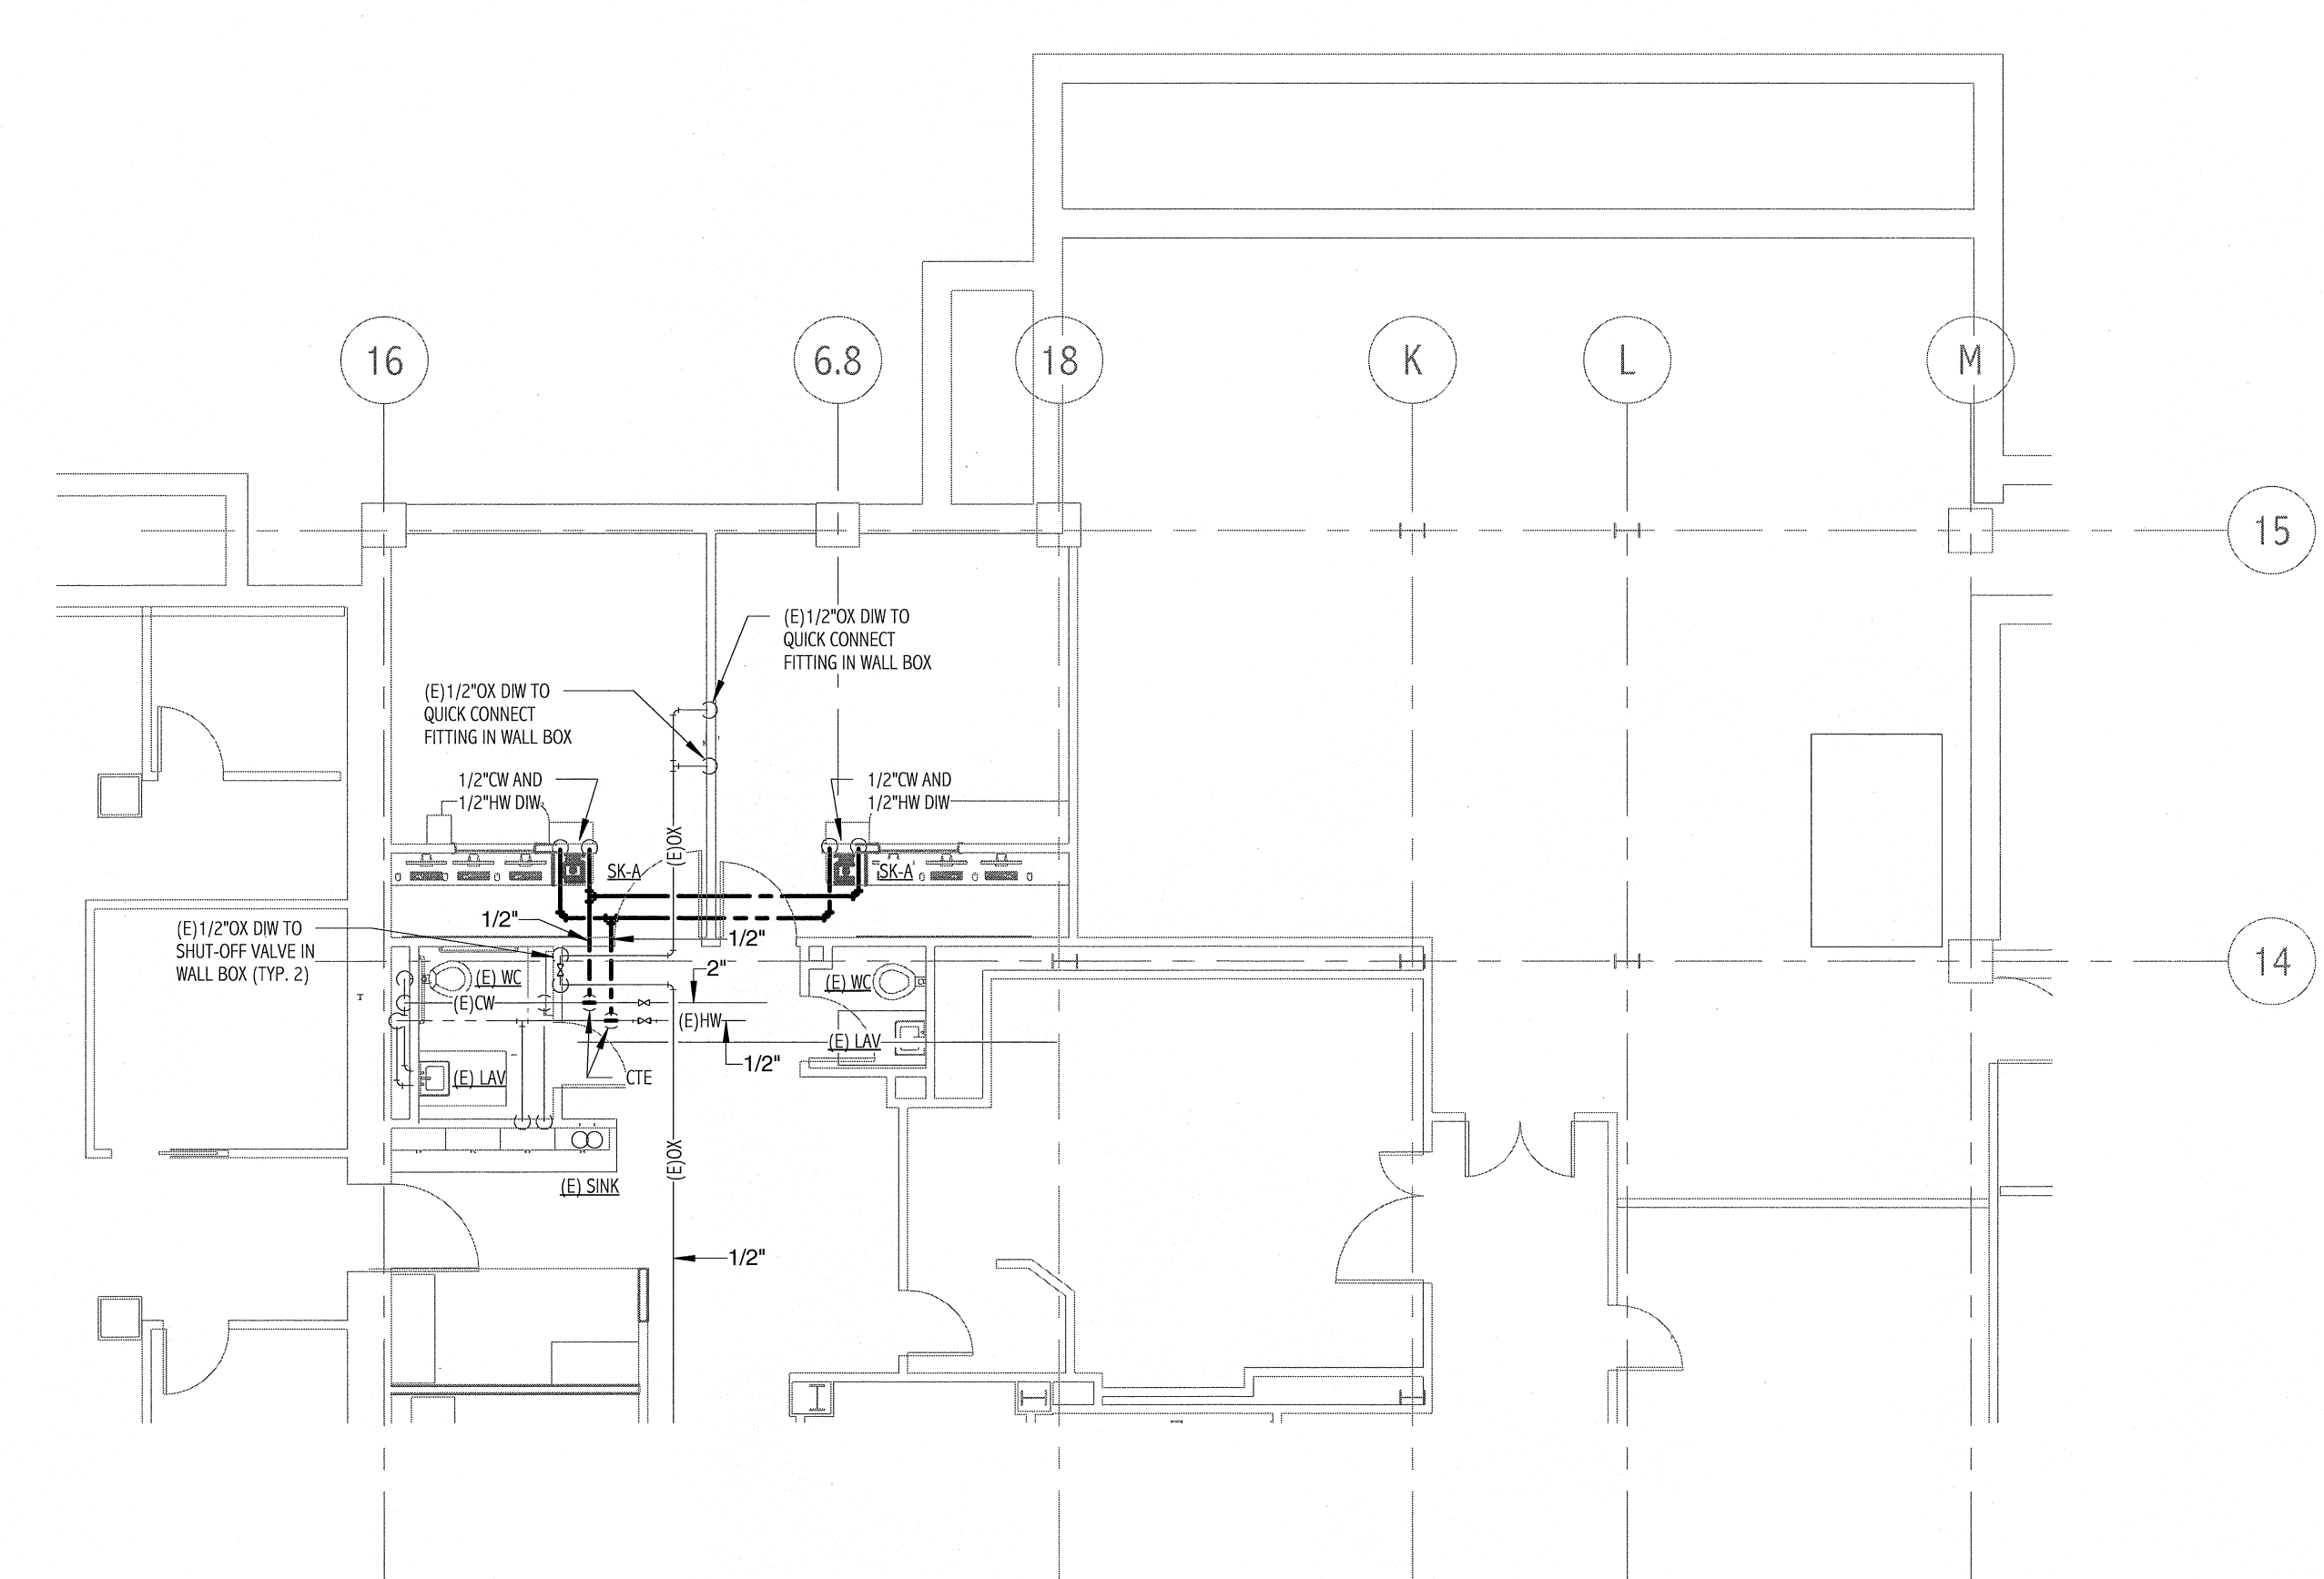

② FLUORO DOMESTIC WATER PIPING PLAN
 1/8" = 1'-0"