


LIGHTING FIXTURE SCHEDULE

FXLT. TYPE	DESCRIPTION	LAMPS			BALLAST		VOLTAGE	MANUFACTURER	CATALOG NUMBER	REMARKS
		NO.	WATTS	TYPE	NO.	INTEGRAL				
L1	CEILING RECESSED LENSED LINEAR SLOT FIXTURE	-	7.1 FT	LED	1	Y	UNV	Pinnacle	ESA-35-XX-CONTINUOUS RUNS-VERIFY-UNV-3C-W	SEE NOTES 1,4
L1D	CEILING RECESSED LENSED LINEAR SLOT FIXTURE	-	7.1 FT	LED	1	Y	UNV	Pinnacle	ESA-35-XX-CONTINUOUS RUNS-UNV-3D-W	
L2D	CEILING RECESSED LINEAR WALL WASHER	-	10 FT	LED	1	Y	UNV	PRUDENTIAL BIONIC SERIES	910-PS1D-REG-LED35-SQR-LENGTH-1MM-AWW-DIG-LP-SC-UNV-DM10	
L3D	CEILING RECESSED LINEAR WALL WASHER	-	10 FT	LED	1	Y	UNV	Pinnacle	FX3WW-3SHD1-LENGTH-UNV-1D-W	
L4D	SURFACE MOUNTED COVE FIXTURE	-	3 FT	LED	1	Y	UNV	NO LIGHTING	08-350VHO226-1-LENGTH-D	PROVIDE DEDICATED LED SECTION AND DRIVER FOR ALL EMERGENCY LIGHTING SECTIONS (REFER TO FLOOR PLAN FOR EXACT QUANTITIES)
P3 SERIES	CEILING PENDANT DISK FIXTURE	-	30	LED	1	Y	UNV	BEGALIMBURG	1556L-CUSTOM-RAL	
R1	CEILING RECESSED SQUARE DOWNLIGHT	-	17.8	LED	1	Y	UNV	LUCIFER	28E-FD1-1W-80X-13A-35-1-UNV-VERIFY-DH-NC-VERIFY-80X-13A-U-UNV-VERIFY-SSL-2	
R1D	CEILING RECESSED SQUARE DOWNLIGHT	-	17.8	LED	1	Y	UNV	LUCIFER	28E-FD1-1W-80X-13A-35-1-UNV-VERIFY-DH-NC-VERIFY-80X-13A-U-UNV-VERIFY-SSL-2	
R2	CEILING RECESSED 1" W/ FIXTURE	-	47	LED	1	Y	UNV	WILLIAMS	50G-S14-LED-UT-14-833-F-0G-MV-LAR-ED-OUT-60"UT-UNV	
R3	CEILING RECESSED LENSED WALL WASHER	-	23	LED	1	Y	UNV	LUCIFER	DL34ZP-NC-W-VERIFY-8013-35-3D-NC-VERIFY-VERIFY-8013-UNVADLA-APP-2-SQ-3	
R3D	CEILING RECESSED LENSED WALL WASHER	-	23	LED	1	Y	UNV	LUCIFER	DL34ZP-NC-W-VERIFY-8013-35-3D-NC-VERIFY-VERIFY-8013-UNVADLA-APP-2-SQ-3	
R4D	CEILING RECESSED LINEAR ASYMMETRICAL EXAM ROOM FIXTURE	-	43.2	LED	1	Y	UNV	WILLIAMS	M02C-4-LEPPH0838-ARCHA118-SGM1-LAR-ED07H-UNV	
UC	UNDERCABINET TASK LIGHT	-	T80	LED	1	Y	UNV	HEALTHCARE LIGHTING	HUCS-MVOLT-LED35-0IM-ACCESSORIES-AS-RECO-AM	
W1	SURFACE MOUNTED DECORATIVE WALL SCONCE	-	7.35	LED	1	Y	UNV	VIBRA	5449-S0LED	
W2	RECESSED NIGHT LIGHT	-	15	LED	1	Y	UNV	EVERLITE	SOV-AC-R-1C-1W-XX-XX-PP-SD	
EX1	SURFACE MOUNTED SINGLE FACE EXIT SIGN	-	2	LED	1	Y	UNV	EVERLITE	SOV-AC-R-2M-WH-PP-XX-PP-SD	COORDINATE ARROW DIRECTIONS WITH FLOOR PLANS
EX2	SURFACE MOUNTED DOUBLE FACE EXIT SIGN	-	2	LED	1	Y	UNV	EVERLITE	SOV-AC-R-2M-WH-PP-XX-PP-SD	COORDINATE ARROW DIRECTIONS WITH FLOOR PLANS


LIGHTING FIXTURE SCHEDULE NOTES:
 1. COORDINATE ALL FIXTURE FINISH COLORS WITH ARCHITECT PRIOR TO BID.
 2. COORDINATE COLOR AND TEMPERATURE OF ALL LAMPS WITH ARCHITECT.
 3. COORDINATE FIXTURE LENGTHS WITH ARCHITECTURAL FLOOR PLANS.
 4. COORDINATE FIXTURE TRIM WITH CEILING TYPE WHERE FIXTURE IS BEING INSTALLED.

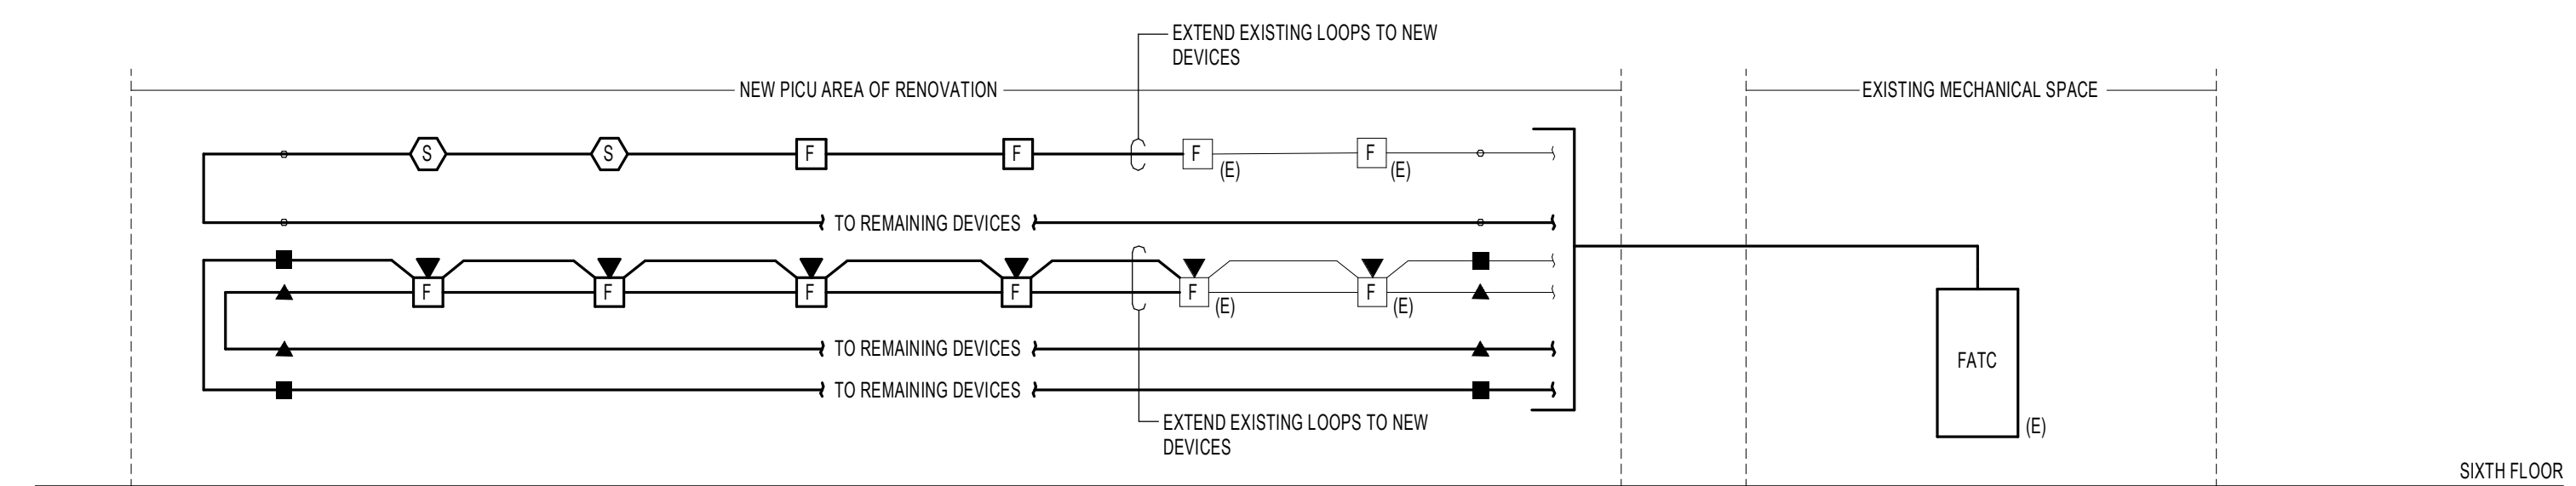

1 PARTIAL FIRE ALARM RISER DIAGRAM
SCALE: N.T.S.

FIRE ALARM WIRING LEGEND:

- CLASS "A" ADDRESSABLE SIGNAL CIRCUIT
- CLASS "A" AUDIO EVAC. CIRCUITS
- CLASS "A" STROBE/HANDICAP LIGHT
- INDICATES CONTINUATION OF WIRING TYPE

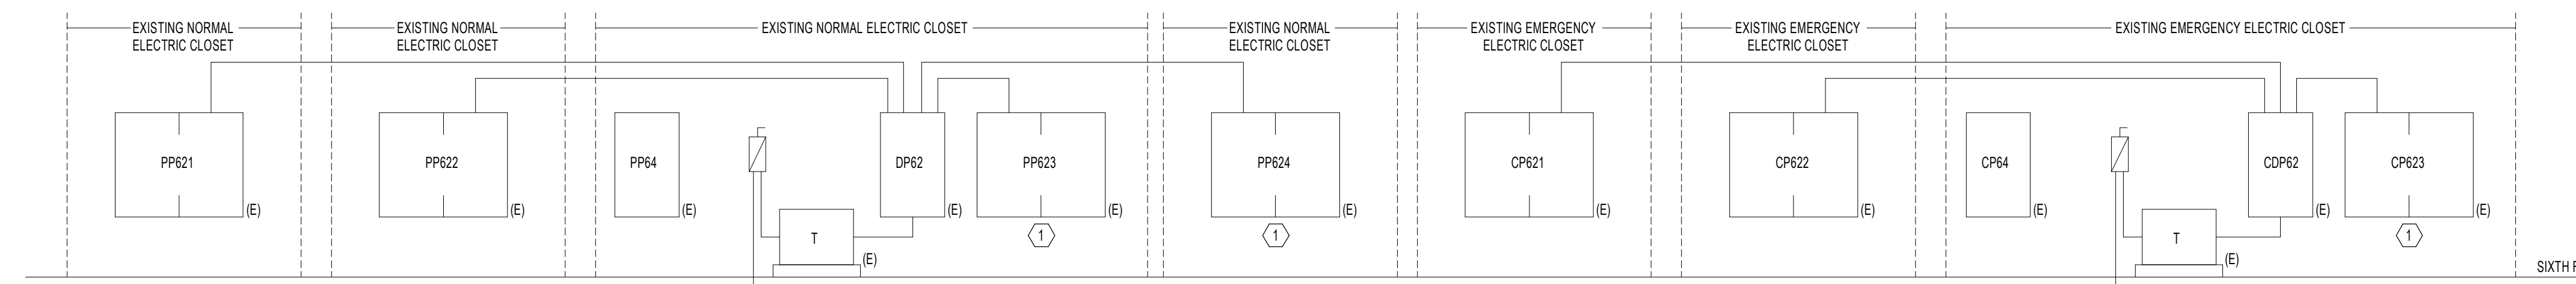

1 PARTIAL POWER RISER DIAGRAM
SCALE: N.T.S.

RISER DIAGRAM KEY NOTES:

- 1. PRIOR TO TIE-IN ELECTRICAL CONTRACTOR SHALL METER EXISTING PANELBOARD PER NEC 2014 ARTICLE 230.9F AND HAVE THE FINDINGS COMPILED INTO A REPORT. A COPY OF THIS REPORT SHALL BE GIVEN TO THE ARCHITECT AND ENGINEER UPON METERING COMPLETION. ELECTRICAL CONTRACTOR SHALL NOT ROUGH-IN NEW FEEDER UNTIL REPORT HAS BEEN REVIEWED BY THE ENGINEER.

Revisions

**DRAFT - PROGRESS PRINT
NOT FOR CONSTRUCTION**

NO.	ISSUE	DATE
2	Addendum 2	06-03-15
1	Addendum 1	05-22-15

Sheet Information

Date: MAY 1, 2015
 Job Number: B140185-000
 Drawn: GN
 Checked: RAC
 Approved: RAC
 Title:

**ELECTRICAL
RISER DIAGRAMS
AND SCHEDULES**

Sheet

E00-10