


PL:Project:16100000B:16100000B:16100000B:Design:Main:CAD:Elect:1610000000_E-100.dwg LOGIN: Roy, Adam PLOT DATE: 5/2/2016 5:54 PM SAVE DATE: 5/2/2016 5:28 PM

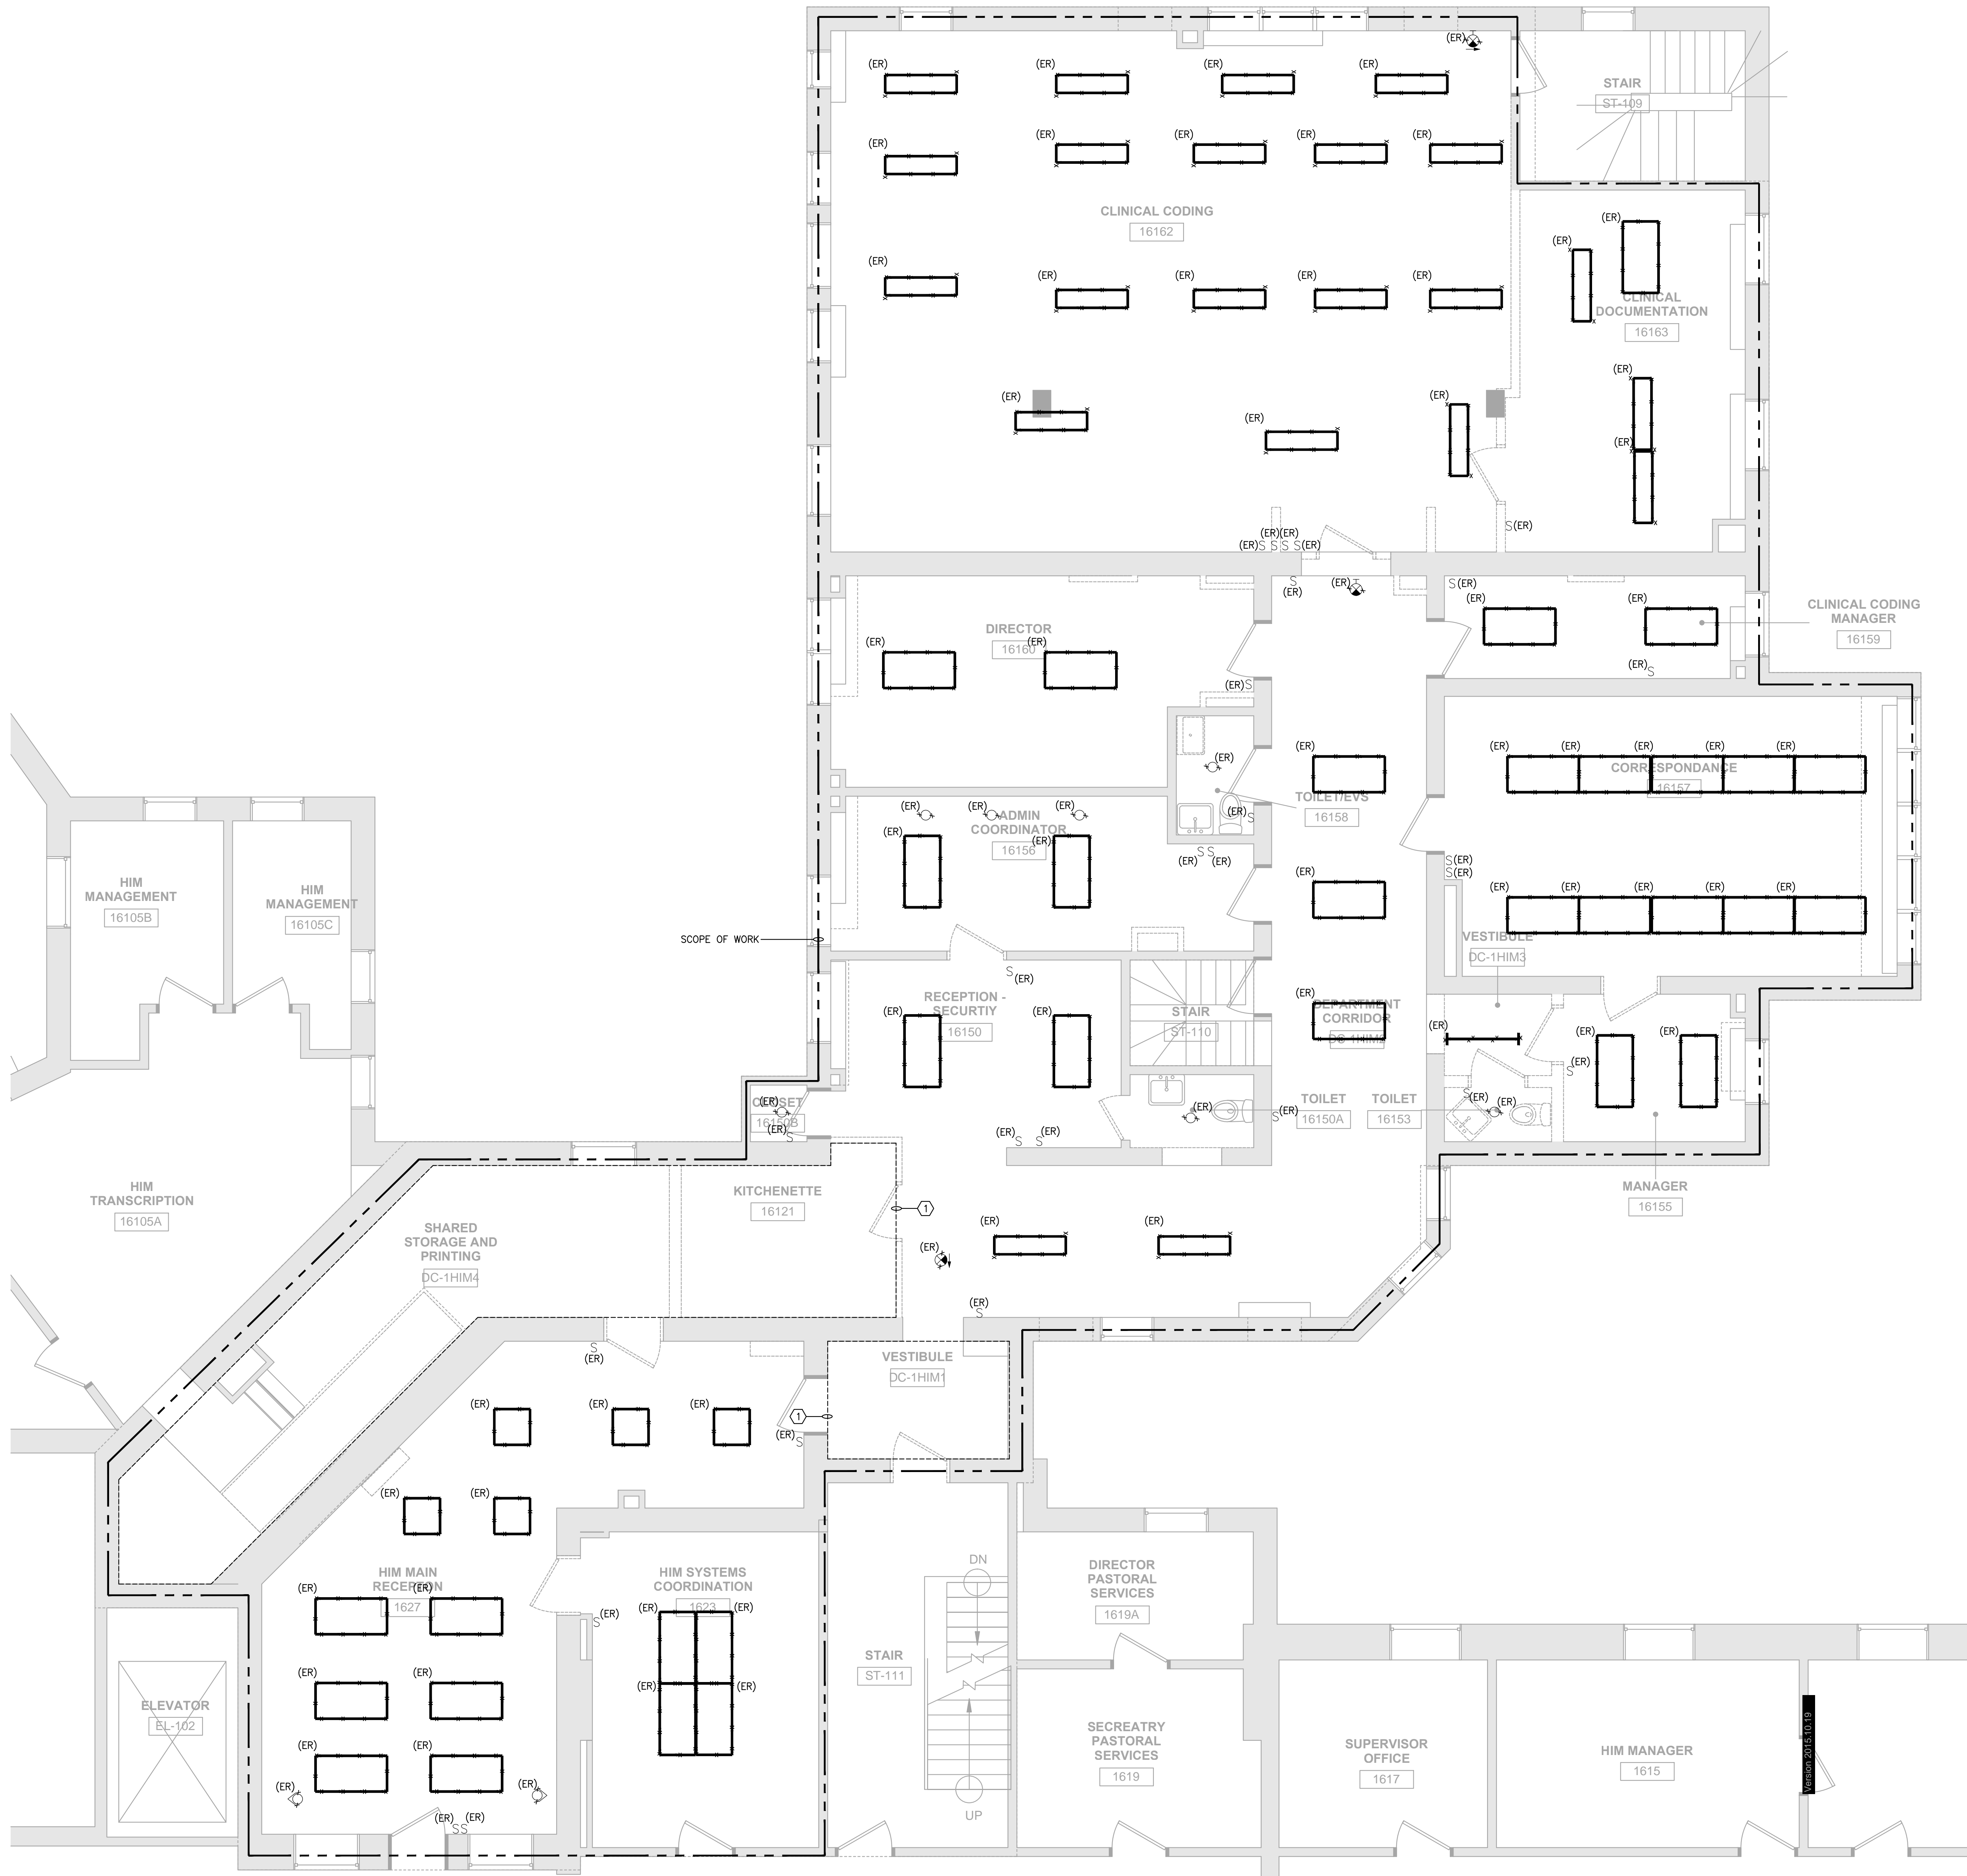

- DRAWING NOTES:**
1. REFER TO DRAWINGS E-000, E-500 AND E-501 FOR LEGEND, SYMBOLS, DEMOLITION NOTES, GENERAL NOTES AND SPECIFICATIONS.
 2. REFER TO ARCHITECTURAL DRAWINGS FOR EXACT LIMIT OF DEMOLITION.
 3. CONTRACTOR SHALL VERIFY ANY DEVICE AND/OR CIRCUIT IN QUESTION PRIOR TO ANY DEMOLITION.
 4. INVENTORY REMOVED ELECTRICAL LIGHTING FIXTURES AND ELECTRICAL EQUIPMENT. PROVIDE A LIST TO THE OWNER FOR THEIR SELECTION OF ITEMS TO BE RETAINED. ALL ITEMS SELECTED TO BE RETAINED SHALL BE STORED IN A LOCATION DESIGNATED BY OWNER. ALL ITEMS REJECTED BY THE OWNER SHALL BECOME THE PROPERTY OF THE CONTRACTOR AND SHALL BE REMOVED FROM THE SITE.

- KEY NOTES:**
- ① DISCONNECT AND REMOVE ALL LIGHT FIXTURES, CONTROLS, AND ASSOCIATED BRANCH CIRCUIT WIRING BACK TO SOURCE.

CIRCUIT TRACING NOTE:

ELECTRICAL CONTRACTOR SHALL UPDATE ALL EXISTING PANELBOARD DIRECTORIES TO REFLECT ALL CIRCUITS MADE SPARE FROM DEMOLITION. ALL EXISTING CIRCUIT BREAKERS IN ALL EXISTING PANELBOARDS SHOWN ON THE DRAWINGS SHALL BE TRACED OUT AND LABELED IN PANELBOARD OF ORIGIN. ALL CIRCUITS AND RACEWAY THAT ARE NO LONGER IN USE SHALL BE REMOVED AND PULLED BACK TO PANEL OF ORIGIN. ALL CIRCUIT BREAKERS NOT BEING UTILIZED SHALL BE LABELED AS SPARE AND PUT IN THE OPEN (OFF) POSITION.

225 Franklin Street, Suite 1100
Boston, MA 02110
1617.478.0300
1617.478.0321
www.perkinswill.com

CONSULTANTS

MEFPF
AKF GROUP LLC
99 Bedford St., 2nd Floor
Boston, MA 02111
1617.737.1111
1617.737.4311

PROJECT

ACCU RELOCATION
22 Bramhall Street
Portland, Maine 04102



MAINE MEDICAL CENTER
22 Bramhall Street
Portland, Maine 04102

ISSUED FOR CONSTRUCTION
05/02/2016
ISSUE CHART

NO	ISSUE	DATE
Job Number	B160089-000	
Checked		
Approved		

TITLE

ELECTRICAL FLOOR PLAN - LIGHTING DEMOLITION

SHEET NUMBER

E-100