


0 1 2 3 4

PL: Projects\B1600089\B1600089-000-Design\Main\CAD\Richards 7-9-RELEC\B1600089-000_E03-04_ELEC.dwg
LOGIN: Roy, Adam
PLOT DATE: 7/29/2016 9:45 AM
SAVE DATE: 7/29/2016 3:32 PM

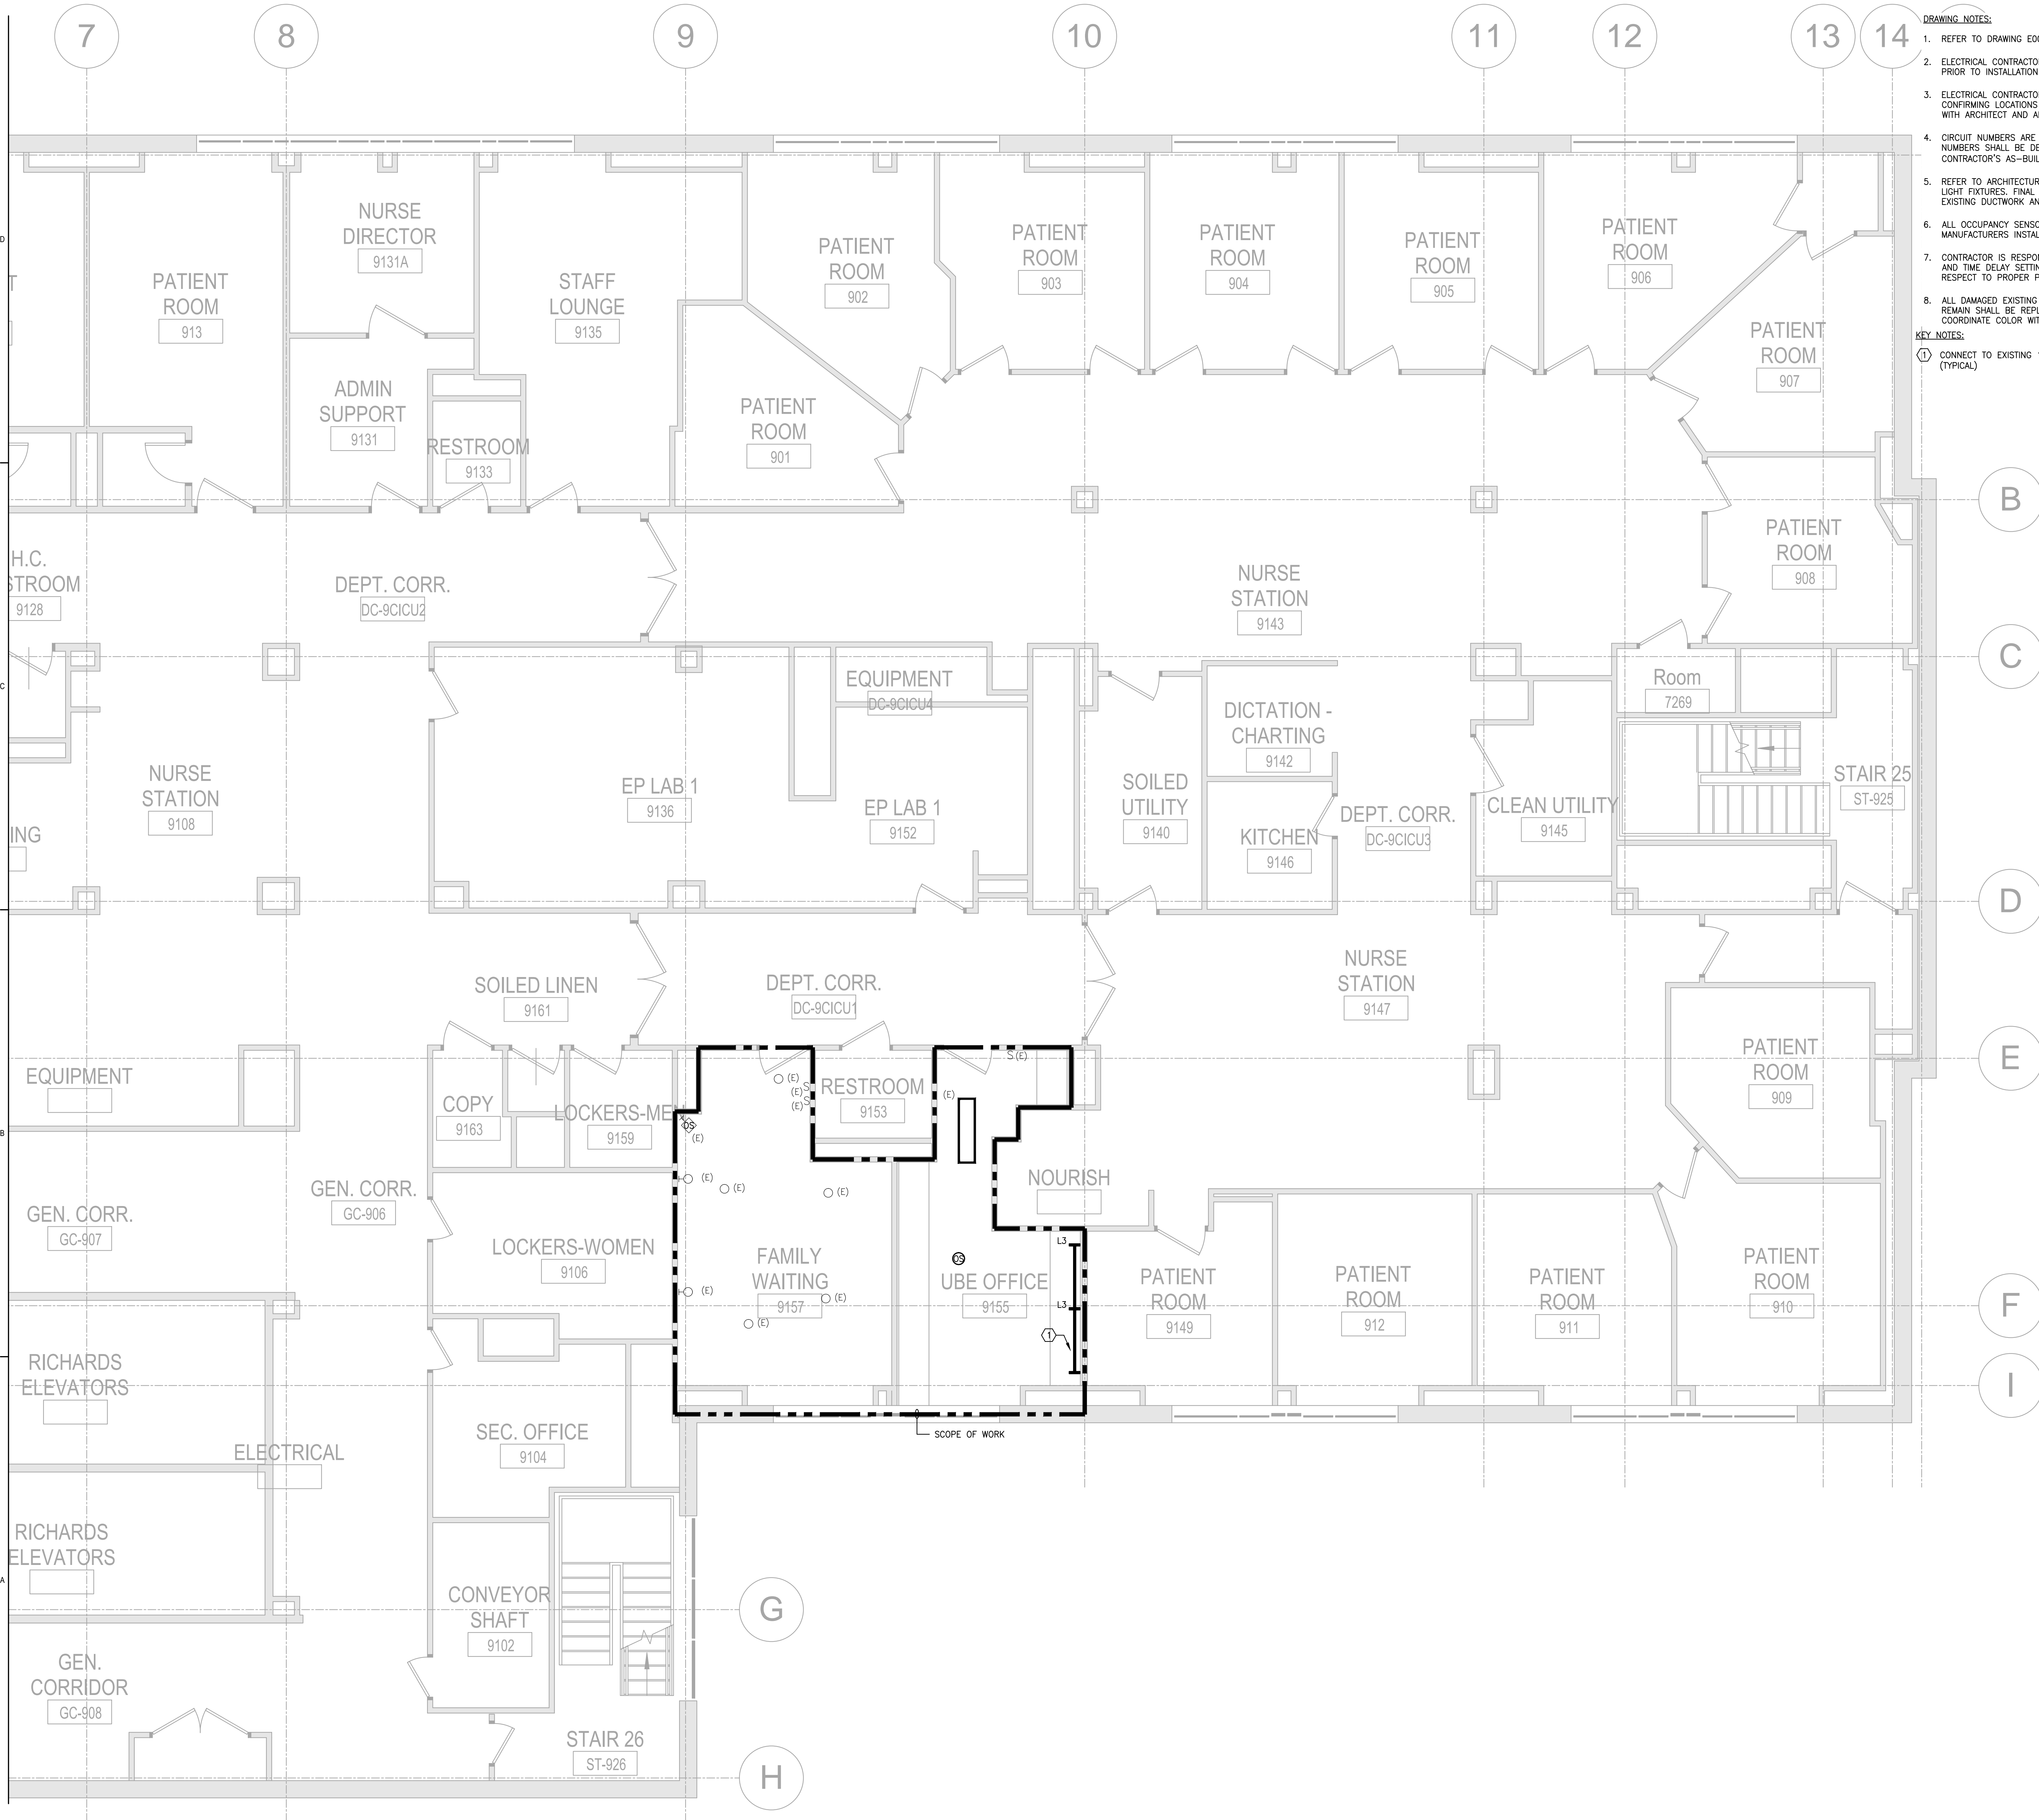

- DRAWING NOTES:**
- REFER TO DRAWING E00-01 FOR LEGEND, SYMBOLS, AND GENERAL NOTES.
 - ELECTRICAL CONTRACTOR SHALL COORDINATE NEMA RATINGS OF ALL DEVICES PRIOR TO INSTALLATION.
 - ELECTRICAL CONTRACTOR SHALL BE RESPONSIBLE FOR COORDINATING AND CONFIRMING LOCATIONS AND MOUNTING HEIGHTS OF ALL ELECTRICAL DEVICES WITH ARCHITECT AND ARCHITECTURAL DRAWINGS.
 - CIRCUIT NUMBERS ARE SHOWN FOR DESCRIPTIVE PURPOSES ONLY. EXACT NUMBERS SHALL BE DETERMINED IN FIELD AND SHALL BE NOTED ON THE CONTRACTOR'S AS-BUILT DRAWINGS.
 - REFER TO ARCHITECTURAL REFLECTED CEILING PLAN FOR EXACT LOCATION OF LIGHT FIXTURES. FINAL LOCATIONS SHALL BE COORDINATED IN FIELD TO AVOID EXISTING DUCTWORK AND PIPING.
 - ALL OCCUPANCY SENSOR LOCATIONS ARE APPROXIMATE. REFER TO MANUFACTURERS INSTALLATION INSTRUCTIONS PRIOR TO INSTALLATION.
 - CONTRACTOR IS RESPONSIBLE FOR PROPER OCCUPANCY SENSOR SENSITIVITY AND TIME DELAY SETTINGS AND FIELD VERIFICATION OF CIRCUITS WITH RESPECT TO PROPER PLACEMENT.
 - ALL DAMAGED EXISTING LOCAL LIGHTING SWITCHES OR DEVICES THAT ARE TO REMAIN SHALL BE REPLACED WITH NEW DEVICES AND FACE PLATES. COORDINATE COLOR WITH ARCHITECT.
- KEY NOTES:**
- CONNECT TO EXISTING 120V NORMAL LIGHTING BRANCH CIRCUIT SERVING AREA. (TYPICAL)

PERKINS+WILL
225 Franklin Street, Suite 1100
Boston, MA 02110
1617.478.0300
1617.478.0321
www.perkinswill.com

CONSULTANTS
AKF GROUP LLC
99 Bedford St., 2nd Floor
Boston, MA 02111
1617.737.1111
1617.737.4311

STRUCTURAL
SGH INC.
41 Seyon St.
Waltham, MA 02453
1781.907.9000
1781.907.9009

PROJECT
ACCU RELOCATION
22 Bramhall Street
Portland, Maine 04102

Maine Medical Center
MaineHealth

MAINE MEDICAL CENTER
22 Bramhall Street
Portland, Maine 04102

ISSUED FOR BID
07.29.2016
ISSUE CHART

NO.	ISSUE	DATE
	ISSUED FOR BID	07.29.2016
	ISSUED FOR PERMIT	06.24.2016
Job Number	B160089-000	
Checked	MFR	
Approved		

TITLE
RICHARDS 9 - ELECTRICAL LIGHTING PLAN - EAST
SHEET NUMBER
E03-05

Scale 1/4"=1'-0"