
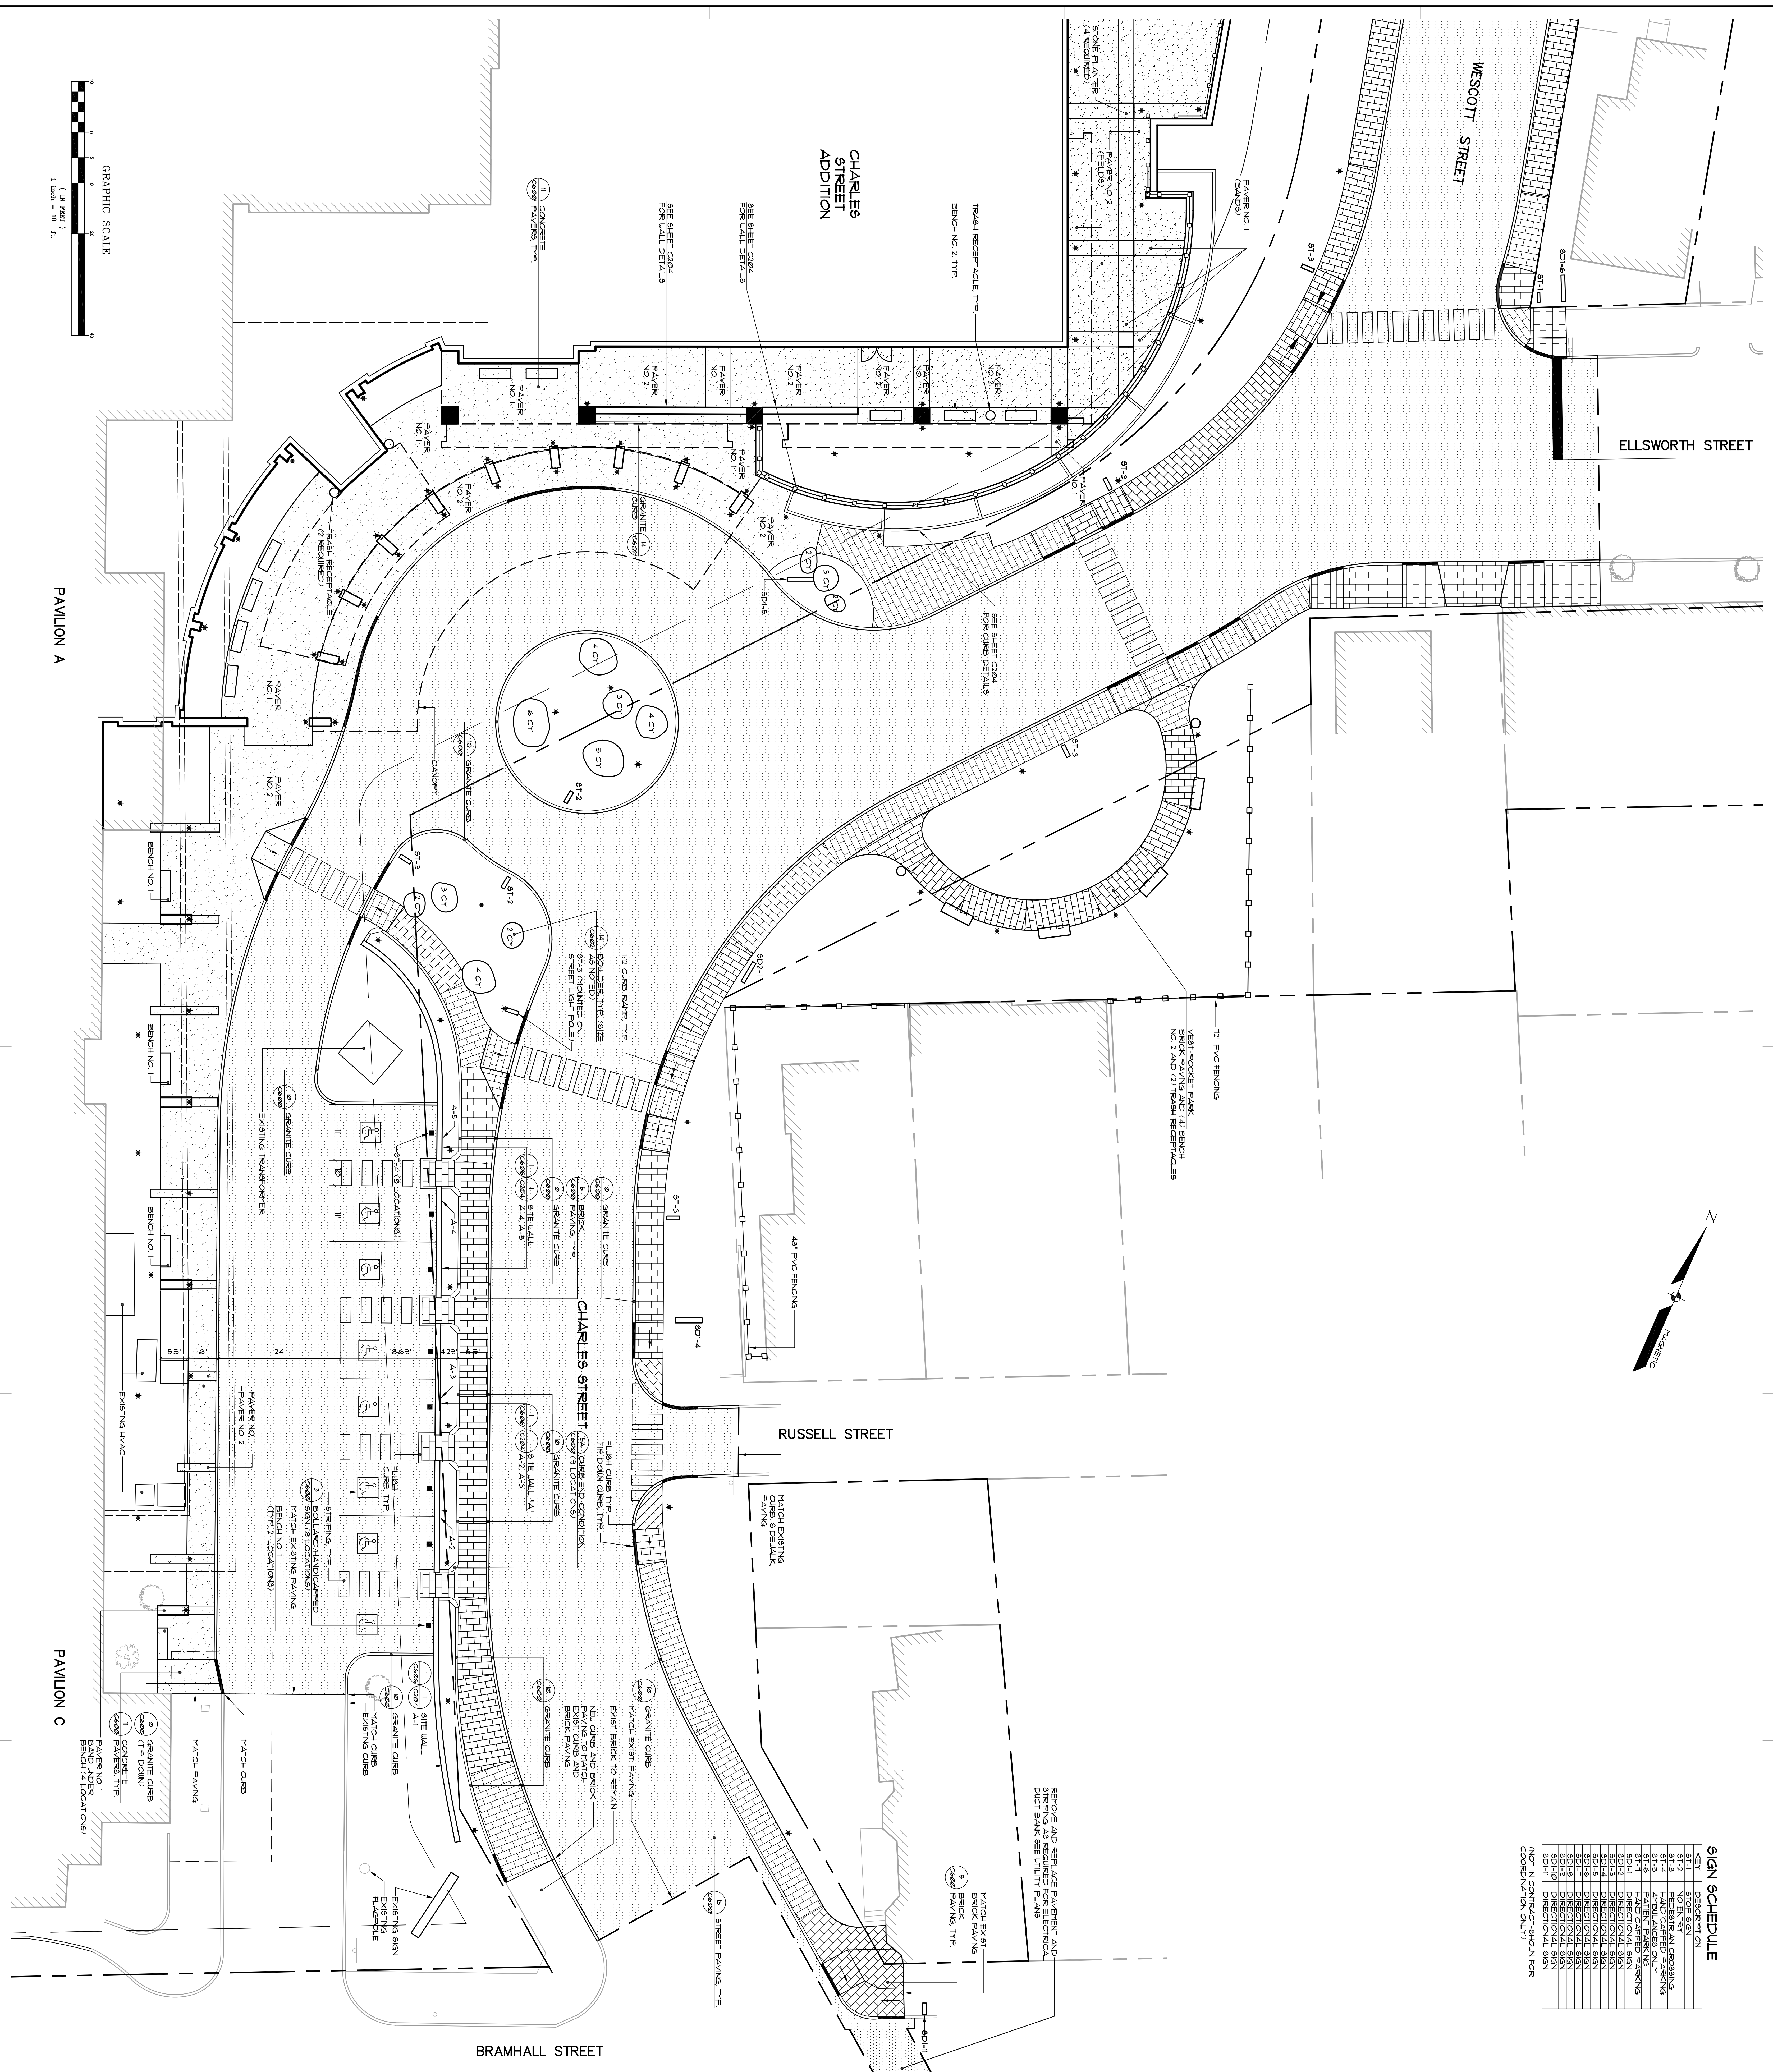


SIGN SCHEDULE


SIGN	DESCRIPTION
81-1	8' X 8' SIGN
81-2	8' X 8' SIGN
81-3	PERIPHERAL CROSSING
81-4	ADULT AMBER LIGHT
81-5	PATIENT PARKING
81-6	PATIENT PARKING
81-7	DIRECTIONAL SIGN
81-8	DIRECTIONAL SIGN
81-9	DIRECTIONAL SIGN
81-100	DIRECTIONAL SIGN

(NOT IN CONTACT-SHOWN FOR COORDINATION ONLY)

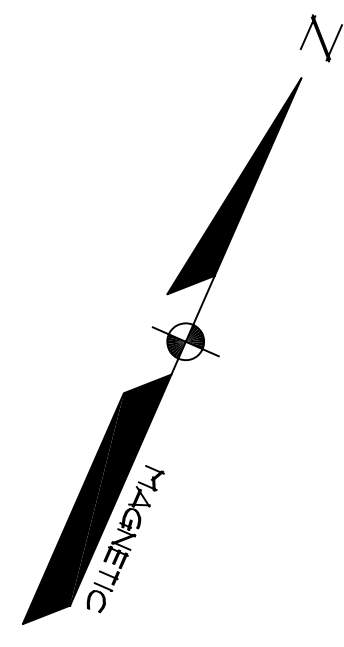

General Notes:
 1. SEE SIGN SCHEDULE FOR COMMONS. SEE SCHEDULE FOR PART OF THE SIGN SCHEDULE.
 2. THE SIGN SCHEDULE SHOWS THE LIGHTING FIXTURES. CONTRACTOR IS TO PROVIDE THE LIGHTING FIXTURES AND WIRING FOR ALL SIGNS. ALL SIGNS SHALL BE INSTALLED IN ACCORDANCE WITH THE SIGN SCHEDULE. THE CONTRACTOR SHALL BE RESPONSIBLE FOR OBTAINING ALL NECESSARY PERMITS AND APPROVALS FROM THE CITY OF PORTLAND. THE CONTRACTOR SHALL BE RESPONSIBLE FOR OBTAINING ALL NECESSARY PERMITS AND APPROVALS FROM THE CITY OF PORTLAND. THE CONTRACTOR SHALL BE RESPONSIBLE FOR OBTAINING ALL NECESSARY PERMITS AND APPROVALS FROM THE CITY OF PORTLAND. THE CONTRACTOR SHALL BE RESPONSIBLE FOR OBTAINING ALL NECESSARY PERMITS AND APPROVALS FROM THE CITY OF PORTLAND.

WORK	ISSUE DATE	DESCRIPTION
PERMIT	09/18/24	PERMIT SET
ISSUE LOG	09/27/24	80 SET

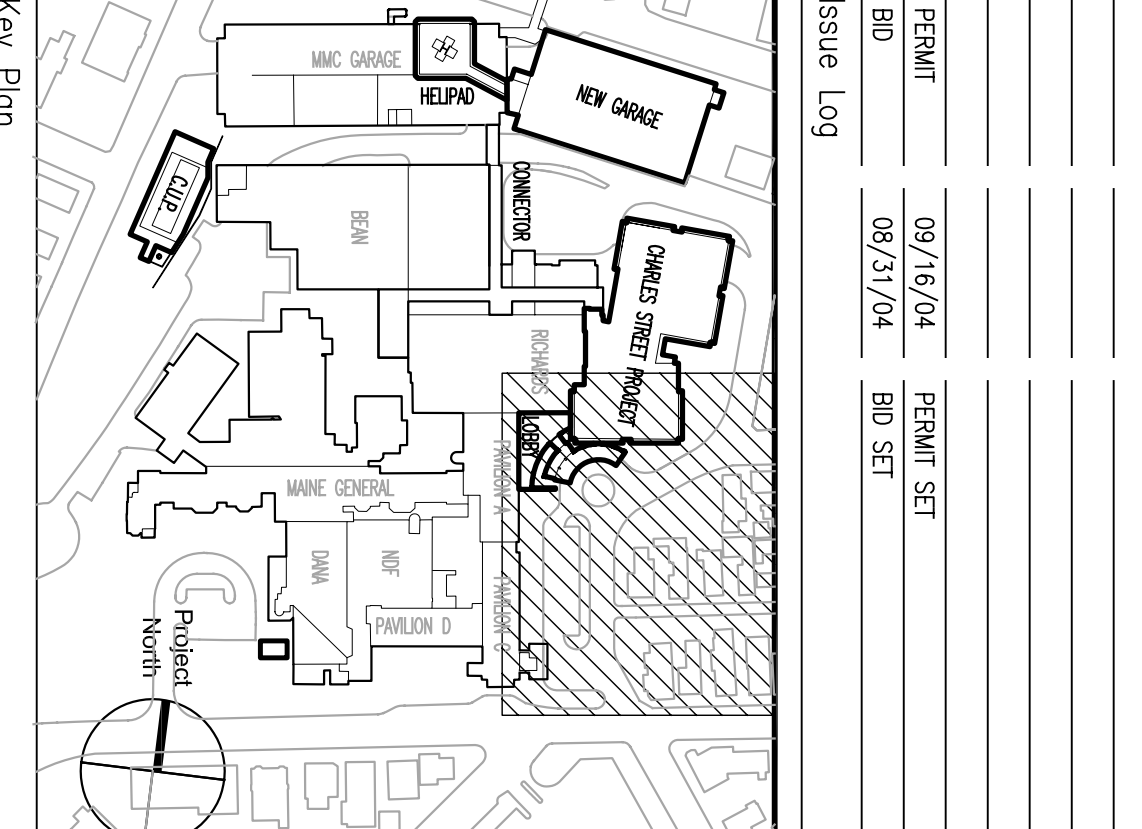

TRO
 ARCHITECTURE
 ENGINEERING
 INTERIOR DESIGN
 The Ruble Organization
 80 Bridge Street
 Portland, ME 04101
 Phone: 617-488-9400

Maine Medical Center
 Pkg C - Site Utilities
 Portland, Maine
 MMC Project No. 21846

SITE PLAN

08/27/24
 Scale: 1"=10'
 Sheet Number: PKG-C
 C103