


MATCHLINE - SEE SHEET C201



MATCHLINE - SEE SHEET C201

MATCHLINE - SEE SHEET C202

MATCHLINE - SEE SHEET C201

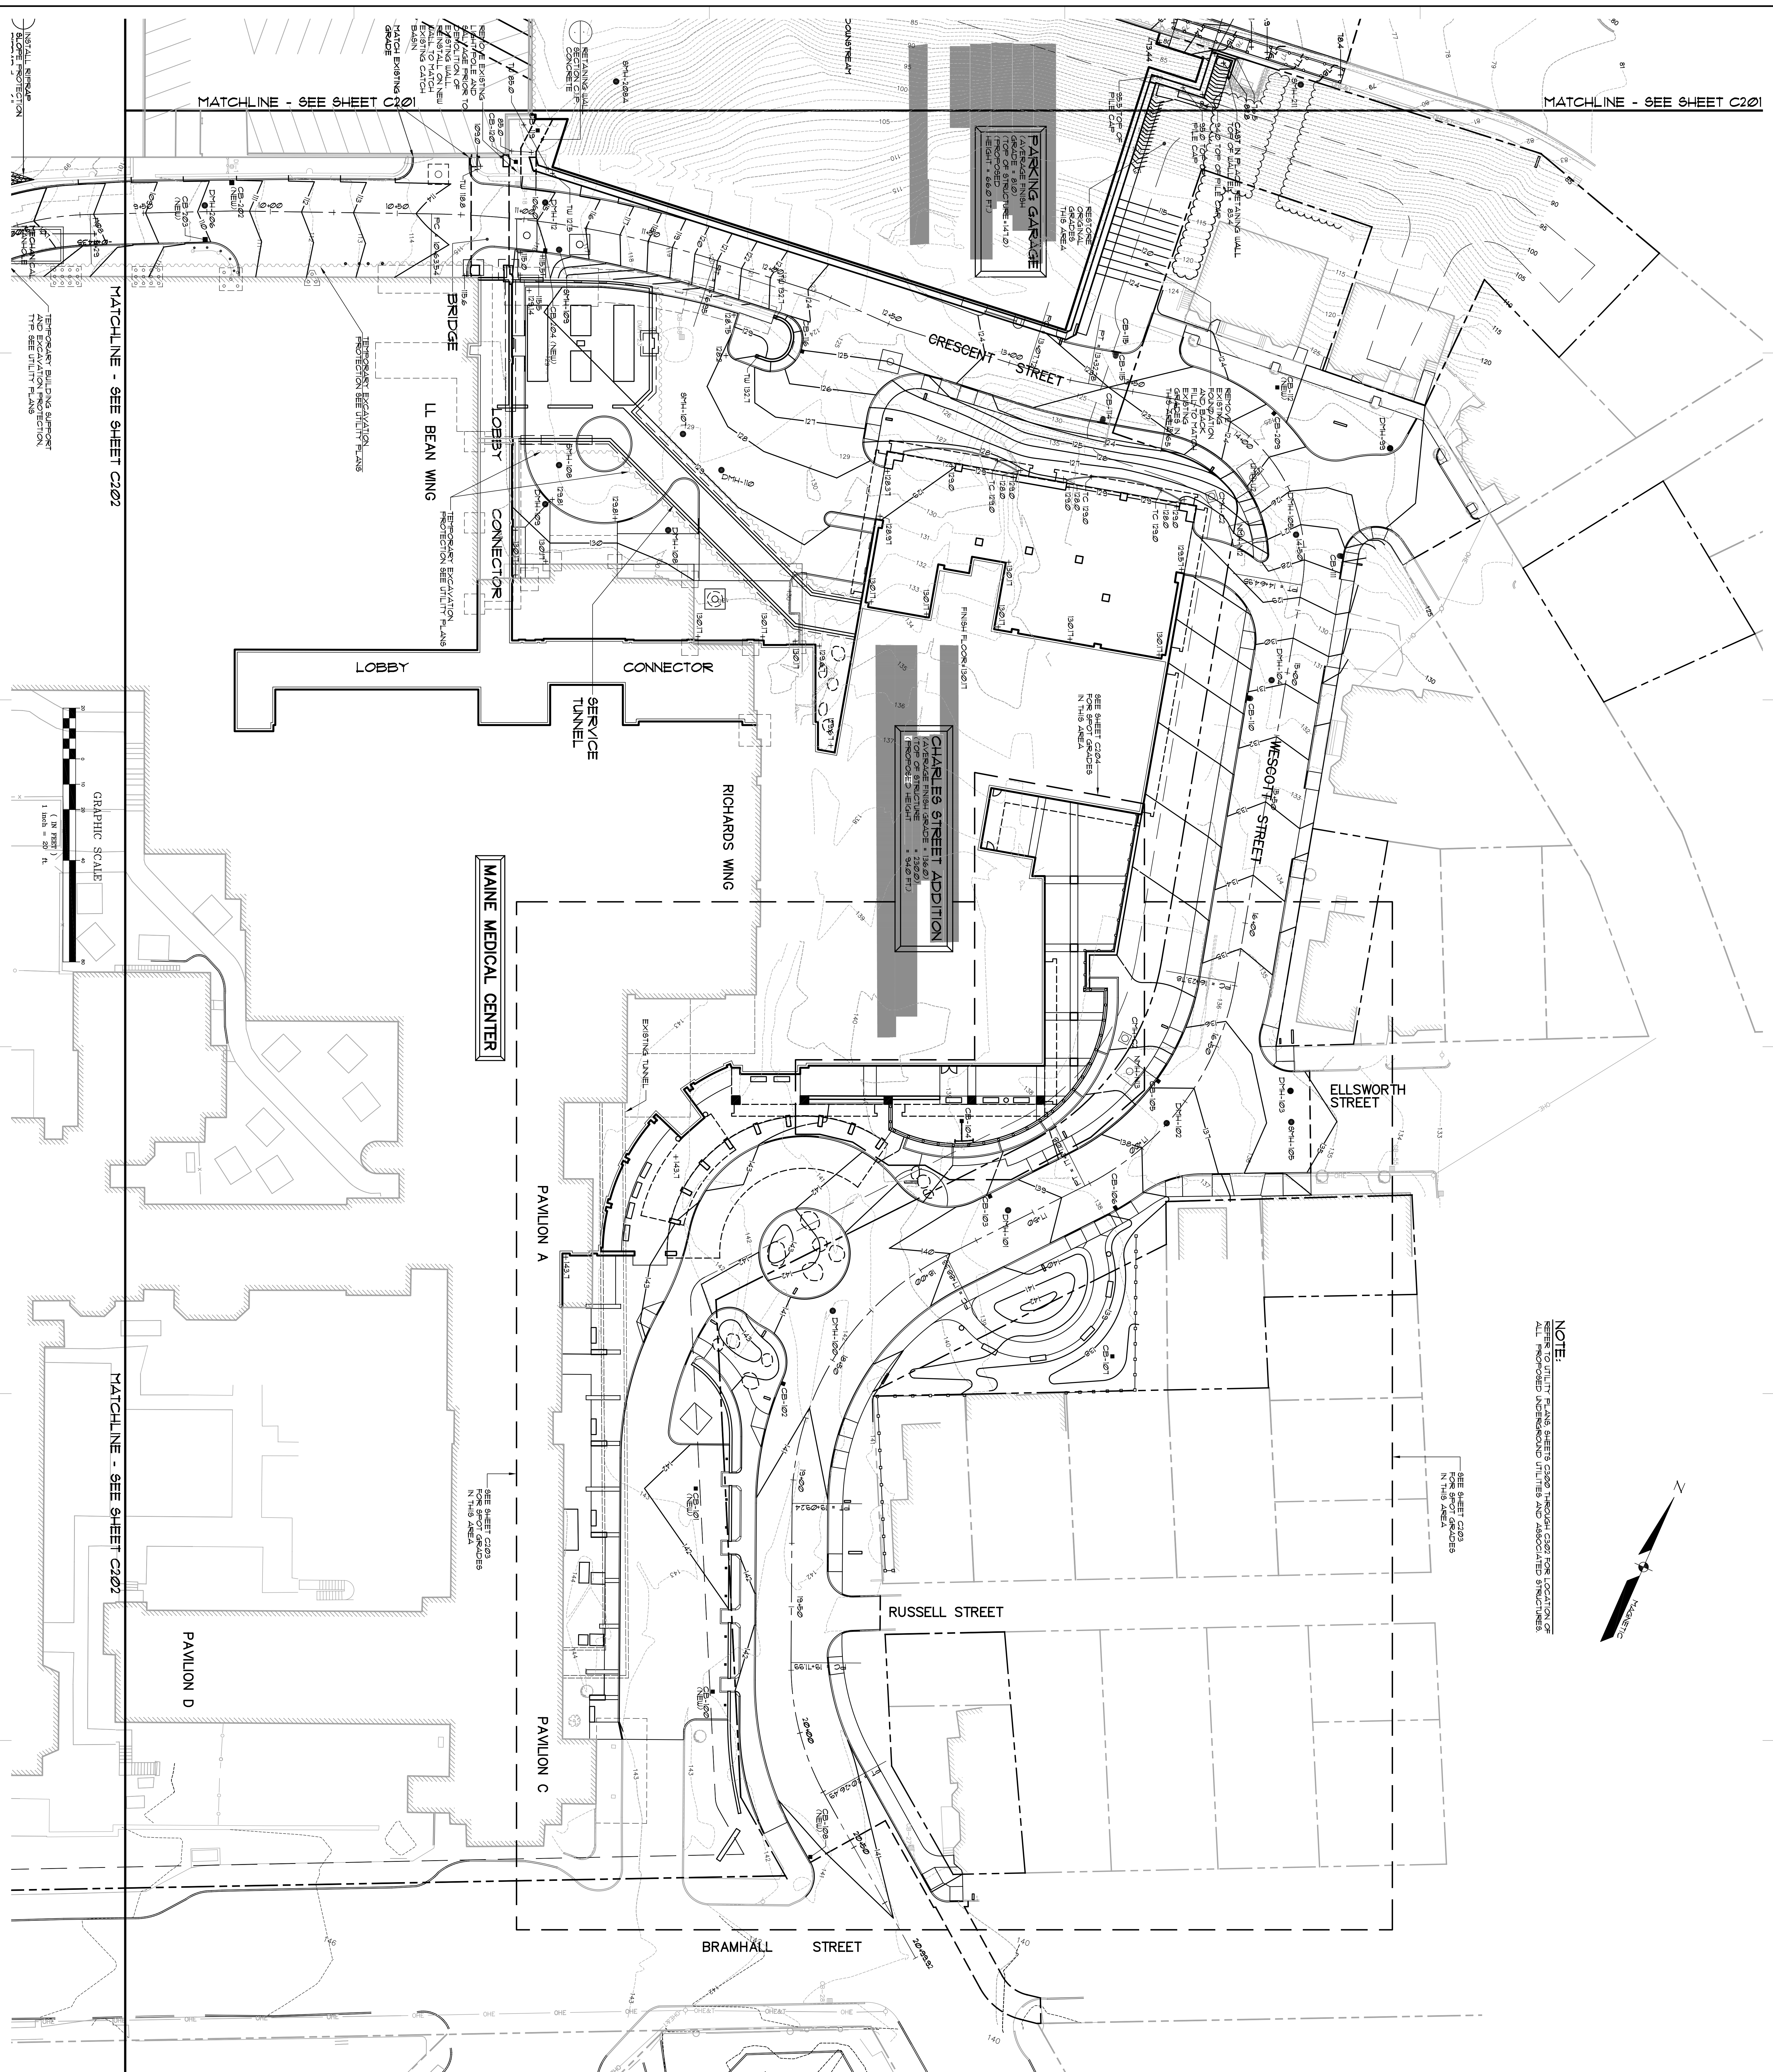

**NOTE:**  
 REFER TO UTILITY PLANS SHEETS C202 THROUGH C207 FOR LOCATION OF ALL PROPOSED UNDERGROUND UTILITIES AND ASSOCIATED STRUCTURES.

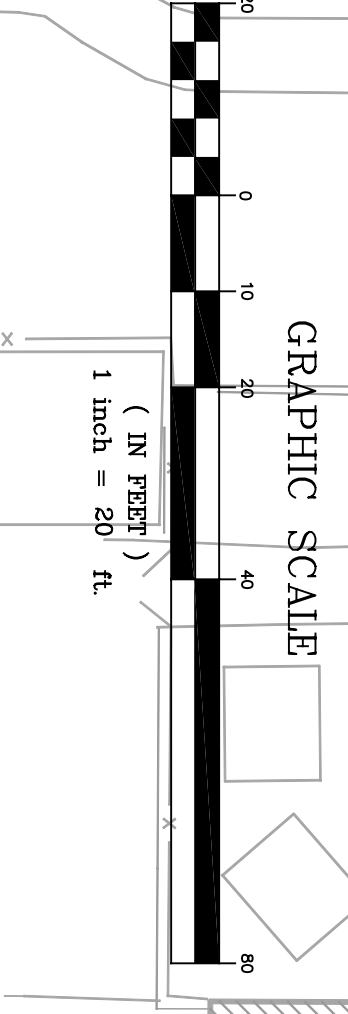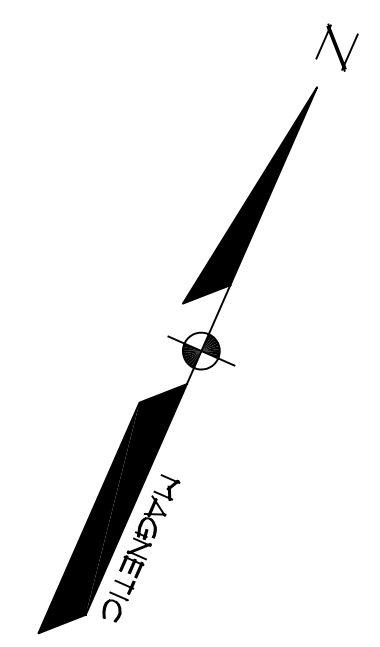

<p><b>Maine Medical Center</b>        Pkg C - Site Utilities        Portland, Maine        MMC Project No. 21846</p>		<p><b>TRO</b>        ARCHITECTURE        ENGINEERING        INTERIOR DESIGN        The Rubell Organization        80 Bridge Street        Portland, ME 04101        Phone: 617-488-9400</p>	
<p>GRADING PLAN</p>		<p>Key Plan</p>	
<p>0 10 20 40 80</p>		<p>DATE: 09/16/24        PERMIT SET        SHEET NO: 02/21/24 - 80 SET</p>	
<p>CONSTRUCTION NO: 46777        SCALE: 1"=20'        SHEET NO: 110/110</p>		<p>DATE ISSUED: 08/21/24        SHEET NUMBER: C200</p>	

General Notes: